

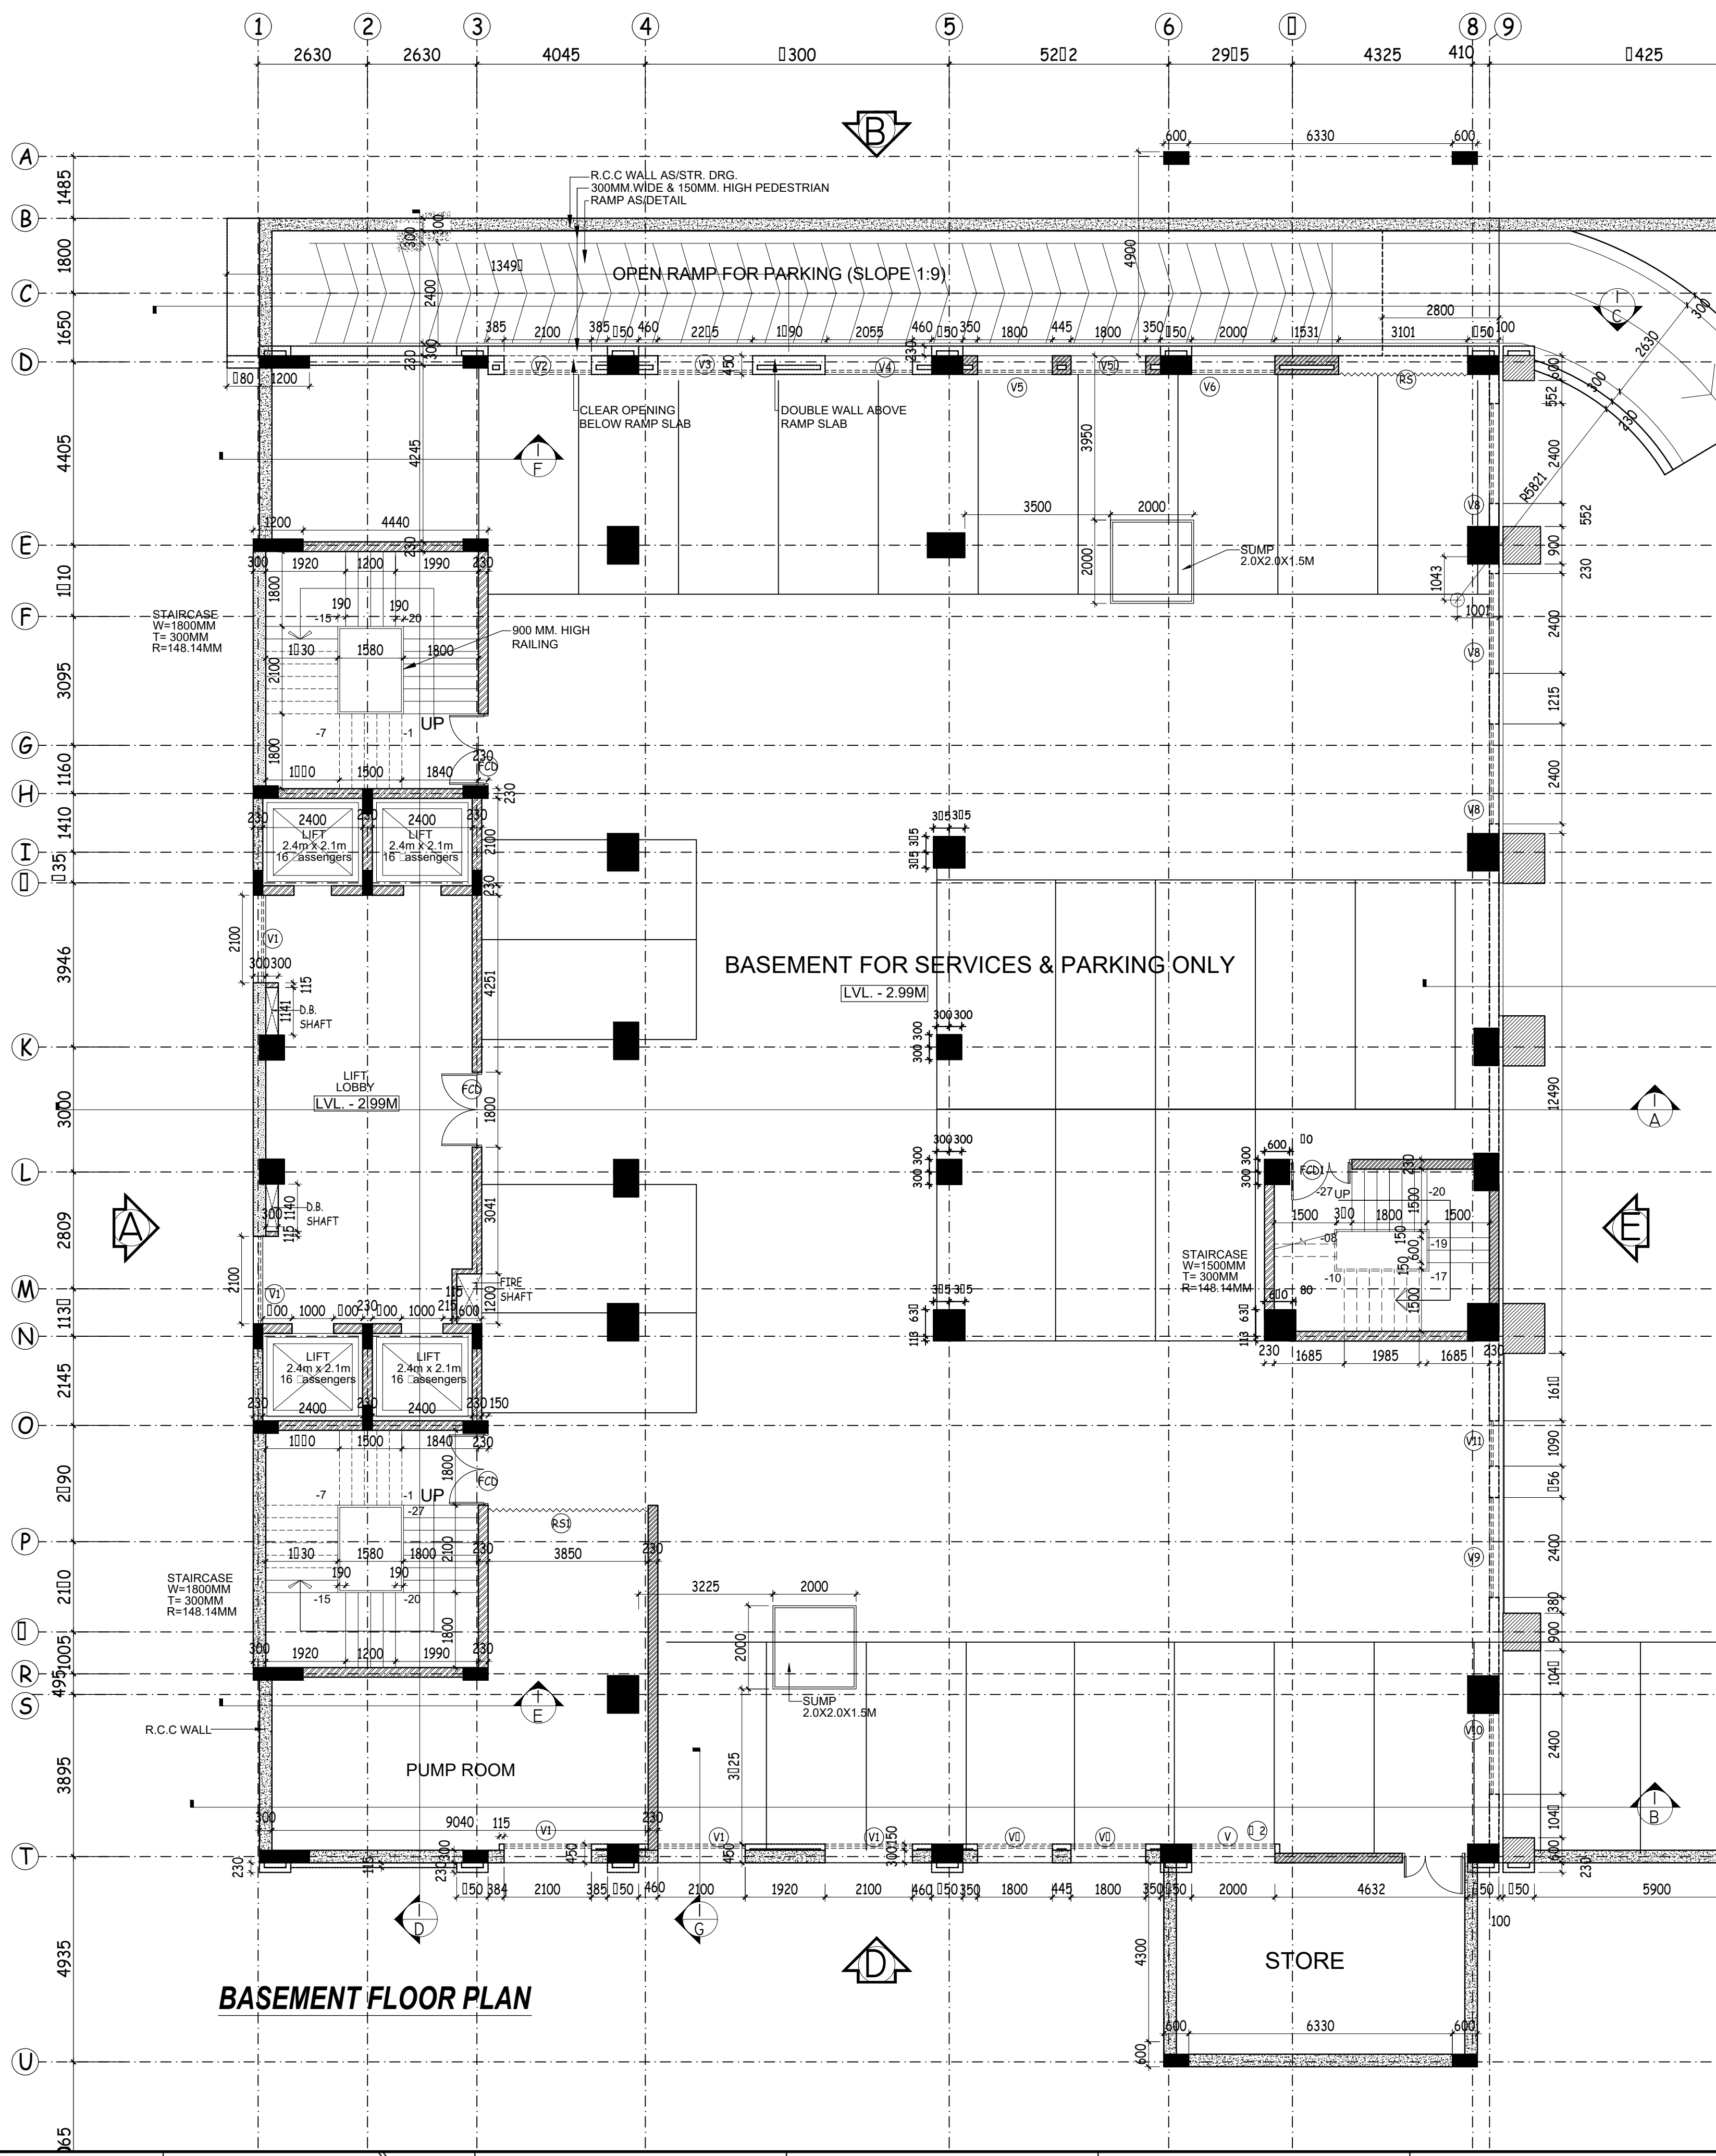


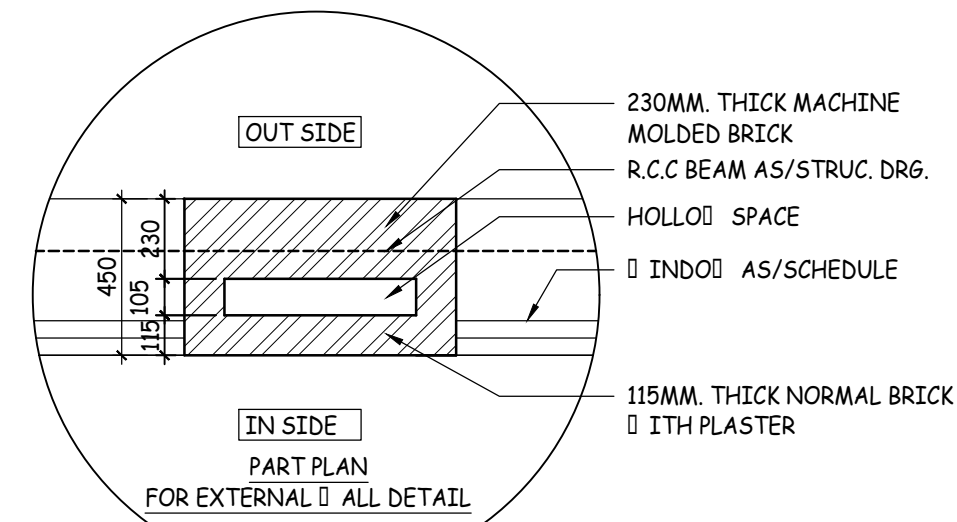

BASEMENT FLOOR PLAN

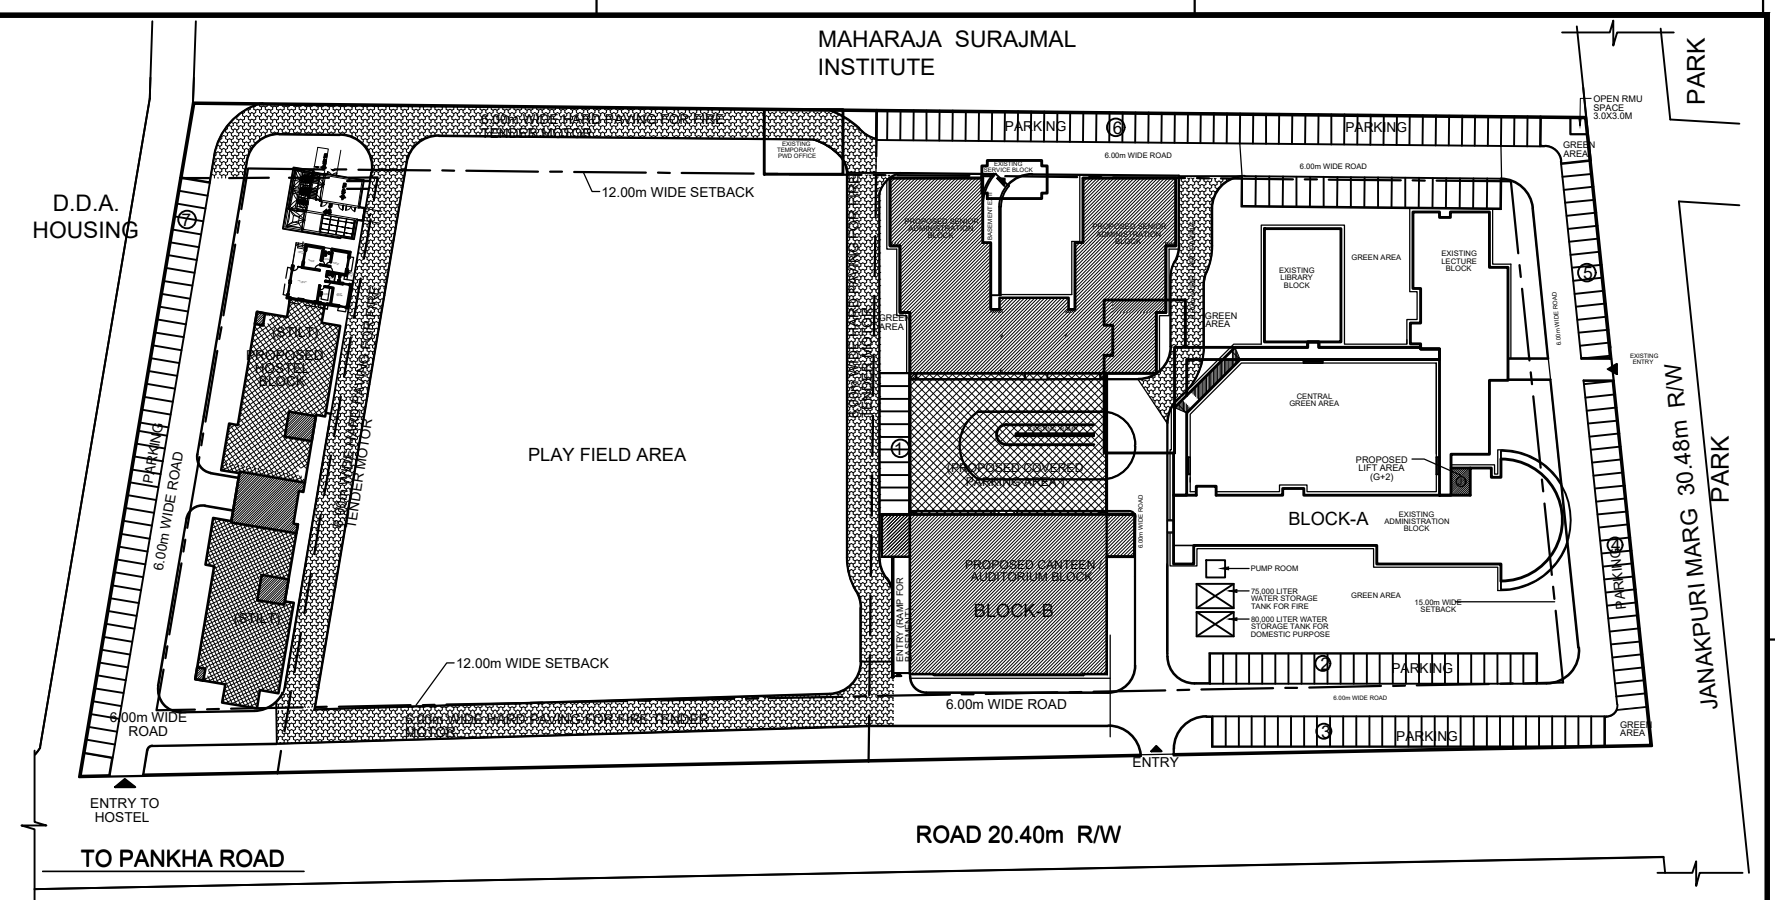

THIS DRAWING IS THE PROPERTY & COPYRIGHT OF M/S SPACE ACE & NO PART OF THIS DRAWING MAY BE USED OR REPRODUCED IN ANY MANNER, STORED IN A RETRIEVAL SYSTEM, OR TRANSMITTED IN ANY FORM OR BY ANY MEANS, ELECTRONIC, MECHANICAL, PHOTOCOPYING, RECORDING OR OTHERWISE, EXCEPT FOR THE RELATED PROJECT, WITHOUT THE WRITTEN PERMISSION OF M/S SPACE ACE

- NOTE :-
- DO NOT SCALE THE DRAWING, FOLLOW WRITTEN DIMENSION ONLY.
 - ALL DIMENSIONS IN MM. AND LEVELS IN METERS.
 - 750 WIDE PLINTH PROTECTION TO BE PROVIDED ALL AROUND THE BUILDING.
 - SKIRTING SHALL BE 100MM. HIGH FROM FINISHED FLOOR LEVEL.
 - TOILET, PANTRY, KITCHEN VERANDAH & BALCONY FLOOR LEVEL SHALL BE 12 MM. DOWN FROM GENERAL FLOOR LEVEL.
 - CUPBOARDS SHALL HAVE SKIRTING OF 100 MM. HIGH.
 - LOCATION, SIZES & LEVELS OF MANHOLES TO BE CO-ORDINATED WITH EXTERNAL SEWERAGE LAY OUT PLAN GOT APPROVED BY ENGG. INCHARGE.
 - ALL MEASUREMENT MUST BE CHECKED AT SITE BY CONTRACTOR.

SANITARY LEGEND

W.P.	100MM DIA. WASTE PIPE
R.W.P.	100MM DIA. RAIN WATER PIPE
R.V.P.	100MM DIA. SOIL VENT PIPE
F.T.	FLOOR TRAP (100x100) MM
F.D.	FLOOR DRAIN (100x75) MM
F.C.O.	FLOOR CLEAN OUT
G.T.	GULLY TRAP (300x300)mm
M.H.	SEWER MANHOLE (600x600)mm
ORISSA PAN (W.C)	ORISSA PAN (W.C)
WC	EUROPEAN PAN (W.C)
100/75MM DIA. WASTE PIPE	100/75MM DIA. WASTE PIPE
100MM DIA. SOIL PIPE	100MM DIA. SOIL PIPE

REVISIONS

CLIENT

**BHARATI COLLEGE,
C-4, JANAKPURI, NEW
DELHI-110058**

TITLE

**PART BASEMENT FLOOR PLAN
(AUDITORIUM BLOCK)**

DRAWN BY

- Ramprakash

DATE

- 24-12-2013

SCALE

- 1:100

DRG.NO.

- AUDI./B.F/01

JOB. NO.

- BC/02/13

CHECKED BY

- S.R.

**SPACE ACE
ARCHITECTS, ENGINEERS &
PLANNERS**



V-20A/5,
D.L.F. CITY III,
GURGAON, HARYANA - 122002
PH - 0124-4106618, FAX: 0124-2365329
E-MAIL : spaceace.india@gmail.com



DOOR & WINDOW SCHEDULE

S.NO.	SYMBOL	SIZE	SILL LVL.	LINTEL LVL.
DOOR				
1	D	740X2100	0	2100
2	D	750X2100	0	2100
3	D1	900X2400	0	2400
4	D2	1000X2400	0	2400
5	D3	1070X2400	0	2400
6	D4	1200X2400	0	2400
7	D5	1500X2400	0	2400
8	D6	1800X2400	0	2400
9	D7	2000X2400	0	2400
10	D8	1730X2100	0	2100
11	DW	2400X2400	0	2400
12	DV	2025X4300	0	4300
13	DV1	1730X4300	0	4300
14	DV2	2380X3400	0	3400
15	DV3	2400X3400	0	3400
FIRE DOOR				
1	FCD	1730X2400	0	2400
2	FCD1	1500X2400	0	2400

WINDOW				
1	W	600X10500	900	11400
2	W	600X2500	900	3400
3	W1	1800X1500	900	2400
4	W1	843+843x1500	900	2400
5	W2	2000X1500	900	2400
6	W2	492+1393x1500	900	2400
7	W3	2100X1500	900	2400
8	W3	1168+817x1500	900	2400
9	W4	2400X1500	900	2400
10	W5	2290X1500	900	3400
11	W6	1300X2250	150	2400
12	W7	1450X2250	150	2400
13	W8	2030X2250	150	3400
14	W9	1730X4300	150	4450
15	W10	2000X1500	900	2400
16	W11	1730X13350	900	14250

VENTILATOR				
1	V	400X400	2630	3030
2	V	2000X750	3100	3850
3	V1	2100X750	3100	3850
4	V2	2100X900	2500	3400
5	V3	2100X1320	2080	3400
6	V4	2100X1720	1680	3400
7	V5	1800X2120	1280	3400
8	V5	1800X2120	1280	3400
9	V6	2000X2480	920	3400
10	V7	1800X750	3100	3850
11	V8	2100X300	3100	3400
12	V9	2290X300	3100	3400
13	V10	2400X300	3100	3400
14	V11	1090X300	3100	3400

ROLLING SHUTTER				
1	RS	3100X3400	0	3400
2	RS1	4000X2700	0	2700

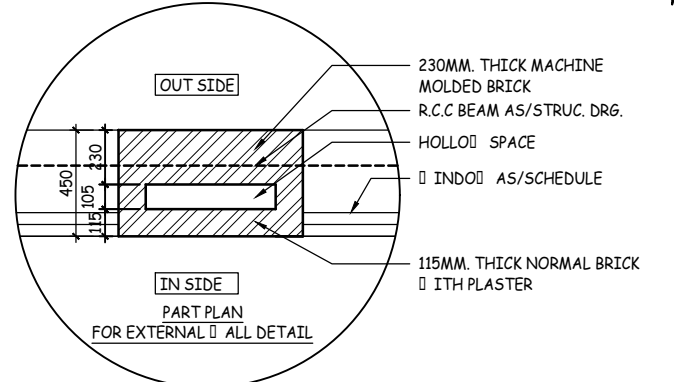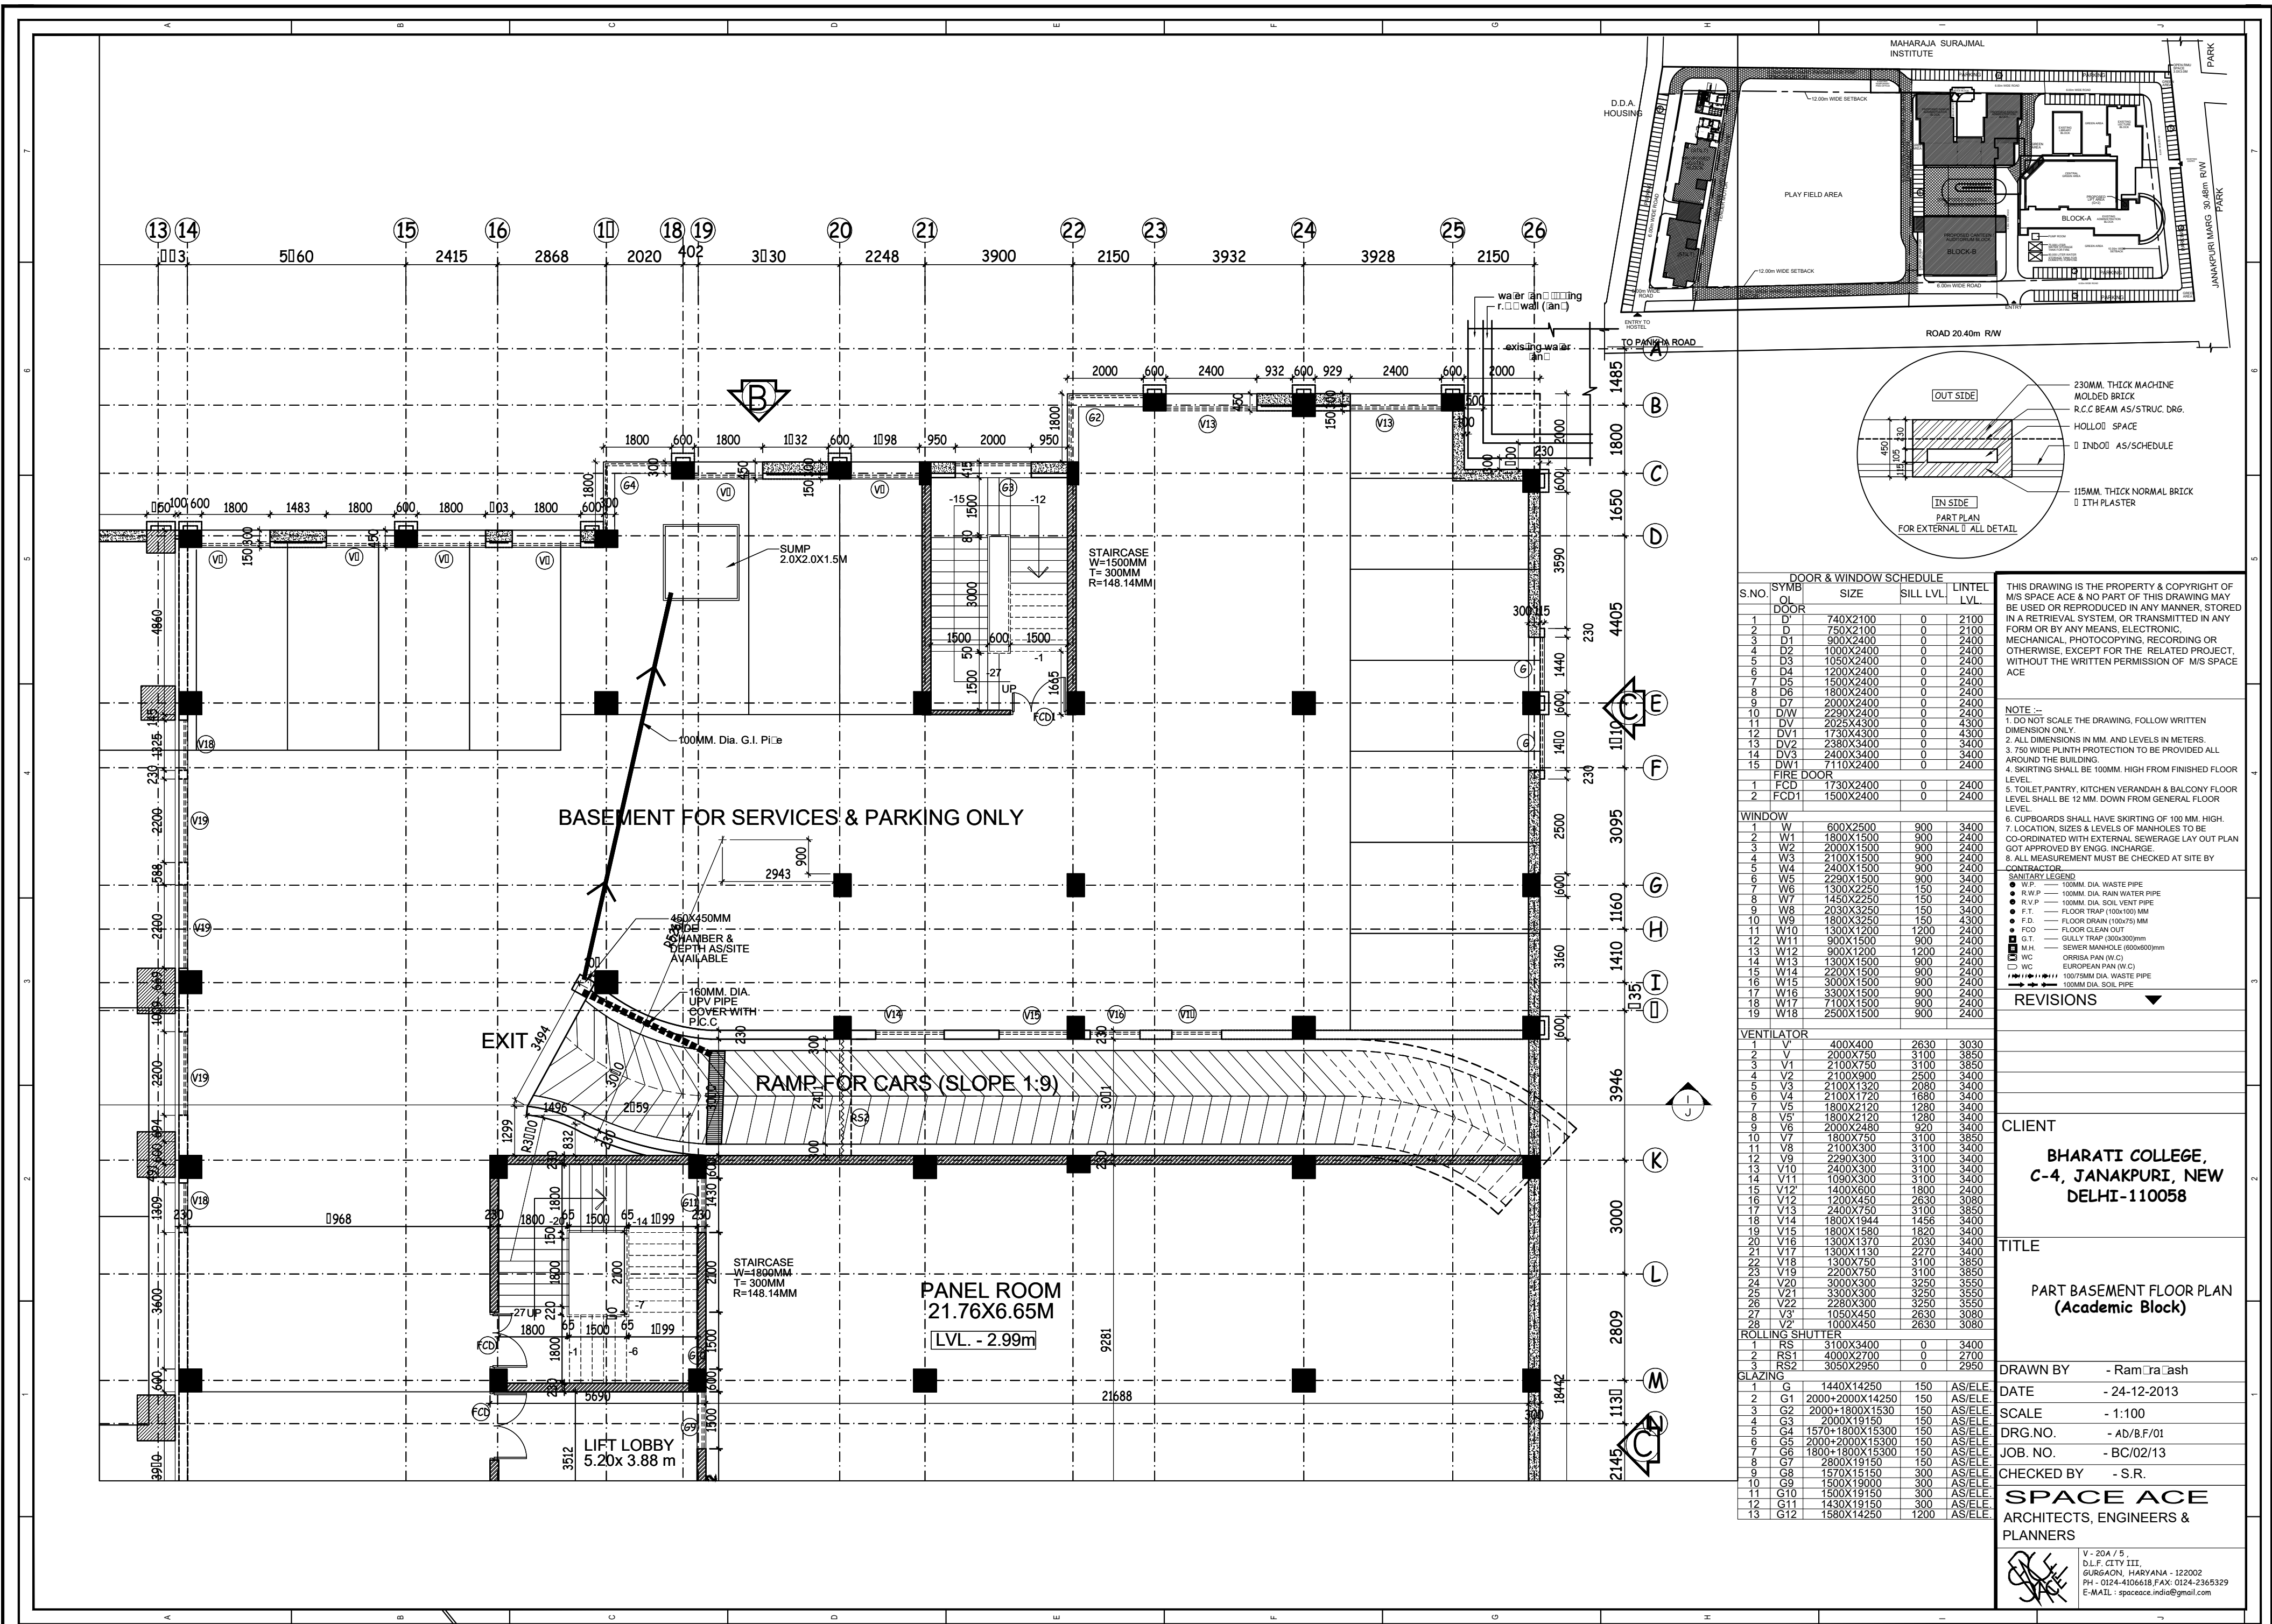

DOOR & WINDOW SCHEDULE				
S.NO.	SYMBOL	SIZE	SILL LVL.	LINTEL LVL.
1	D1	740X2100	0	2100
2	D2	750X2100	0	2100
3	D3	900X2400	0	2400
4	D4	1050X2400	0	2400
5	D5	1200X2400	0	2400
6	D6	1500X2400	0	2400
7	D7	1800X2400	0	2400
8	D8	2000X2400	0	2400
9	D9	2290X2400	0	2400
10	D10	2290X2400	0	2400
11	D11	2025X4300	0	4300
12	D12	1730X4300	0	4300
13	D13	2380X3400	0	3400
14	D14	2400X3400	0	3400
15	D15	7110X2400	0	2400
16	D16	1730X2400	0	2400
17	D17	1500X2400	0	2400

WINDOW			
S.NO.	SYMBOL	SIZE	LVL.
1	W1	600X2500	900
2	W2	1800X1500	900
3	W3	2000X1500	900
4	W4	2400X1500	900
5	W5	2290X1500	900
6	W6	1300X2250	150
7	W7	1450X2250	150
8	W8	2030X3250	150
9	W9	1800X3250	150
10	W10	1300X1200	1200
11	W11	900X1500	900
12	W12	900X1200	1200
13	W13	1300X1500	900
14	W14	2200X1500	900
15	W15	3000X1500	900
16	W16	3300X1500	900
17	W17	7100X1500	900
18	W18	2500X1500	900

VENTILATOR			
S.NO.	SYMBOL	SIZE	LVL.
1	V1	400X400	2630
2	V2	2100X750	3100
3	V3	2100X900	2500
4	V4	2100X1320	2080
5	V5	2100X1720	1680
6	V6	1800X2120	1280
7	V7	1800X1420	1280
8	V8	2000X2480	920
9	V9	1800X750	3100
10	V10	2100X300	3100
11	V11	2100X300	3100
12	V12	1400X600	1800
13	V13	1200X450	2630
14	V14	2400X750	3100
15	V15	1800X1440	1456
16	V16	1800X1580	1820
17	V17	1300X1370	2030
18	V18	1300X1130	2270
19	V19	1300X750	3100
20	V20	2200X750	3100
21	V21	3000X300	3250
22	V22	3300X300	3250
23	V23	2280X300	3250
24	V24	1050X450	2630
25	V25	1000X450	2630

ROLLING SHUTTER			
S.NO.	SYMBOL	SIZE	LVL.
1	RS1	3100X3400	0
2	RS2	4000X2700	0
3	RS3	3050X2950	0

GLAZING			
S.NO.	SYMBOL	SIZE	LVL.
1	G1	1440X14250	150
2	G2	2000+2000X14250	150
3	G3	2000+1800X15300	150
4	G4	2000X19150	150
5	G5	1570+1800X15300	150
6	G6	2000X2000X15300	150
7	G7	1800+1800X15300	150
8	G8	2800X19150	150
9	G9	1570X15150	300
10	G10	1500X19150	300
11	G11	1430X19150	300
12	G12	1580X14250	1200

THIS DRAWING IS THE PROPERTY & COPYRIGHT OF M/S SPACE ACE & NO PART OF THIS DRAWING MAY BE USED OR REPRODUCED IN ANY MANNER, STORED IN A RETRIEVAL SYSTEM, OR TRANSMITTED IN ANY FORM OR BY ANY MEANS, ELECTRONIC, MECHANICAL, PHOTOCOPYING, RECORDING OR OTHERWISE, EXCEPT FOR THE RELATED PROJECT, WITHOUT THE WRITTEN PERMISSION OF M/S SPACE ACE

NOTE :-
1. DO NOT SCALE THE DRAWING, FOLLOW WRITTEN DIMENSION ONLY.
2. ALL DIMENSIONS IN MM. AND LEVELS IN METERS.
3. 750 WIDE PLINTH PROTECTION TO BE PROVIDED ALL AROUND THE BUILDING.
4. SKIRTING SHALL BE 100MM. HIGH FROM FINISHED FLOOR LEVEL.
5. TOILET, PANTRY, KITCHEN VERANDAH & BALCONY FLOOR LEVEL SHALL BE 12 MM. DOWN FROM GENERAL FLOOR LEVEL.
6. CUPBOARDS SHALL HAVE SKIRTING OF 100 MM. HIGH.
7. LOCATION, SIZES & LEVELS OF MANHOLES TO BE CO-ORDINATED WITH EXTERNAL SEWERAGE LAY OUT PLAN GOT APPROVED BY ENGG. INCHARGE.
8. ALL MEASUREMENT MUST BE CHECKED AT SITE BY CONTRACTOR.

SANITARY LEGEND
● W.P. 100MM DIA. WASTE PIPE
● R.W.P. 100MM DIA. RAIN WATER PIPE
● R.V.P. 100MM DIA. SOIL VENT PIPE
● F.T. FLOOR TRAP (100/100) MM
● F.D. FLOOR DRAIN (100/75) MM
● F.C.O. FLOOR CLEAN OUT
● G.T. GULLY TRAP (300x300)mm
● M.H. SEWER MANHOLE (600x600)mm
● WC ORISSA PAN (W.C)
● WC EUROPEAN PAN (W.C)
● 100/75MM DIA. WASTE PIPE
● 100MM DIA. SOIL PIPE

REVISIONS


CLIENT
**BHARATI COLLEGE,
C-4, JANAKPURI, NEW
DELHI-110058**

TITLE
**PART BASEMENT FLOOR PLAN
(Academic Block)**

DRAWN BY - Ramkrishna
DATE - 24-12-2013
SCALE - 1:100
DRG. NO. - AB/B.F/01
JOB. NO. - BC/02/13
CHECKED BY - S.R.

SPACE ACE
ARCHITECTS, ENGINEERS & PLANNERS

V - 20A / 5
D.L.F. CITY III,
GURGAON, HARYANA - 122002
PH - 0124-410618, FAX: 0124-2365329
E-MAIL : spaceace.india@gmail.com

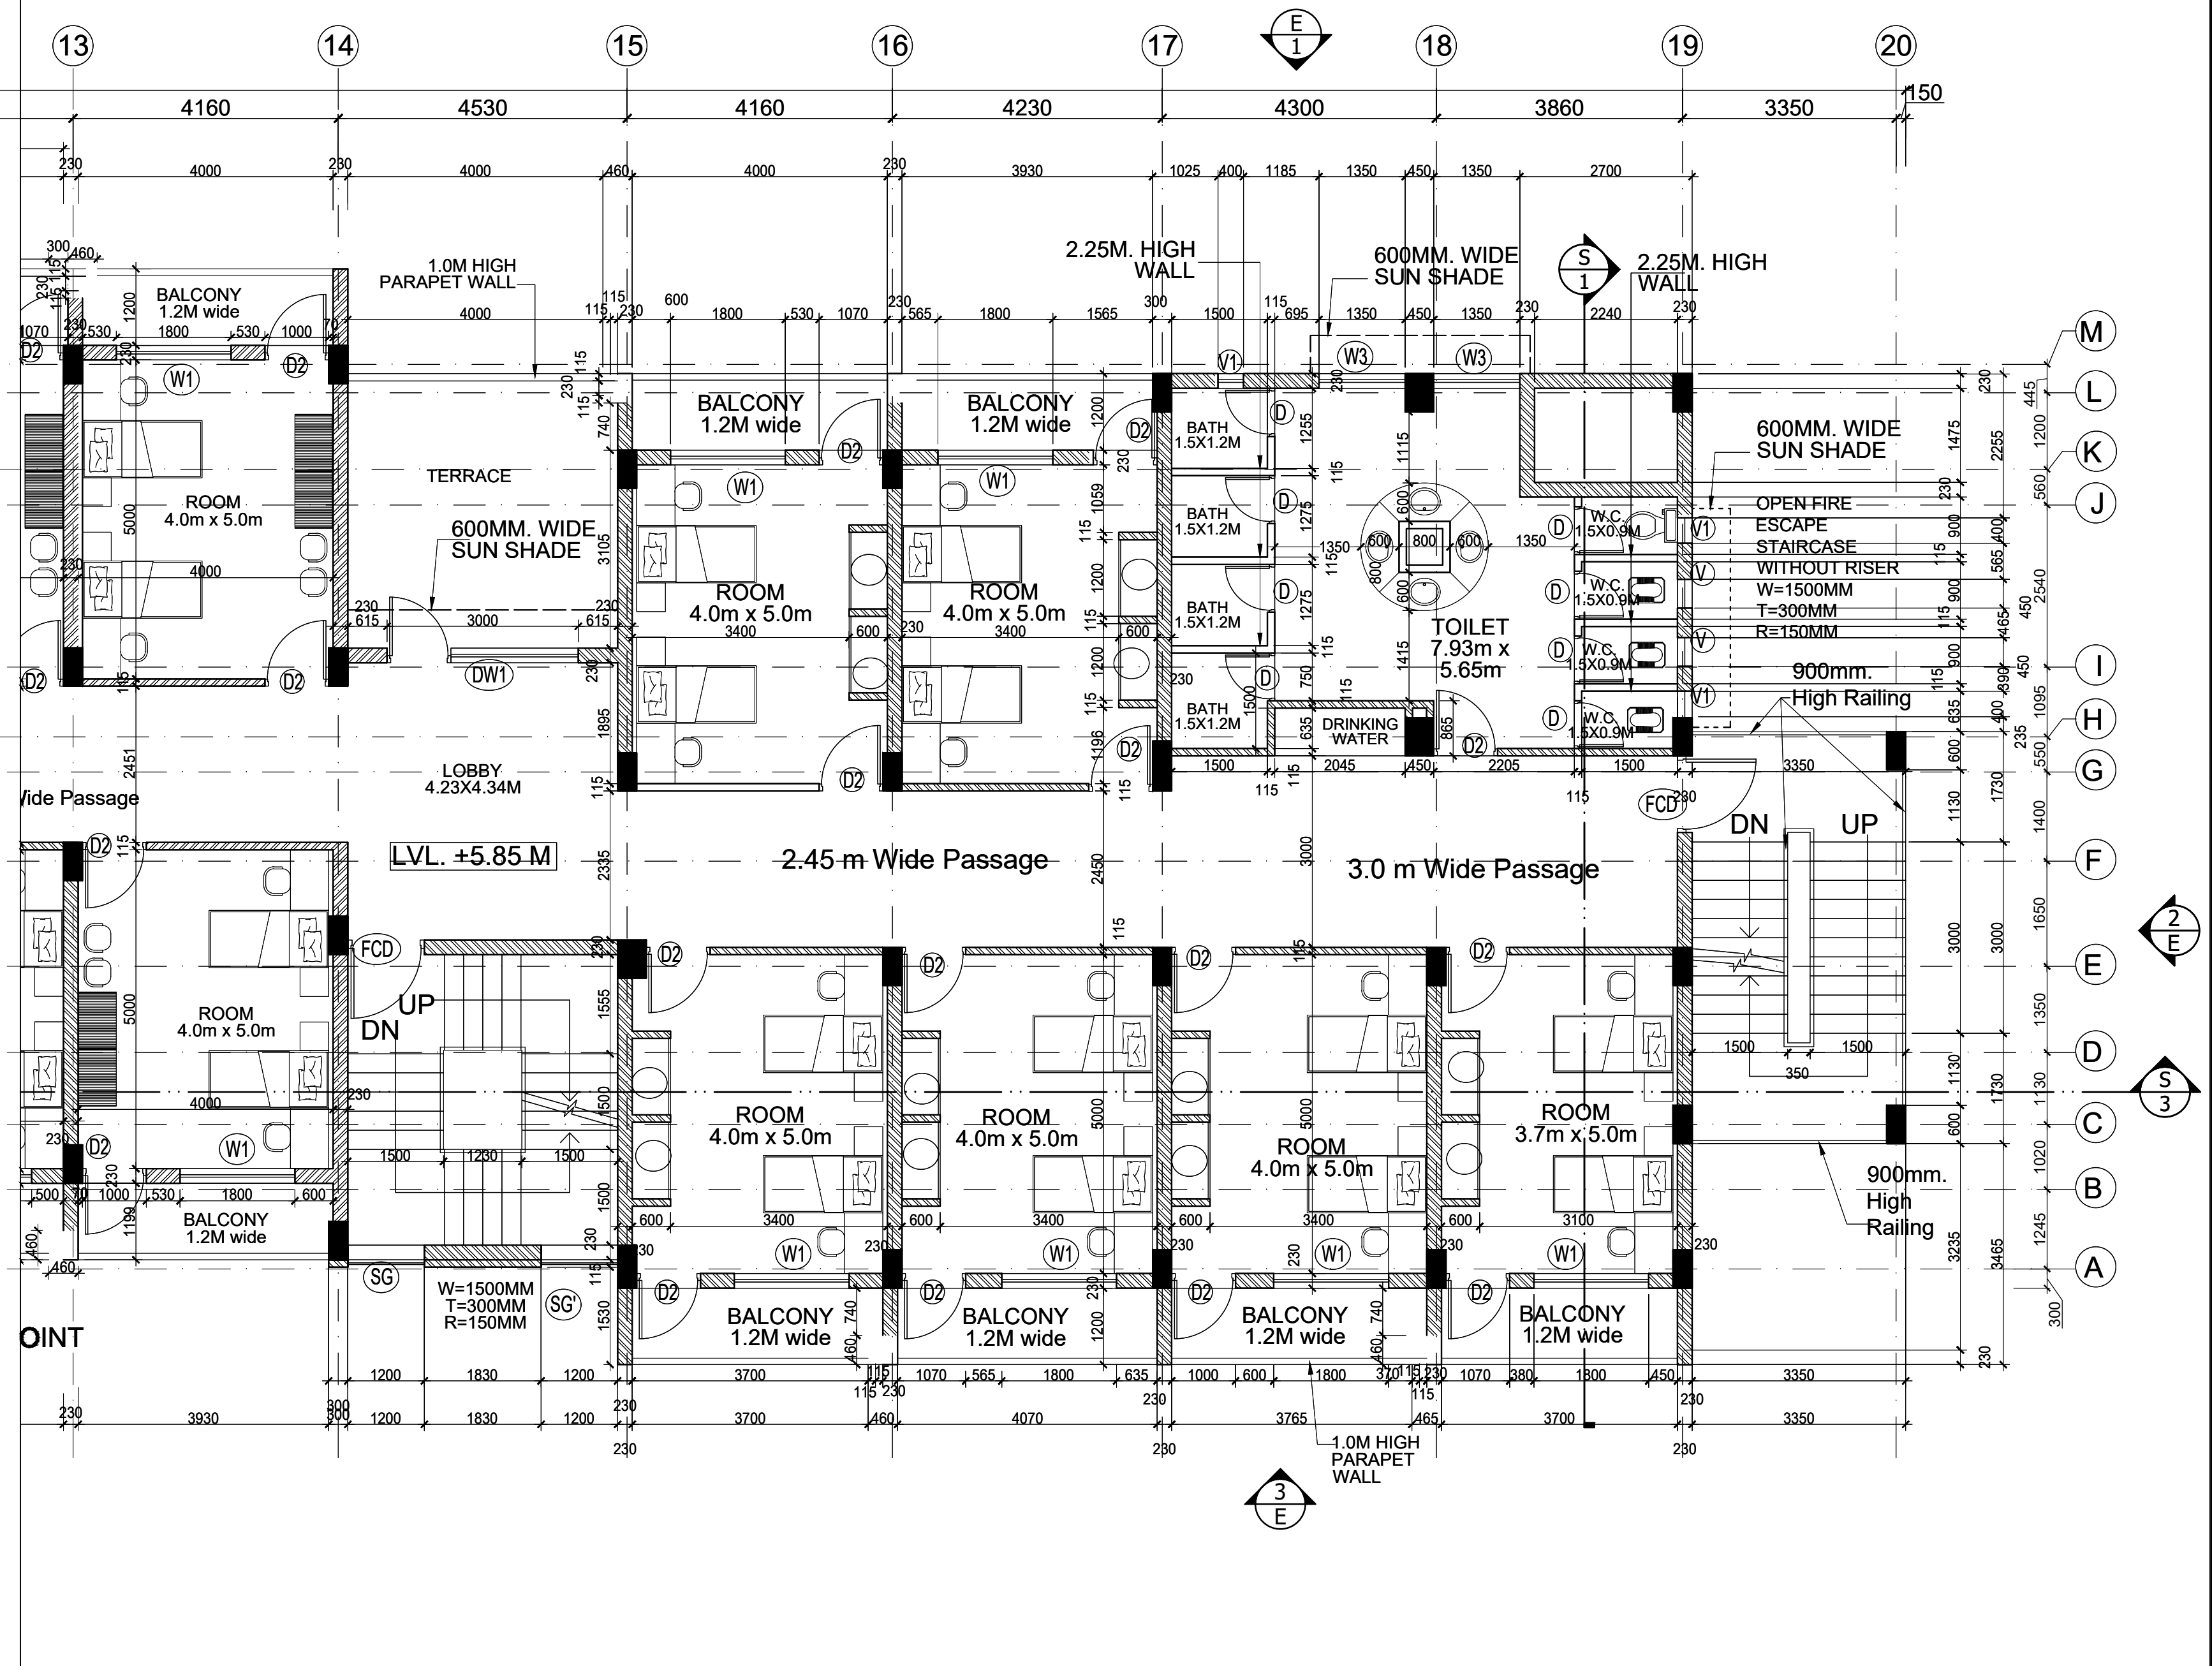

SCHEDULE OF DOORS & WINDOWS				
S.NO.	SYMBOL	SIZE	SILL LVL.	LINTEL LVL.
DOORS				
1	D	750X2100	0	2100
2	D'	750X2000	0	2000
3	D1	900X2400	0	2400
4	D2	1000X2400	0	2400
5	D3	1000X2400	0	2400
6	D4	1800X2400	0	2400
7	D4'	1800X2000	0	2000
8	D5	1500X2400	0	2400
9	DE	2400X2000	0	2000
10	DE1	2400X2400	0	2400
FIRE DOOR				
1	FCD	1200X2400	0	2400
2	FCD'	1200X2000	0	2000
WINDOWS				
1	W	1800X2100	300	2400
2	W'	1800X1700	300	2000
3	W1	1800X1500	900	2400
4	W2	1500X1500	900	2400
5	W3	1350X1500	900	2400
6	W4	2700X1500	900	2400
DOOR-WINDOW				
1	DW1	3000X2400	900	2400
VENTILATOR				
1	V	450X900	1500	2400
2	V1	400X400	2000	2400

THIS DRAWING IS THE PROPERTY & COPYRIGHT OF M/S SPACE ACE & NO PART OF THIS DRAWING MAY BE USED OR REPRODUCED IN ANY MANNER, STORED IN A RETRIEVAL SYSTEM, OR TRANSMITTED IN ANY FORM OR BY ANY MEANS, ELECTRONIC, MECHANICAL, PHOTOCOPYING, RECORDING OR OTHERWISE, EXCEPT FOR THE RELATED PROJECT, WITHOUT THE WRITTEN PERMISSION OF M/S SPACE ACE

SANITARY LEGEND	
100 DIA. WASTE PIPE (W.P.)	100 DIA. RAIN WATER PIPE (R.W.P.)
100 DIA. SOIL PIPE/SOIL VENT PIPE (S.V.P.)	300X300 GULLY TRAP
M.H. MAN HOLE	WASTE PIPE 100 DIA.
SOIL PIPE 100 DIA.	ORRISA PAN (W.C.)
EUROPEAN W.C. PAN	

NOTE :-
1. DO NOT SCALE THE DRAWING, FOLLOW WRITTEN DIMENSION ONLY.
2. ALL DIMENSIONS IN MM. AND LEVELS IN METERS.
3. 750 WIDE PLINTH PROTECTION TO BE PROVIDED ALL AROUND THE BUILDING.
4. SKIRTING SHALL BE 100MM. HIGH FROM FINISHED FLOOR LEVEL.
5. TOILET PANTRY, KITCHEN VERANDAH & BALCONY FLOOR LEVEL SHALL BE 12 MM. DOWN FROM GENERAL FLOOR LEVEL.
6. CUPBOARDS SHALL HAVE SKIRTING OF 100 MM. HIGH.
7. LOCATION, SIZES & LEVELS OF MANHOLES TO BE CO-ORDINATED WITH EXTERNAL SEWERAGE LAY OUT PLAN GOT APPROVED BY ENGG. INCHARGE.
8. ALL MEASUREMENT MUST BE CHECKED AT SITE BY CONTRACTOR.

REVISIONS	
R1	12-02-2014
R2	20-02-2014

DRAWN BY	- RUBY
DATE	- 29-08-2013
SCALE	- 1:50
DRG.NO.	- 6H/F.F/03
JOB. NO.	- BH.C/JNK/13
CHECKED BY	- RAMPRAKASH



TITLE	PART FIRST FLOOR PLAN GIRLS HOSTEL BLOCK
-------	---

CLIENT	BHARATI COLLEGE
--------	-----------------

SPACE ACE ARCHITECTS, ENGINEERS & PLANNERS	V- 20A / 5, D.L.F. CITY III, GURGAON, HARYANA - 122002 PH- 0124-410618, FAX: 0124-2365329 E-MAIL: spaceace.india@gmail.com
---	--

PHASE-A

PHASE-A

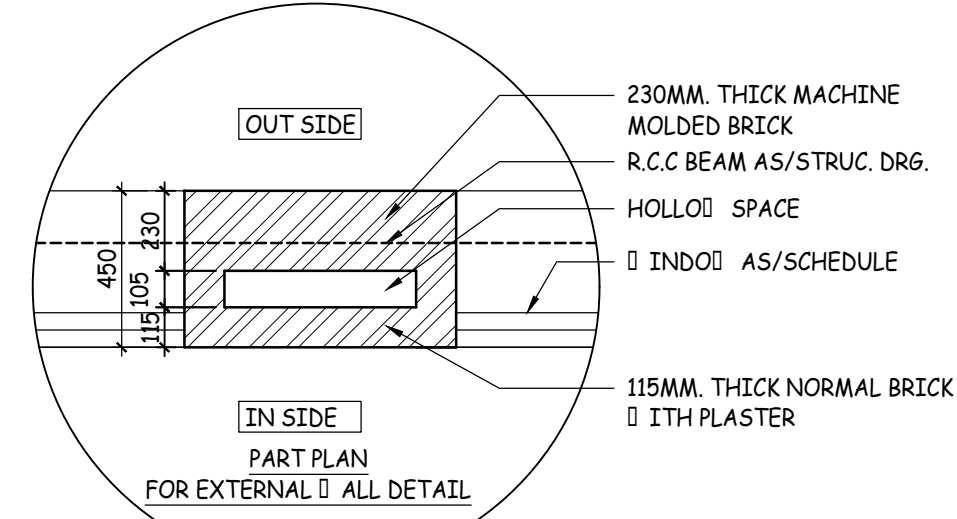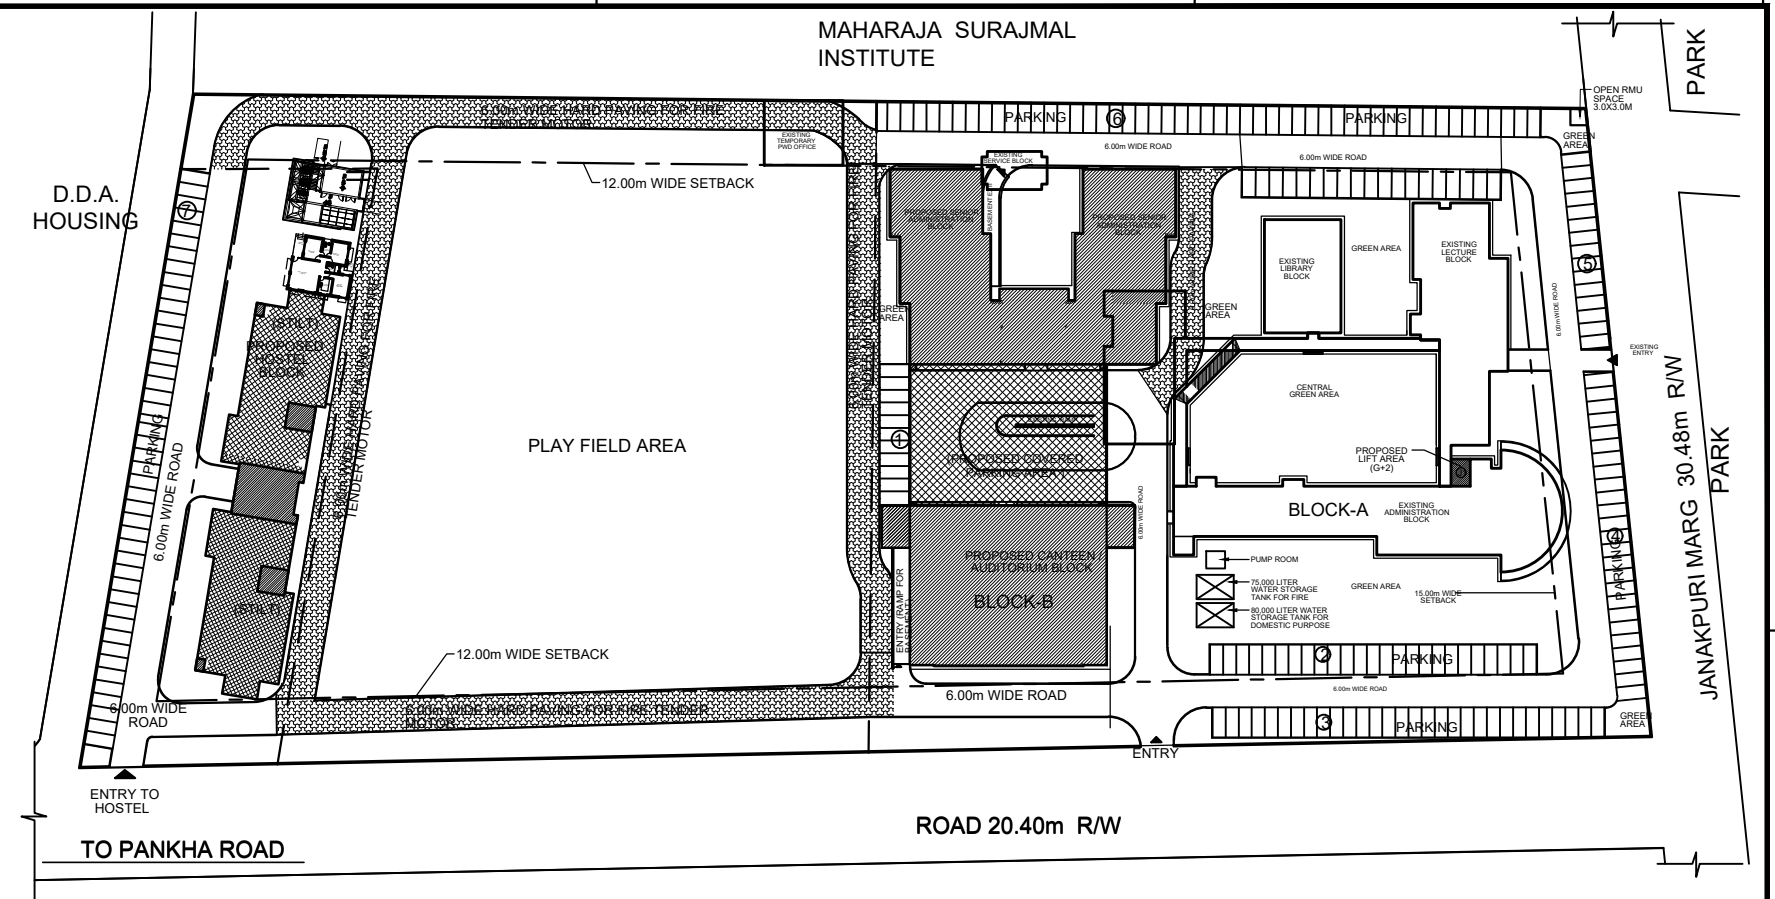

THIS DRAWING IS THE PROPERTY & COPYRIGHT OF M/S SPACE ACE & NO PART OF THIS DRAWING MAY BE USED OR REPRODUCED IN ANY MANNER, STORED IN A RETRIEVAL SYSTEM, OR TRANSMITTED IN ANY FORM OR BY ANY MEANS, ELECTRONIC, MECHANICAL, PHOTOCOPYING, RECORDING OR OTHERWISE, EXCEPT FOR THE RELATED PROJECT, WITHOUT THE WRITTEN PERMISSION OF M/S SPACE ACE

- NOTE :-
- DO NOT SCALE THE DRAWING, FOLLOW WRITTEN DIMENSION ONLY.
 - ALL DIMENSIONS IN MM. AND LEVELS IN METERS.
 - 750 WIDE PLINTH PROTECTION TO BE PROVIDED ALL AROUND THE BUILDING.
 - SKIRTING SHALL BE 100MM. HIGH FROM FINISHED FLOOR LEVEL.
 - TOILET, PANTRY, KITCHEN VERANDAH & BALCONY FLOOR LEVEL SHALL BE 12 MM. DOWN FROM GENERAL FLOOR LEVEL.
 - CUPBOARDS SHALL HAVE SKIRTING OF 100 MM. HIGH.
 - LOCATION, SIZES & LEVELS OF MANHOLES TO BE CO-ORDINATED WITH EXTERNAL SEWERAGE LAY OUT PLAN GOT APPROVED BY ENGG. INCHARGE.
 - ALL MEASUREMENT MUST BE CHECKED AT SITE BY CONTRACTOR.

SANITARY LEGEND

● W.P.	100MM DIA. WASTE PIPE
● R.W.P.	100MM DIA. RAIN WATER PIPE
● R.V.P.	100MM DIA. SOIL VENT PIPE
● F.T.	FLOOR TRAP (100x100) MM
● F.D.	FLOOR DRAIN (100x75) MM
● F.C.O.	FLOOR CLEAN OUT
● G.T.	GULLY TRAP (300x300)mm
● M.H.	SEWER MANHOLE (600x600)mm
● W.C.	ORISSA PAN (W.C)
● W.C.	EUROPEAN PAN (W.C)
●	100/75MM DIA. WASTE PIPE
●	100MM DIA. SOIL PIPE

REVISIONS

CLIENT

**BHARATI COLLEGE,
C-4, JANAKPURI, NEW
DELHI-110058**

TITLE

**PART GROUND FLOOR PLAN
(AUDITORIUM BLOCK)**

DRAWN BY - Ramraash

DATE - 24-12-2013

SCALE - 1:100

DRG.NO. - AUDI./G.F/02

JOB. NO. - BC/02/13

CHECKED BY - S.R.

**SPACE ACE
ARCHITECTS, ENGINEERS &
PLANNERS**

V-20A/5,
D.L.F. CITY III,
GURGAON, HARYANA - 122002
PH - 0124-4106618, FAX: 0124-2365329
E-MAIL : spaceace.india@gmail.com

DOOR & WINDOW SCHEDULE

S.NO.	SYMBOL	SIZE	SILL LVL.	LINTEL LVL.
DOOR				
1	D	740X2100	0	2100
2	D	750X2100	0	2100
3	D1	900X2400	0	2400
4	D2	1000X2400	0	2400
5	D3	1070X2400	0	2400
6	D4	1200X2400	0	2400
7	D5	1500X2400	0	2400
8	D6	1800X2400	0	2400
9	D7	2000X2400	0	2400
10	D8	2000X2400	0	2400
11	D9	2000X2400	0	2400
12	D10	2000X2400	0	2400
13	D11	2000X2400	0	2400
14	D12	2000X2400	0	2400
FIRE DOOR				
1	FCD	1730X2400	0	2400
2	FCD1	1500X2400	0	2400

WINDOW




S.NO.	SYMBOL	SIZE	SILL LVL.	LINTEL LVL.
1	W	600X10500	900	11400
2	W1	1800X1500	900	2400
3	W1'	843+843X1500	900	2400
4	W2	2000X1500	900	2400
5	W2'	492+1393X1500	900	2400
6	W3	2100X1500	900	2400
7	W3'	1168+817X1500	900	2400
8	W4	2400X1500	900	2400
9	W5	2290X1500	900	2400
10	W6	1300X2250	150	2400
11	W7	1450X2250	150	2400
12	W8	2030X2250	150	2400
13	W9	1730X4300	150	4450
14	W10	2000X1500	900	2400
15	W11	1730X13350	900	14250

VENTILATOR


S.NO.	SYMBOL	SIZE	SILL LVL.	LINTEL LVL.
1	V	400X400	2630	3030
2	V1	2000X750	3100	3850
3	V2	2100X750	3100	3850
4	V3	2100X900	2500	3400
5	V4	2100X1320	2080	3400
6	V5	2100X1720	1680	3400
7	V6	1800X2120	1280	3400
8	V7	1800X2120	1280	3400
9	V8	2000X2480	920	3400
10	V9	1800X750	3100	3850
11	V10	2100X300	3100	3400
12	V11	2290X300	3100	3400
13	V12	2400X300	3100	3400
14	V13	1090X300	3100	3400

ROLLING SHUTTER

S.NO.	SYMBOL	SIZE	SILL LVL.	LINTEL LVL.
1	RS	3100X3400	0	3400
2	RS1	4000X2700	0	2700

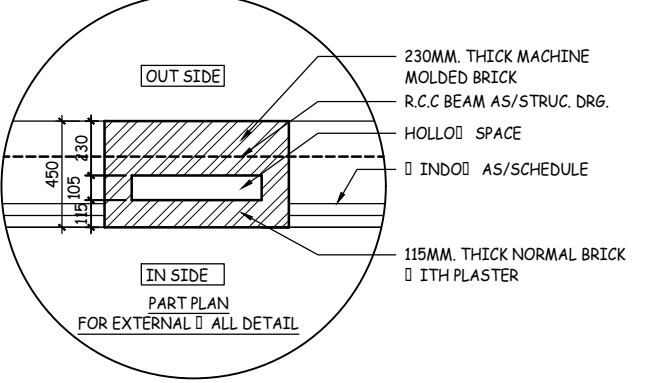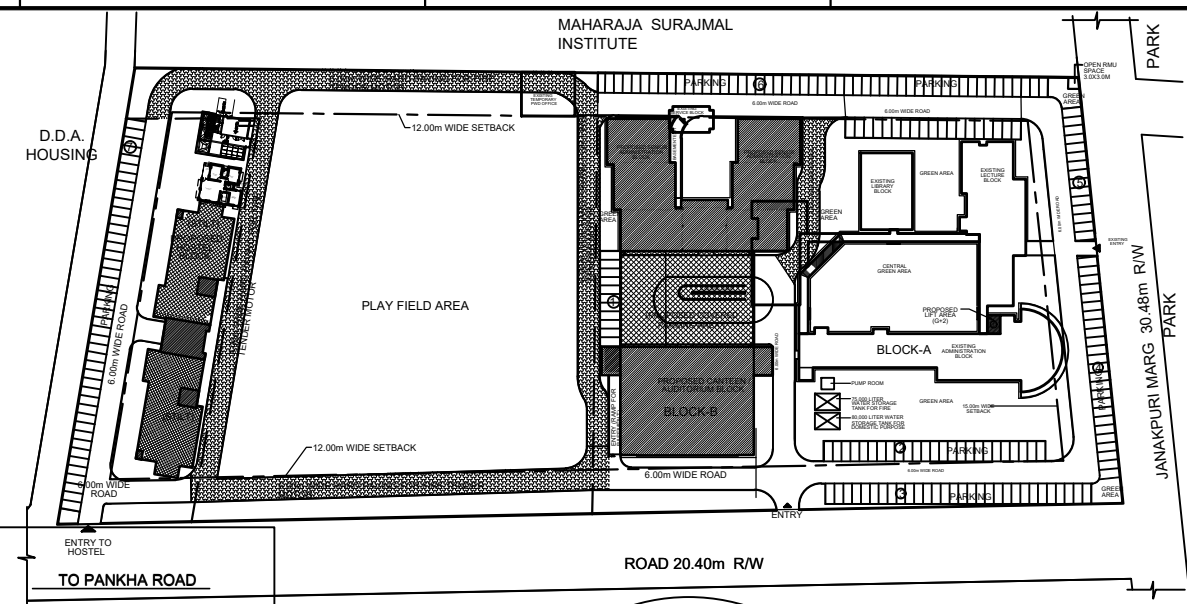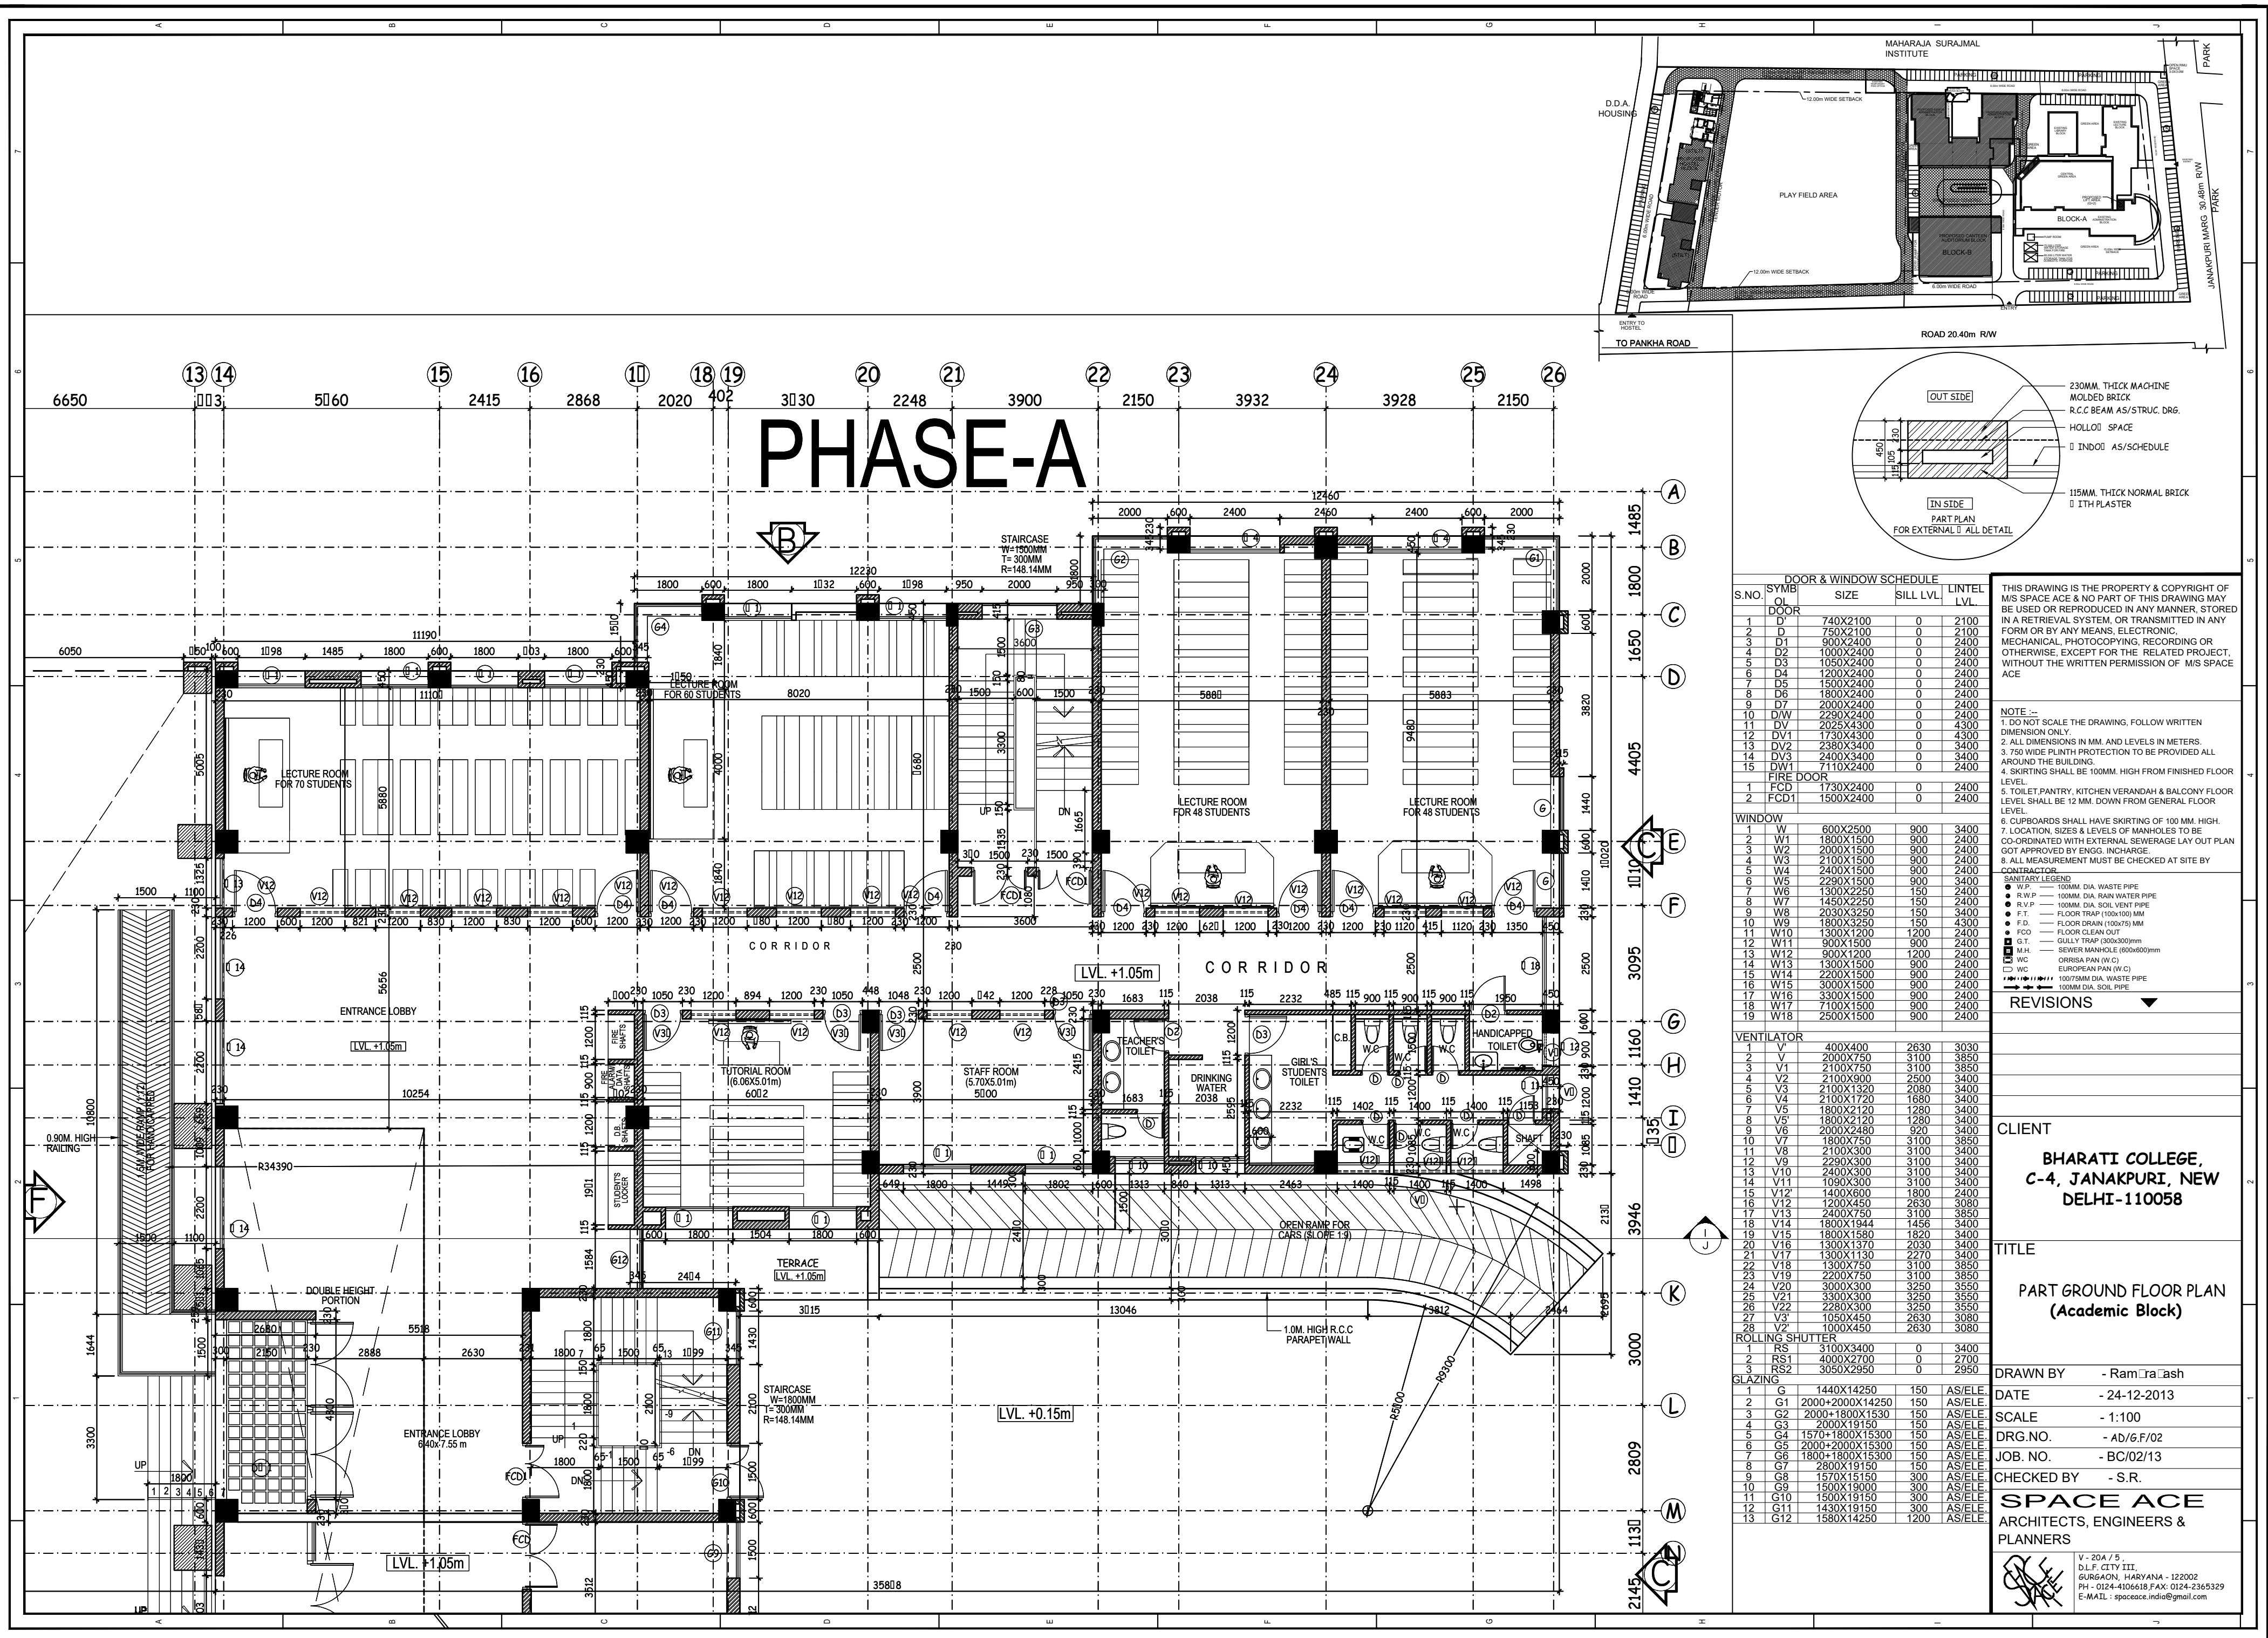

DOOR & WINDOW SCHEDULE				
S.NO.	SYMB OR DOOR	SIZE	SILL LVL	LINTEL LVL.
1	D	740X2100	0	2100
2	D	750X2100	0	2100
3	D1	900X2400	0	2400
4	D2	1000X2400	0	2400
5	D3	1050X2400	0	2400
6	D4	1200X2400	0	2400
7	D5	1500X2400	0	2400
8	D6	1800X2400	0	2400
9	D7	2000X2400	0	2400
10	D10	2250X2400	0	2400
11	DV	2250X4300	0	4300
12	DV1	1730X4300	0	4300
13	DV2	2380X4300	0	4300
14	DV3	3400X430	0	3400
15	DV1	7110X2400	0	2400
FIRE DOOR				
1	FGD	1730X2400	0	2400
2	FCD1	1500X2400	0	2400

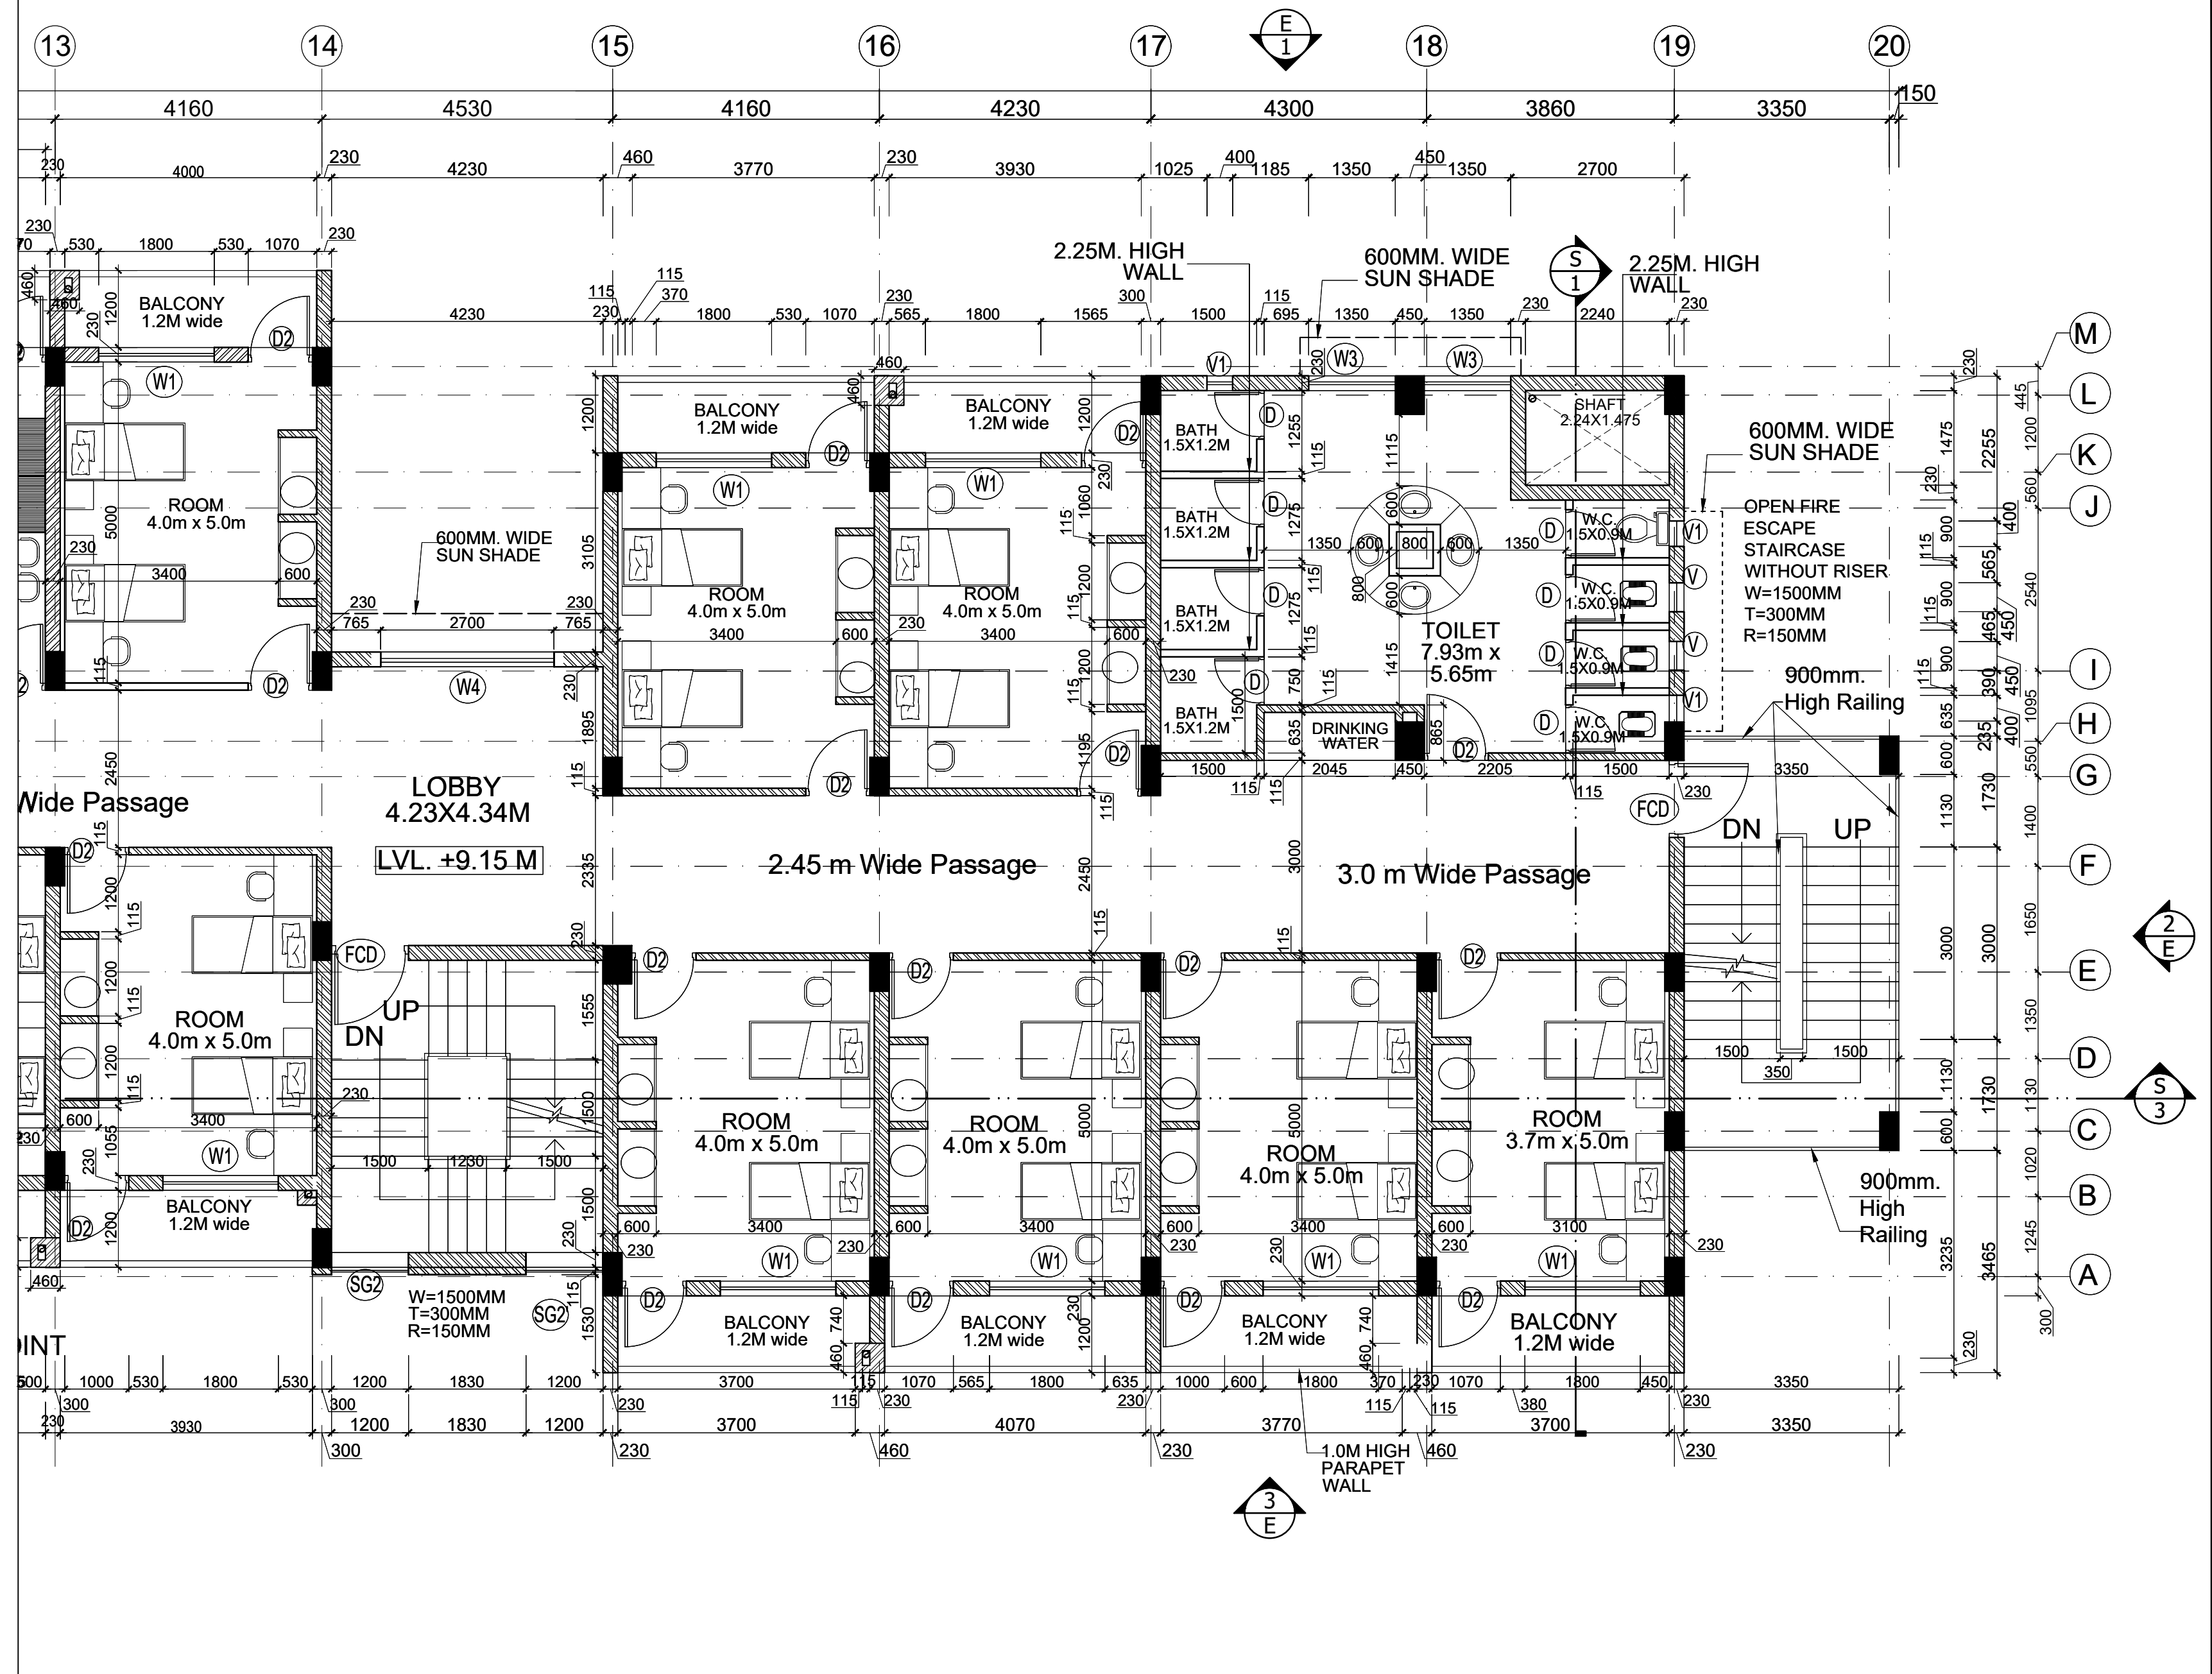

SCHEDULE OF DOORS & WINDOWS				
S.NO.	SYMBOL	SIZE	SILL LVL.	LINTEL LVL.
DOORS				
1	D	750X2100	0	2100
2	D'	750X2000	0	2000
3	D1	900X2400	0	2400
4	D2	1000X2400	0	2400
5	D3	1000X2400	0	2400
6	D4	1800X2400	0	2400
7	D4'	1800X2000	0	2000
8	D5	1500X2400	0	2400
9	DE	2400X2000	0	2000
10	DE1	2400X2400	0	2400
FIRE DOOR				
1	FCD	1200X2400	0	2400
2	FCD'	1200X2000	0	2000
WINDOWS				
1	W	1800X2100	300	2400
2	W'	1800X1700	300	2000
3	W1	1800X1500	900	2400
4	W2	1500X1500	900	2400
5	W3	1350X1500	900	2400
6	W4	2700X1500	900	2400
DOOR-WINDOW				
1	DW1	3000X2400	900	2400
VENTILATOR				
1	V	450X900	1500	2400
2	V1	400X400	2000	2400

THIS DRAWING IS THE PROPERTY & COPYRIGHT OF M/S SPACE ACE & NO PART OF THIS DRAWING MAY BE USED OR REPRODUCED IN ANY MANNER, STORED IN A RETRIEVAL SYSTEM, OR TRANSMITTED IN ANY FORM OR BY ANY MEANS, ELECTRONIC, MECHANICAL, PHOTOCOPYING, RECORDING OR OTHERWISE, EXCEPT FOR THE RELATED PROJECT, WITHOUT THE WRITTEN PERMISSION OF M/S SPACE ACE

SANITARY LEGEND

100 DIA. WASTE PIPE (W.P.)
100 DIA. RAIN WATER PIPE (R.W.P.)
100 DIA. SOIL PIPE/SOIL VENT PIPE (S.V.P.)
G.T. 300X300 GULLY TRAP
M.H. MAN HOLE
WASTE PIPE 100 DIA.
SOIL PIPE 100 DIA.
ORRISA PAN (W.C.)
EUROPEAN W.C. PAN

NOTE :-

1. DO NOT SCALE THE DRAWING, FOLLOW WRITTEN DIMENSION ONLY.
2. ALL DIMENSIONS IN MM. AND LEVELS IN METERS.
3. 750 WIDE PLINTH PROTECTION TO BE PROVIDED ALL AROUND THE BUILDING.
4. SKIRTING SHALL BE 100MM. HIGH FROM FINISHED FLOOR LEVEL.
5. TOILET PANTRY, KITCHEN VERANDAH & BALCONY FLOOR LEVEL SHALL BE 12 MM. DOWN FROM GENERAL FLOOR LEVEL.
6. CUPBOARDS SHALL HAVE SKIRTING OF 100 MM. HIGH.
7. LOCATION, SIZES & LEVELS OF MANHOLES TO BE CO-ORDINATED WITH EXTERNAL SEWERAGE LAY OUT PLAN GOT APPROVED BY ENGG. INCHARGE.
8. ALL MEASUREMENT MUST BE CHECKED AT SITE BY CONTRACTOR.

REVISIONS	
R1	12-02-2014
R2	20-02-2014

DRAWN BY	- RUBY
DATE	- 29-08-2013
SCALE	- 1:50
DRG.NO.	- 6H/S.F/04
JOB. NO.	- BH.C/JNK/13
CHECKED BY	- RAMPRAKASH

TITLE




PART SECOND FLOOR PLAN
GIRLS HOSTEL BLOCK

CLIENT

BHARATI COLLEGE

SPACE ACE
ARCHITECTS, ENGINEERS & PLANNERS

V - 20A / 5,
D.L.F. CITY III,
GURGAON, HARYANA - 122002
PH - 0124-410618, FAX: 0124-2365329
E-MAIL : spaceace.india@gmail.com

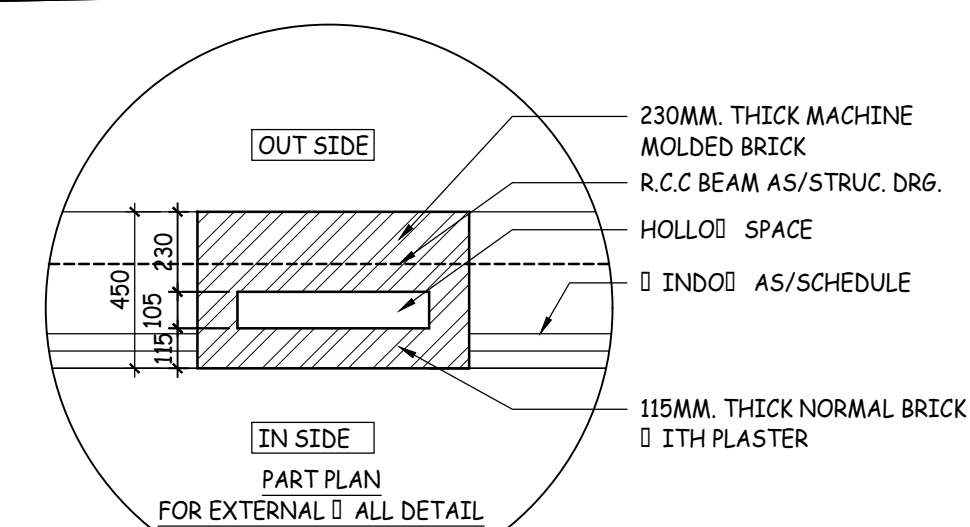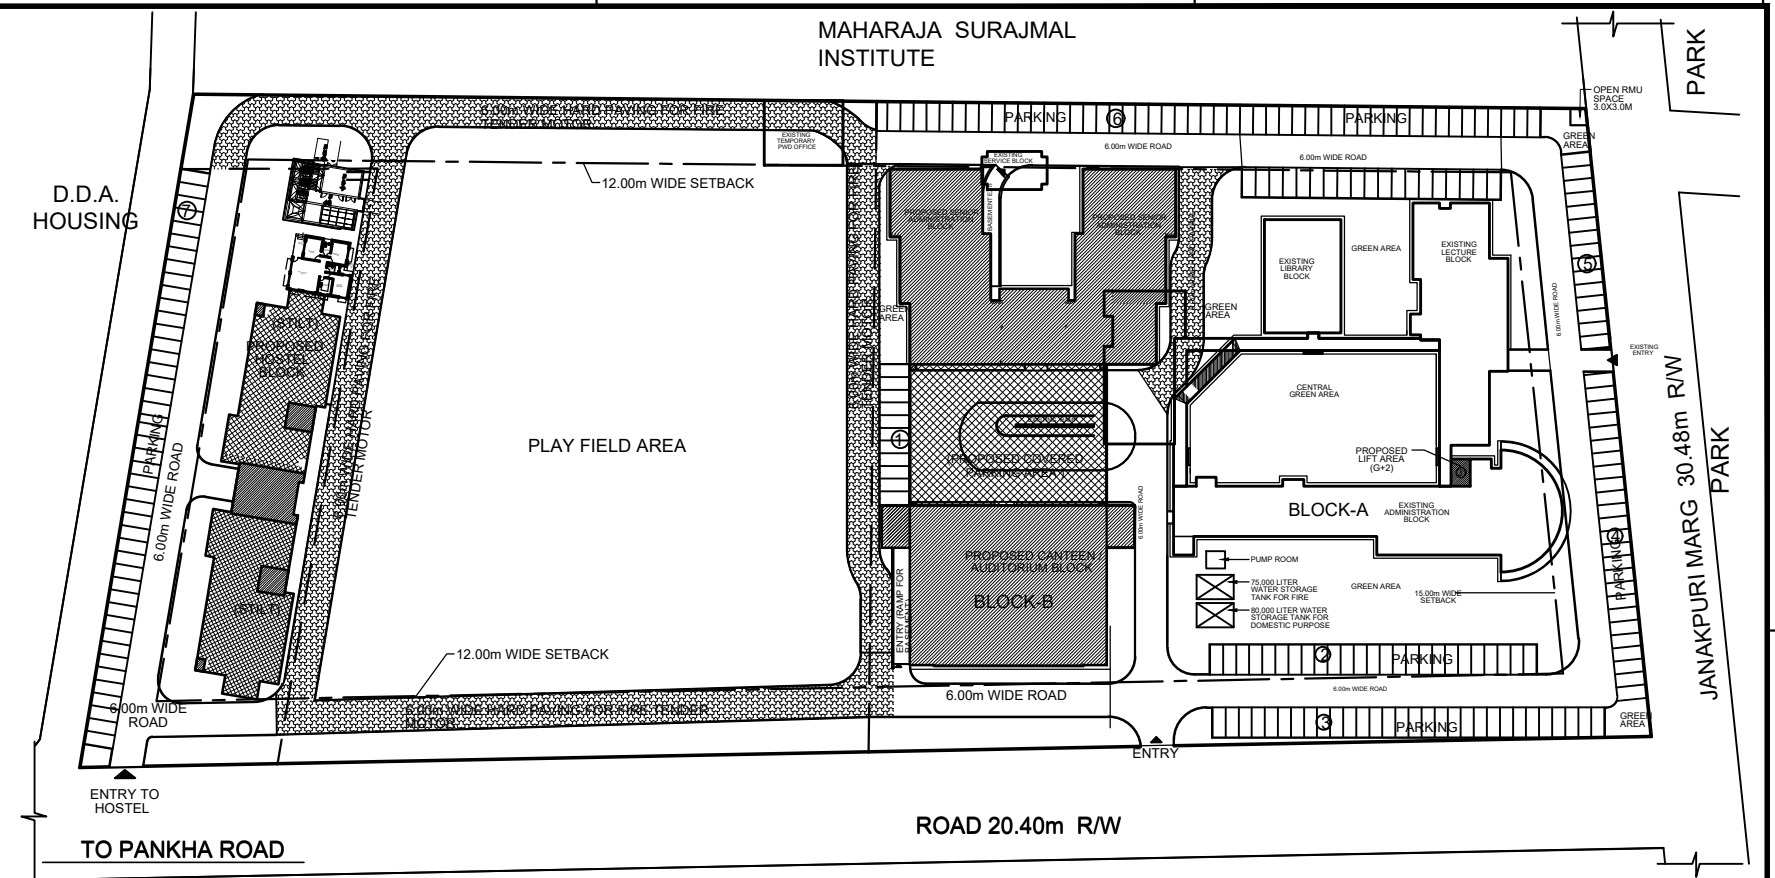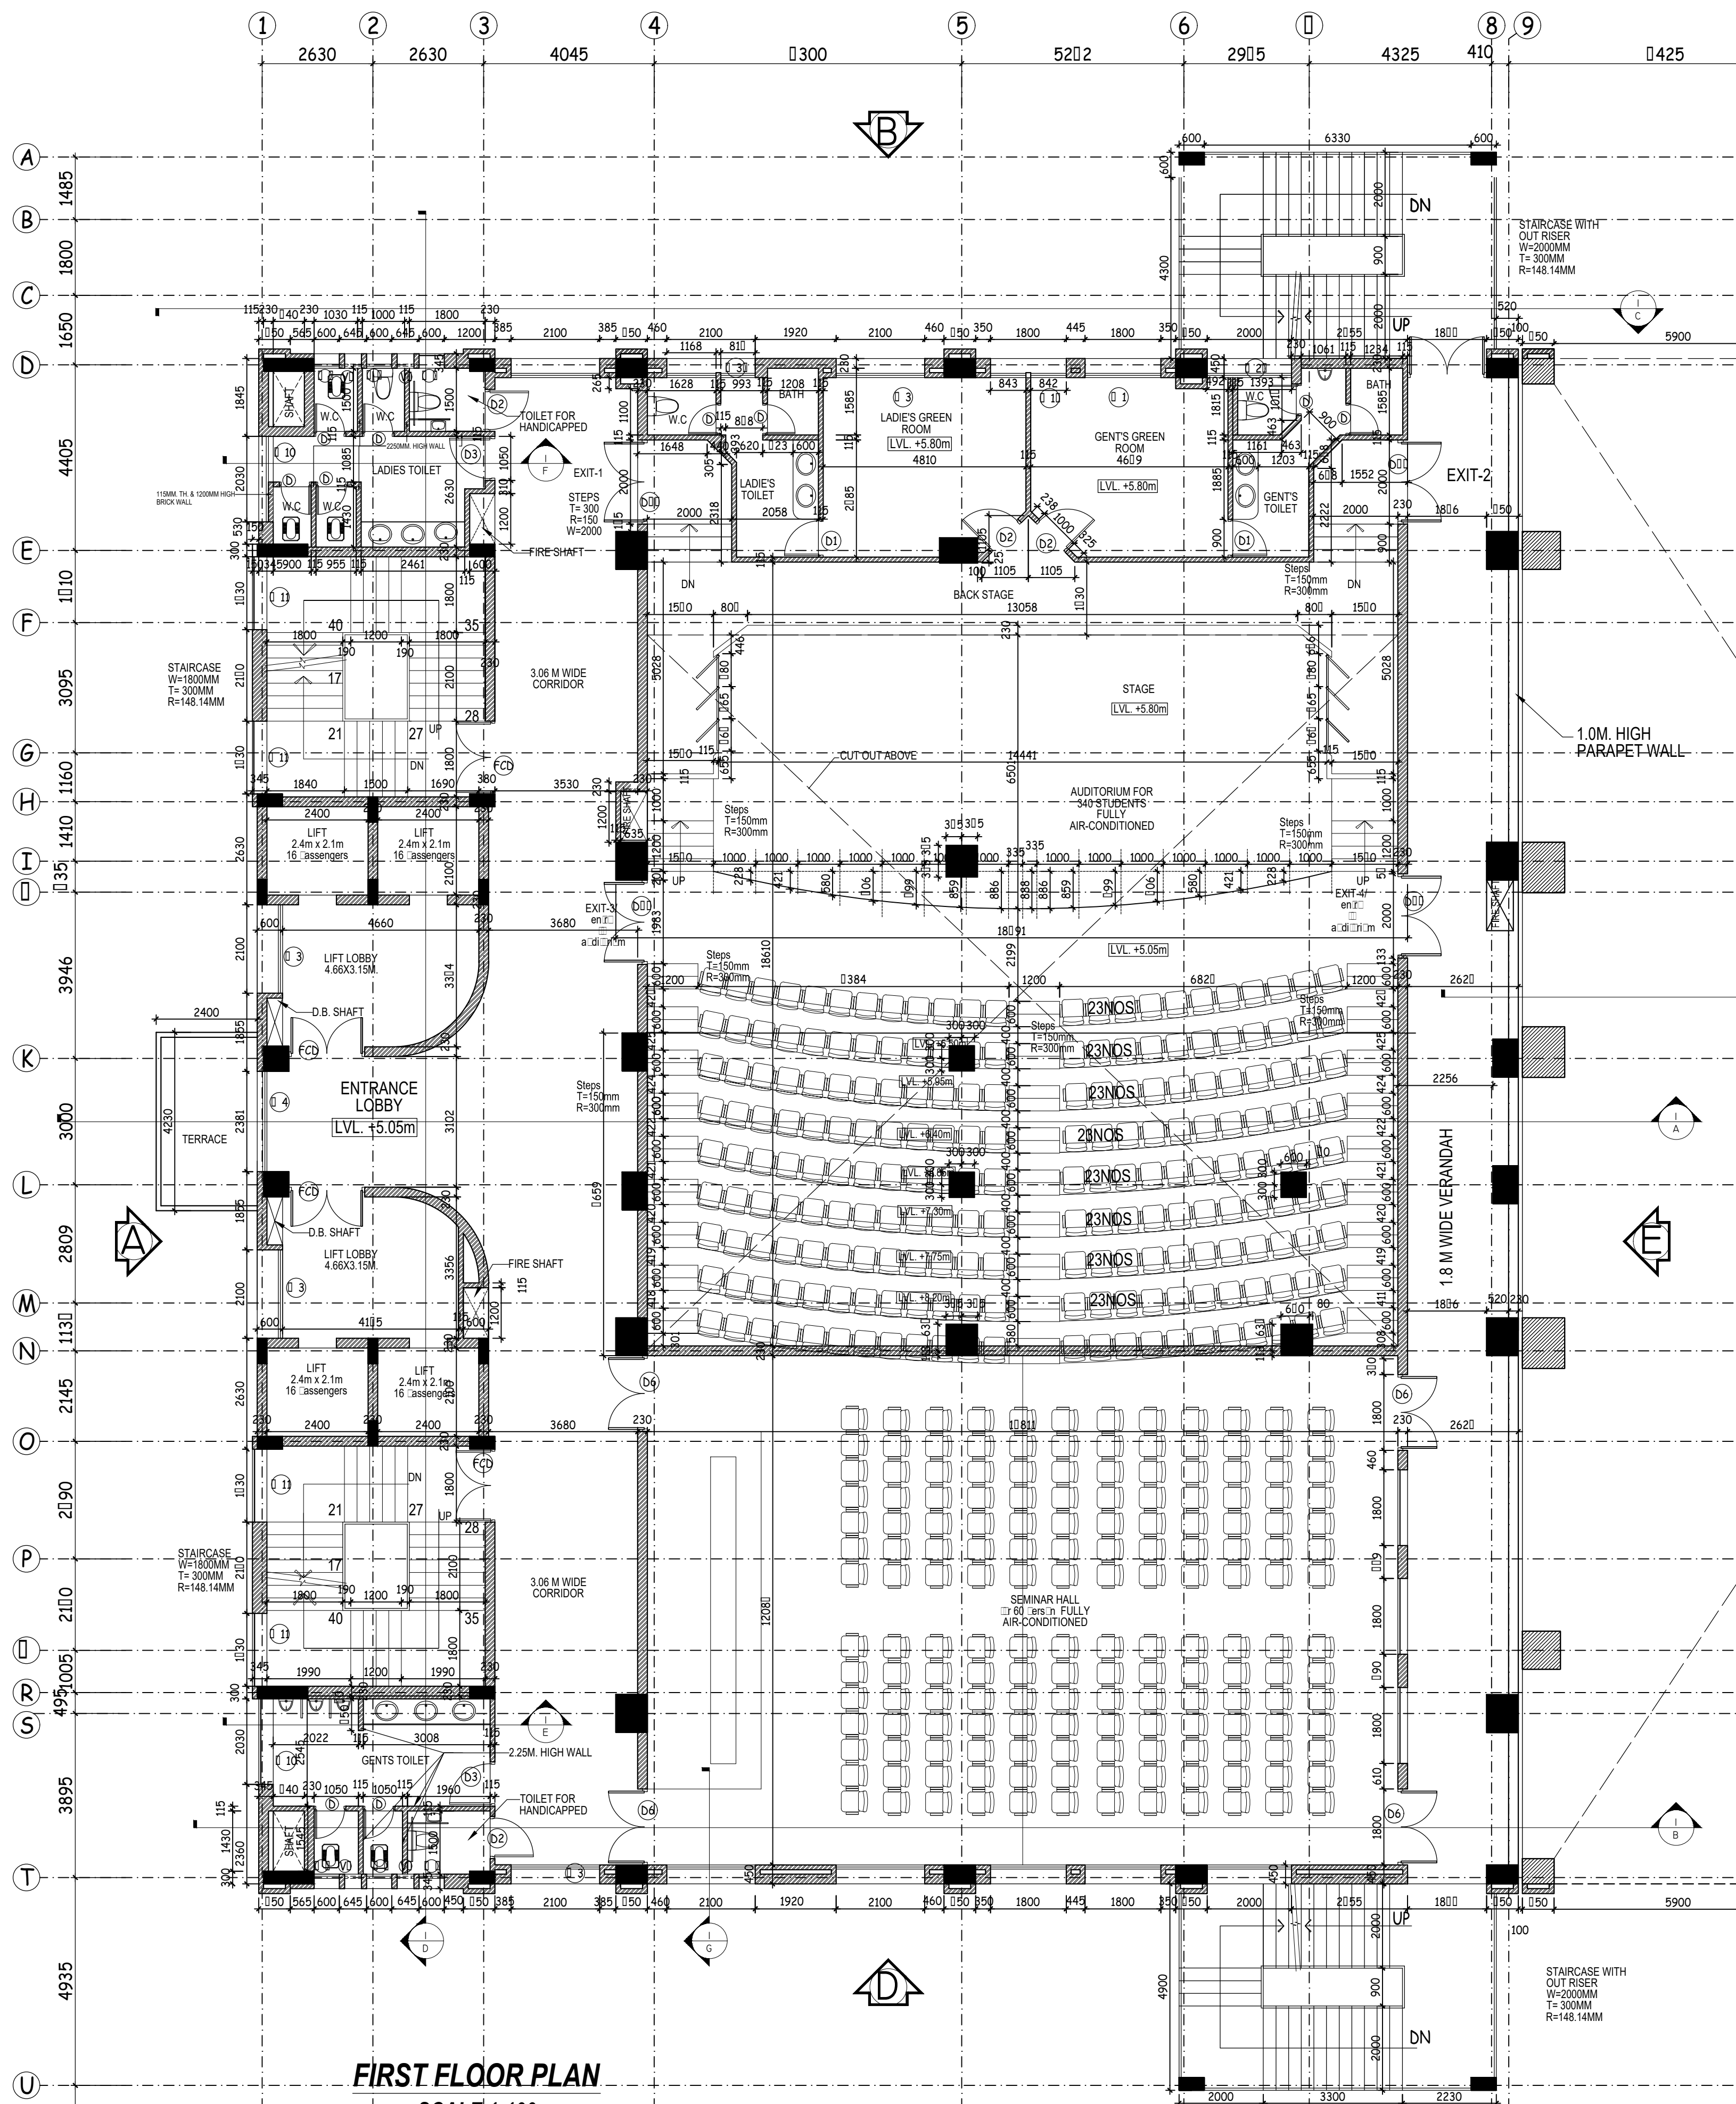

THIS DRAWING IS THE PROPERTY & COPYRIGHT OF M/S SPACE ACE & NO PART OF THIS DRAWING MAY BE USED OR REPRODUCED IN ANY MANNER, STORED IN A RETRIEVAL SYSTEM, OR TRANSMITTED IN ANY FORM OR BY ANY MEANS, ELECTRONIC, MECHANICAL, PHOTOCOPYING, RECORDING OR OTHERWISE, EXCEPT FOR THE RELATED PROJECT, WITHOUT THE WRITTEN PERMISSION OF M/S SPACE ACE

- NOTE :-**
- DO NOT SCALE THE DRAWING, FOLLOW WRITTEN DIMENSION ONLY.
 - ALL DIMENSIONS IN MM. AND LEVELS IN METERS.
 - 750 WIDE PLINTH PROTECTION TO BE PROVIDED ALL AROUND THE BUILDING.
 - SKIRTING SHALL BE 100MM. HIGH FROM FINISHED FLOOR LEVEL.
 - TOILET, PANTRY, KITCHEN VERANDAH & BALCONY FLOOR LEVEL SHALL BE 12 MM. DOWN FROM GENERAL FLOOR LEVEL.
 - CUPBOARDS SHALL HAVE SKIRTING OF 100 MM. HIGH.
 - LOCATION, SIZES & LEVELS OF MANHOLES TO BE CO-ORDINATED WITH EXTERNAL SEWERAGE LAY OUT PLAN GOT APPROVED BY ENGG. INCHARGE.
 - ALL MEASUREMENT MUST BE CHECKED AT SITE BY CONTRACTOR.

SANITARY LEGEND

W.P.	100MM DIA. WASTE PIPE
R.W.P.	100MM DIA. RAIN WATER PIPE
R.V.P.	100MM DIA. SOIL VENT PIPE
F.T.	FLOOR TRAP (100x100) MM
F.D.	FLOOR DRAIN (100x75) MM
F.C.O.	FLOOR CLEAN OUT
G.T.	GULLY TRAP (300x300)mm
M.H.	SEWER MANHOLE (600x600)mm
O.R.PAN (W.C.)	ORISSA PAN (W.C.)
WC	EUROPEAN PAN (W.C.)
100/75MM DIA. WASTE PIPE	
100MM DIA. SOIL PIPE	

REVISIONS

CLIENT
BHARATI COLLEGE,
C-4, JANAKPURI, NEW
DELHI-110058

TITLE
FIRST FLOOR PLAN
(AUDITORIUM BLOCK)

DRAWN BY - Ramprakash
DATE - 24-12-2013

SCALE - 1:100
DRG. NO. - AUDI.F.F/03
JOB. NO. - BC/02/13




CHECKED BY - S.R.

SPACE ACE
ARCHITECTS, ENGINEERS & PLANNERS

V-20A/5,
D.L.F. CITY III,
GURGAON, HARYANA - 122002
PH - 0124-4106618, FAX: 0124-2365329
E-MAIL : spaceace.india@gmail.com

DOOR & WINDOW SCHEDULE

S.NO.	SYMBOL	SIZE	SILL LVL.	LINTEL LVL.
DOOR				
1	D	740X2100	0	2100
2	D	750X2100	0	2100
3	D1	900X2400	0	2400
4	D2	1000X2400	0	2400
5	D3	1070X2400	0	2400
6	D4	1200X2400	0	2400
7	D5	1500X2400	0	2400
8	D6	1800X2400	0	2400
9	D7	2000X2400	0	2400
10	D8	2000X2400	0	2400
11	D9	2000X2400	0	2400
208	D206	2000X2400	0	2400

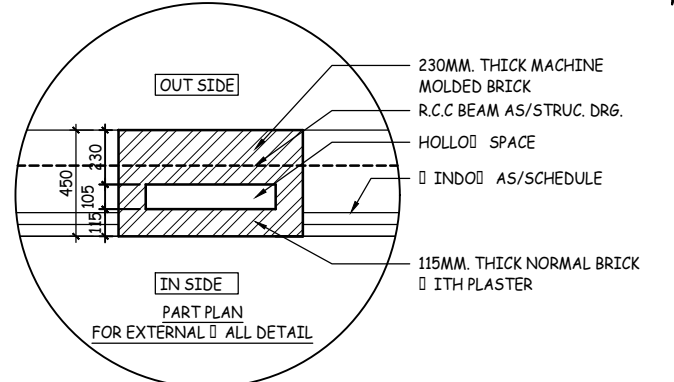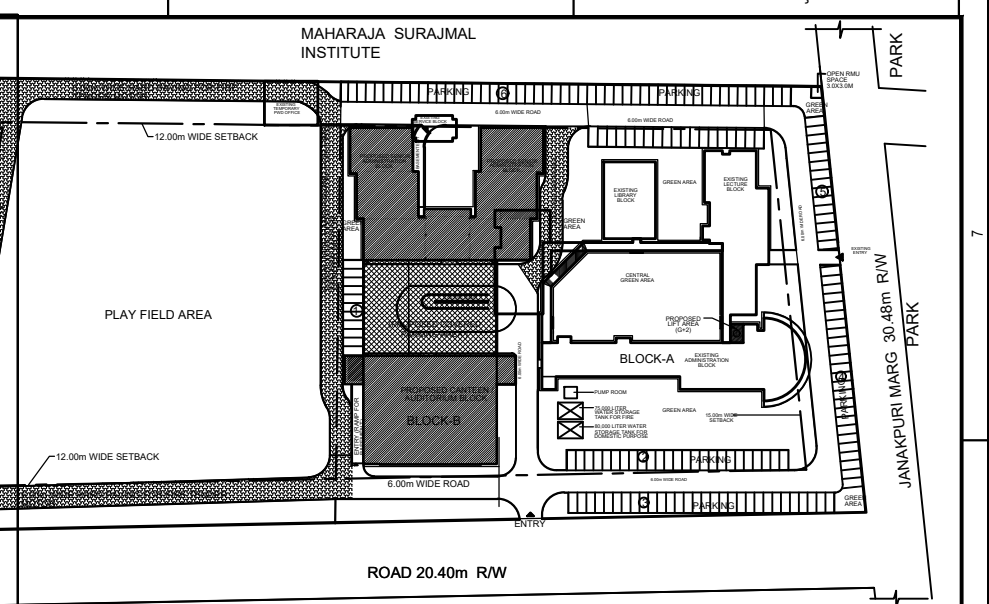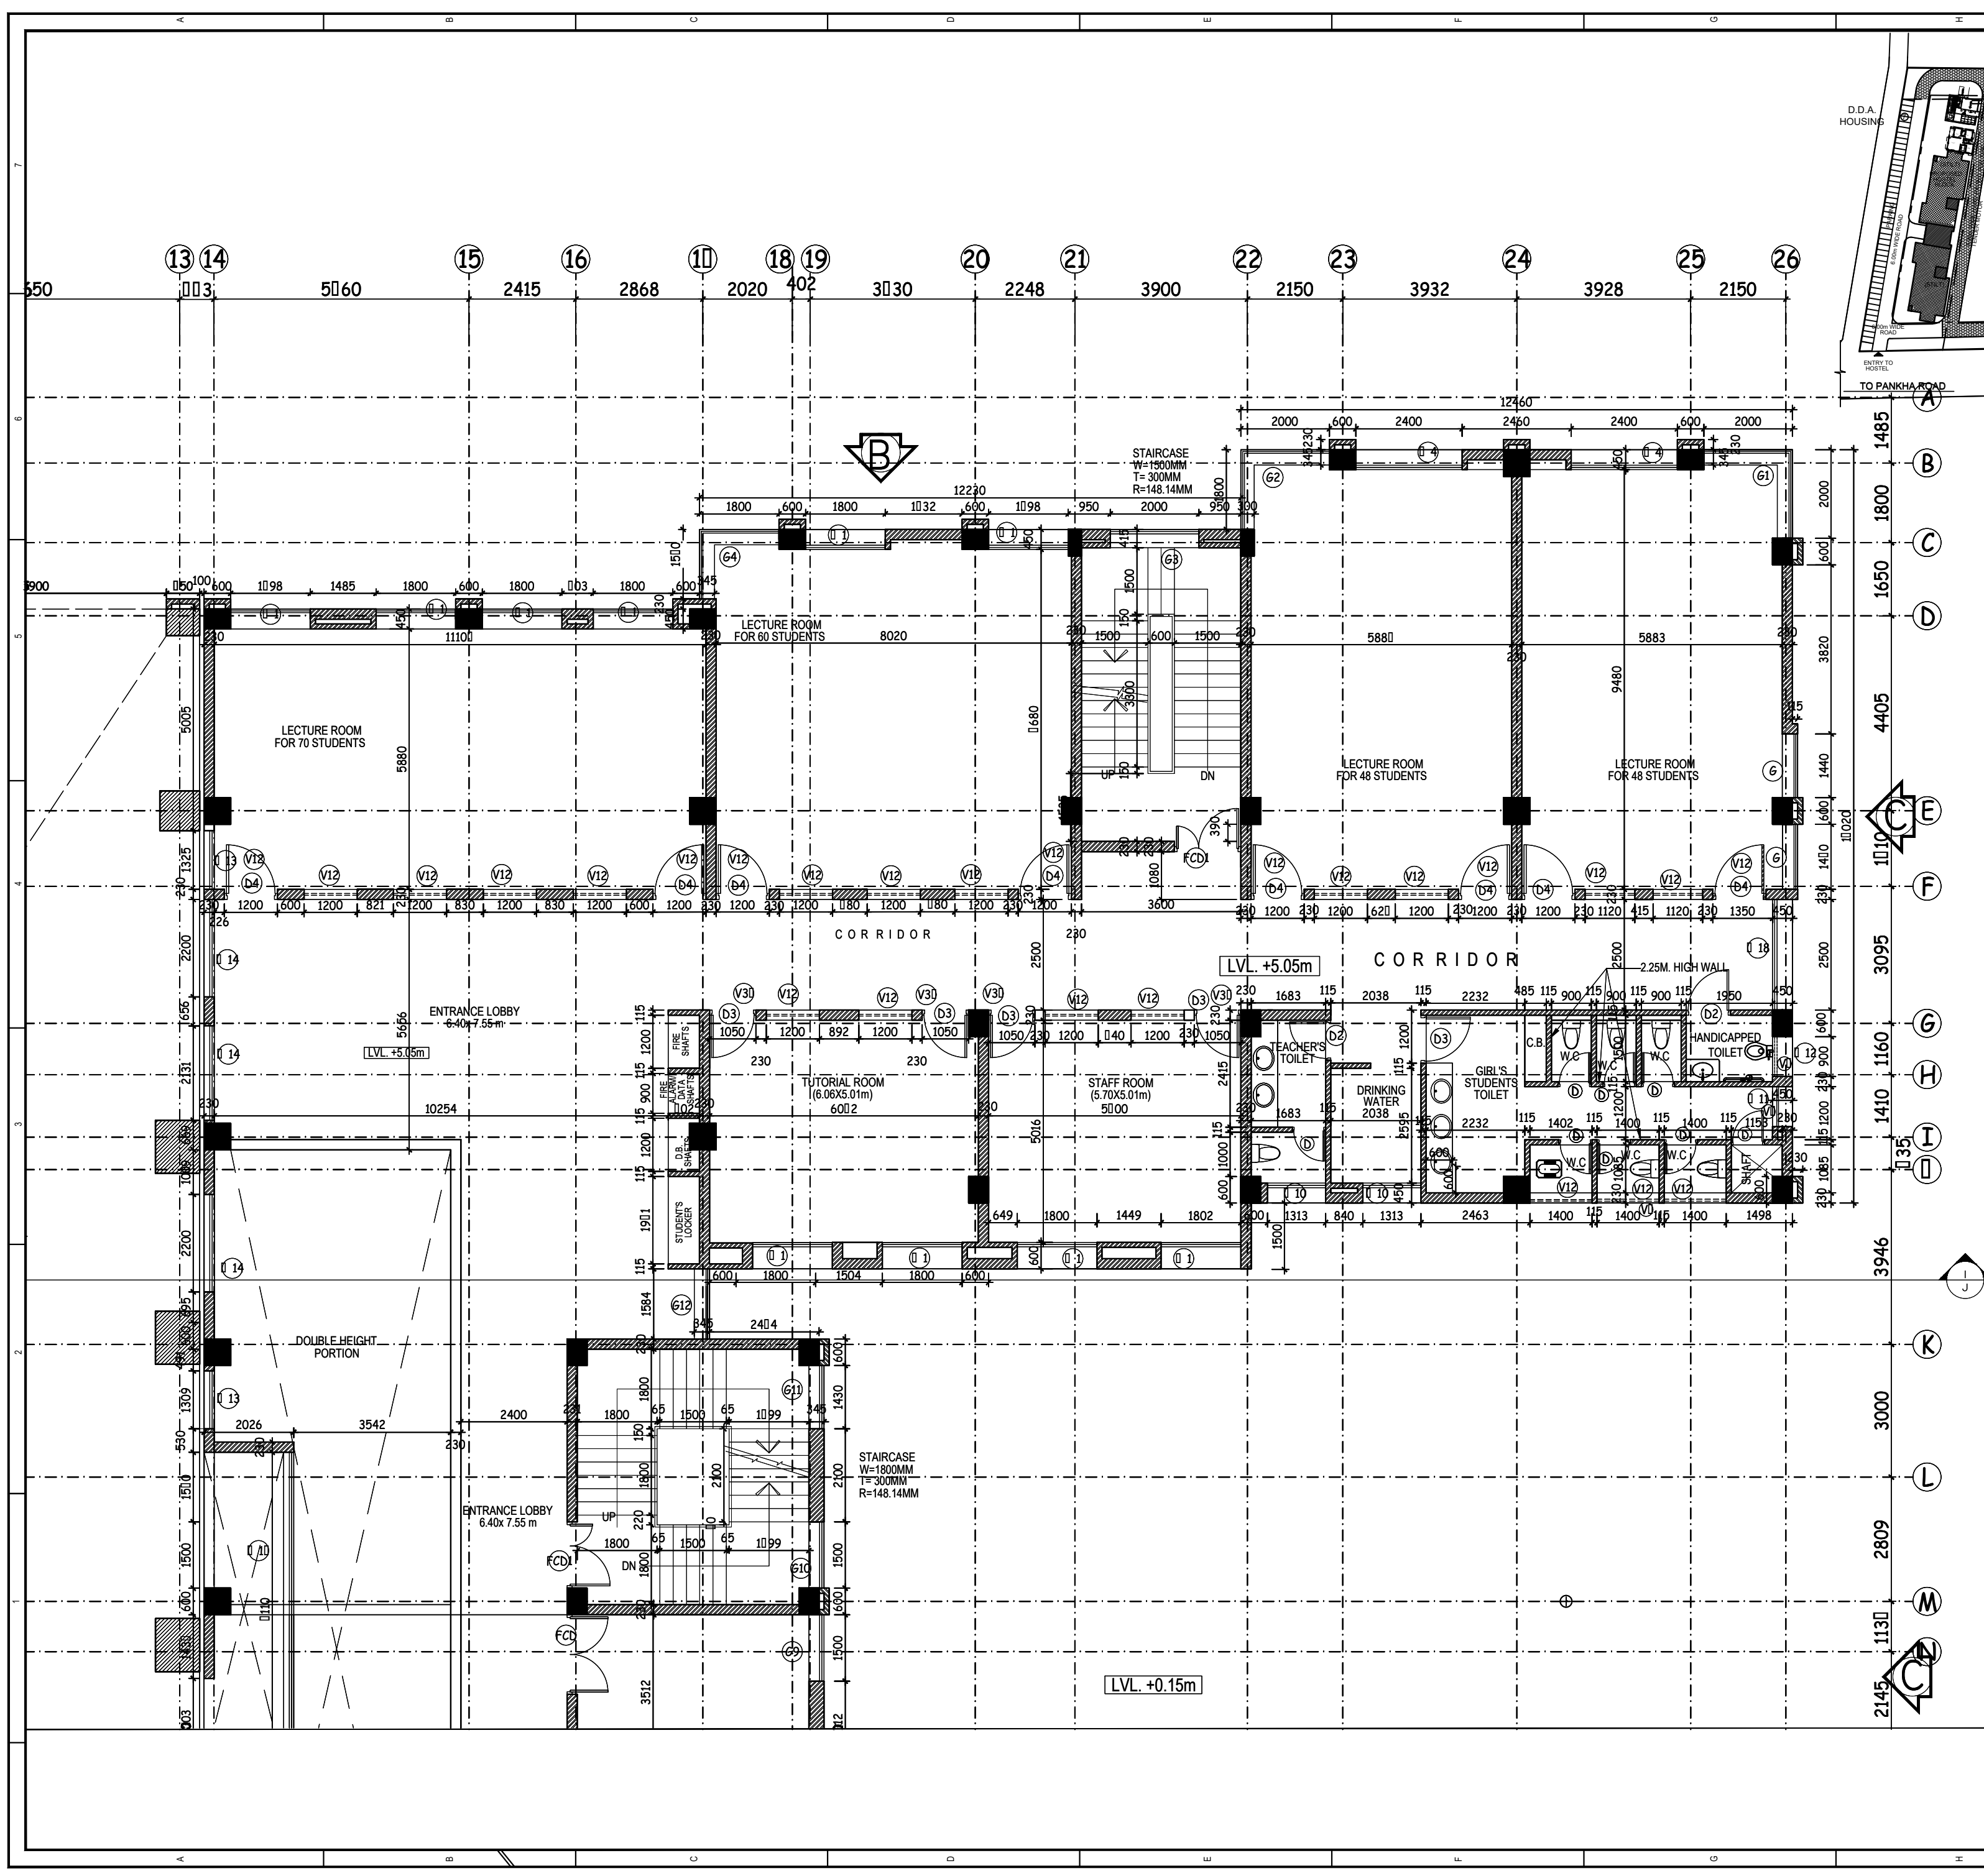

DOOR & WINDOW SCHEDULE				
S.NO.	SYMBOL	SIZE	SILL LVL.	LINTEL LVL.
1	D1	740X2100	0	2100
2	D2	750X2100	0	2100
3	D3	900X2400	0	2400
4	D4	1000X2400	0	2400
5	D5	1050X2400	0	2400
6	D6	1200X2400	0	2400
7	D7	1500X2400	0	2400
8	D8	1800X2400	0	2400
9	D9	2000X2400	0	2400
10	D10	2290X2400	0	2400
11	D11	2025X4300	0	4300
12	D12	1730X4300	0	4300
13	D13	2380X3400	0	3400
14	D14	2400X3400	0	3400
15	D15	2110X2400	0	2400

FIRE DOOR			
S.NO.	SYMBOL	SIZE	LVL.
1	FCD	1730X2400	0
2	FCD1	1500X2400	0

WINDOW			
S.NO.	SYMBOL	SIZE	LVL.
1	W1	600X2500	900
2	W2	1800X1500	900
3	W3	2000X1500	900
4	W4	2400X1500	900
5	W5	2290X1500	900
6	W6	1300X2250	150
7	W7	2400X1500	150
8	W8	2030X3250	150
9	W9	1800X3250	150
10	W10	1300X1200	1200
11	W11	900X1500	900
12	W12	900X1200	1200
13	W13	1300X1500	900
14	W14	2200X1500	900
15	W15	3000X1500	900
16	W16	3300X1500	900
17	W17	7100X1500	900
18	W18	2500X1500	900

VENTILATOR			
S.NO.	SYMBOL	SIZE	LVL.
1	V1	400X400	2630
2	V2	200X750	3100
3	V3	2100X900	2500
4	V4	2100X1320	2080
5	V5	2100X1720	1680
6	V6	1800X1200	1280
7	V7	1800X1200	1280
8	V8	2000X2480	920
9	V9	1800X750	3100
10	V10	2100X300	3100
11	V11	2100X300	3100
12	V12	1200X450	2630
13	V13	2400X750	3100
14	V14	1800X1944	1456
15	V15	1800X1580	1820
16	V16	1300X1370	2030
17	V17	1300X1130	2270
18	V18	1300X750	3100
19	V19	2200X750	3100
20	V20	3000X300	3250
21	V21	3300X300	3250
22	V22	2280X300	3250
23	V23	1050X450	2630
24	V24	1000X450	2630

ROLLING SHUTTER			
S.NO.	SYMBOL	SIZE	LVL.
1	RS	3100X3400	0
2	RS1	4000X2700	0
3	RS2	3050X2950	0

GLAZING			
S.NO.	SYMBOL	SIZE	LVL.
1	G1	1440X14250	150
2	G2	2000+2000X14250	150
3	G3	2000+1800X1530	150
4	G4	2000X19150	150
5	G5	1570+1800X15300	150
6	G6	2000+2000X15300	150
7	G7	1800+1800X15300	150
8	G8	2800X19150	150
9	G9	1570X15150	300
10	G10	1500X19150	300
11	G11	1430X19150	300
12	G12	1580X14250	1200

THIS DRAWING IS THE PROPERTY & COPYRIGHT OF M/S SPACE ACE & NO PART OF THIS DRAWING MAY BE USED OR REPRODUCED IN ANY MANNER, STORED IN A RETRIEVAL SYSTEM, OR TRANSMITTED IN ANY FORM OR BY ANY MEANS, ELECTRONIC, MECHANICAL, PHOTOCOPYING, RECORDING OR OTHERWISE, EXCEPT FOR THE RELATED PROJECT, WITHOUT THE WRITTEN PERMISSION OF M/S SPACE ACE

- NOTE :-
1. DO NOT SCALE THE DRAWING, FOLLOW WRITTEN DIMENSION ONLY
 2. ALL DIMENSIONS IN MM. AND LEVELS IN METERS.
 3. 750 WIDE PLINTH PROTECTION TO BE PROVIDED ALL AROUND THE BUILDING.
 4. SKIRTING SHALL BE 100MM. HIGH FROM FINISHED FLOOR LEVEL.
 5. TOILET, PANTRY, KITCHEN VERANDAH & BALCONY FLOOR LEVEL SHALL BE 12 MM. DOWN FROM GENERAL FLOOR LEVEL.
 6. CUPBOARDS SHALL HAVE SKIRTING OF 100 MM. HIGH.
 7. LOCATION, SIZES & LEVELS OF MANHOLES TO BE CO-ORDINATED WITH EXTERNAL SEWERAGE LAY OUT PLAN GOT APPROVED BY ENGG. INCHARGE.
 8. ALL MEASUREMENT MUST BE CHECKED AT SITE BY CONTRACTOR.
- SANITARY LEGEND
- R.W.P. 100MM DIA. WASTE PIPE
 - R.V.P. 100MM DIA. RAIN WATER PIPE
 - F.T. 100MM DIA. SOIL VENT PIPE
 - F.D. FLOOR DRAIN (100X75) MM
 - F.C.O. FLOOR CLEAN OUT
 - G.T. GULLY TRAP (300X500) MM
 - S.H. SEWER MANHOLE (600X600) MM
 - WC ORISSA PAN (W.C)
 - E.P. EUROPEAN PAN (W.C)
 - 100/75MM DIA. WASTE PIPE
 - 100MM DIA. SOIL PIPE

REVISIONS


CLIENT
**BHARATI COLLEGE,
C-4, JANAKPURI, NEW
DELHI-110058**

TITLE
**PART FIRST FLOOR PLAN
(Academic Block)**

DRAWN BY - Ramraash
DATE - 24-12-2013
SCALE - 1:100
DRG. NO. - AD/F.F/03
JOB. NO. - BC/02/13
CHECKED BY - S.R.

SPACE ACE
ARCHITECTS, ENGINEERS & PLANNERS

V-20A/5,
D.L.F. CITY III,
GURGAON, HARYANA - 122002
PH - 0124-4106418, FAX: 0124-2365329
E-MAIL : spaceace.india@gmail.com

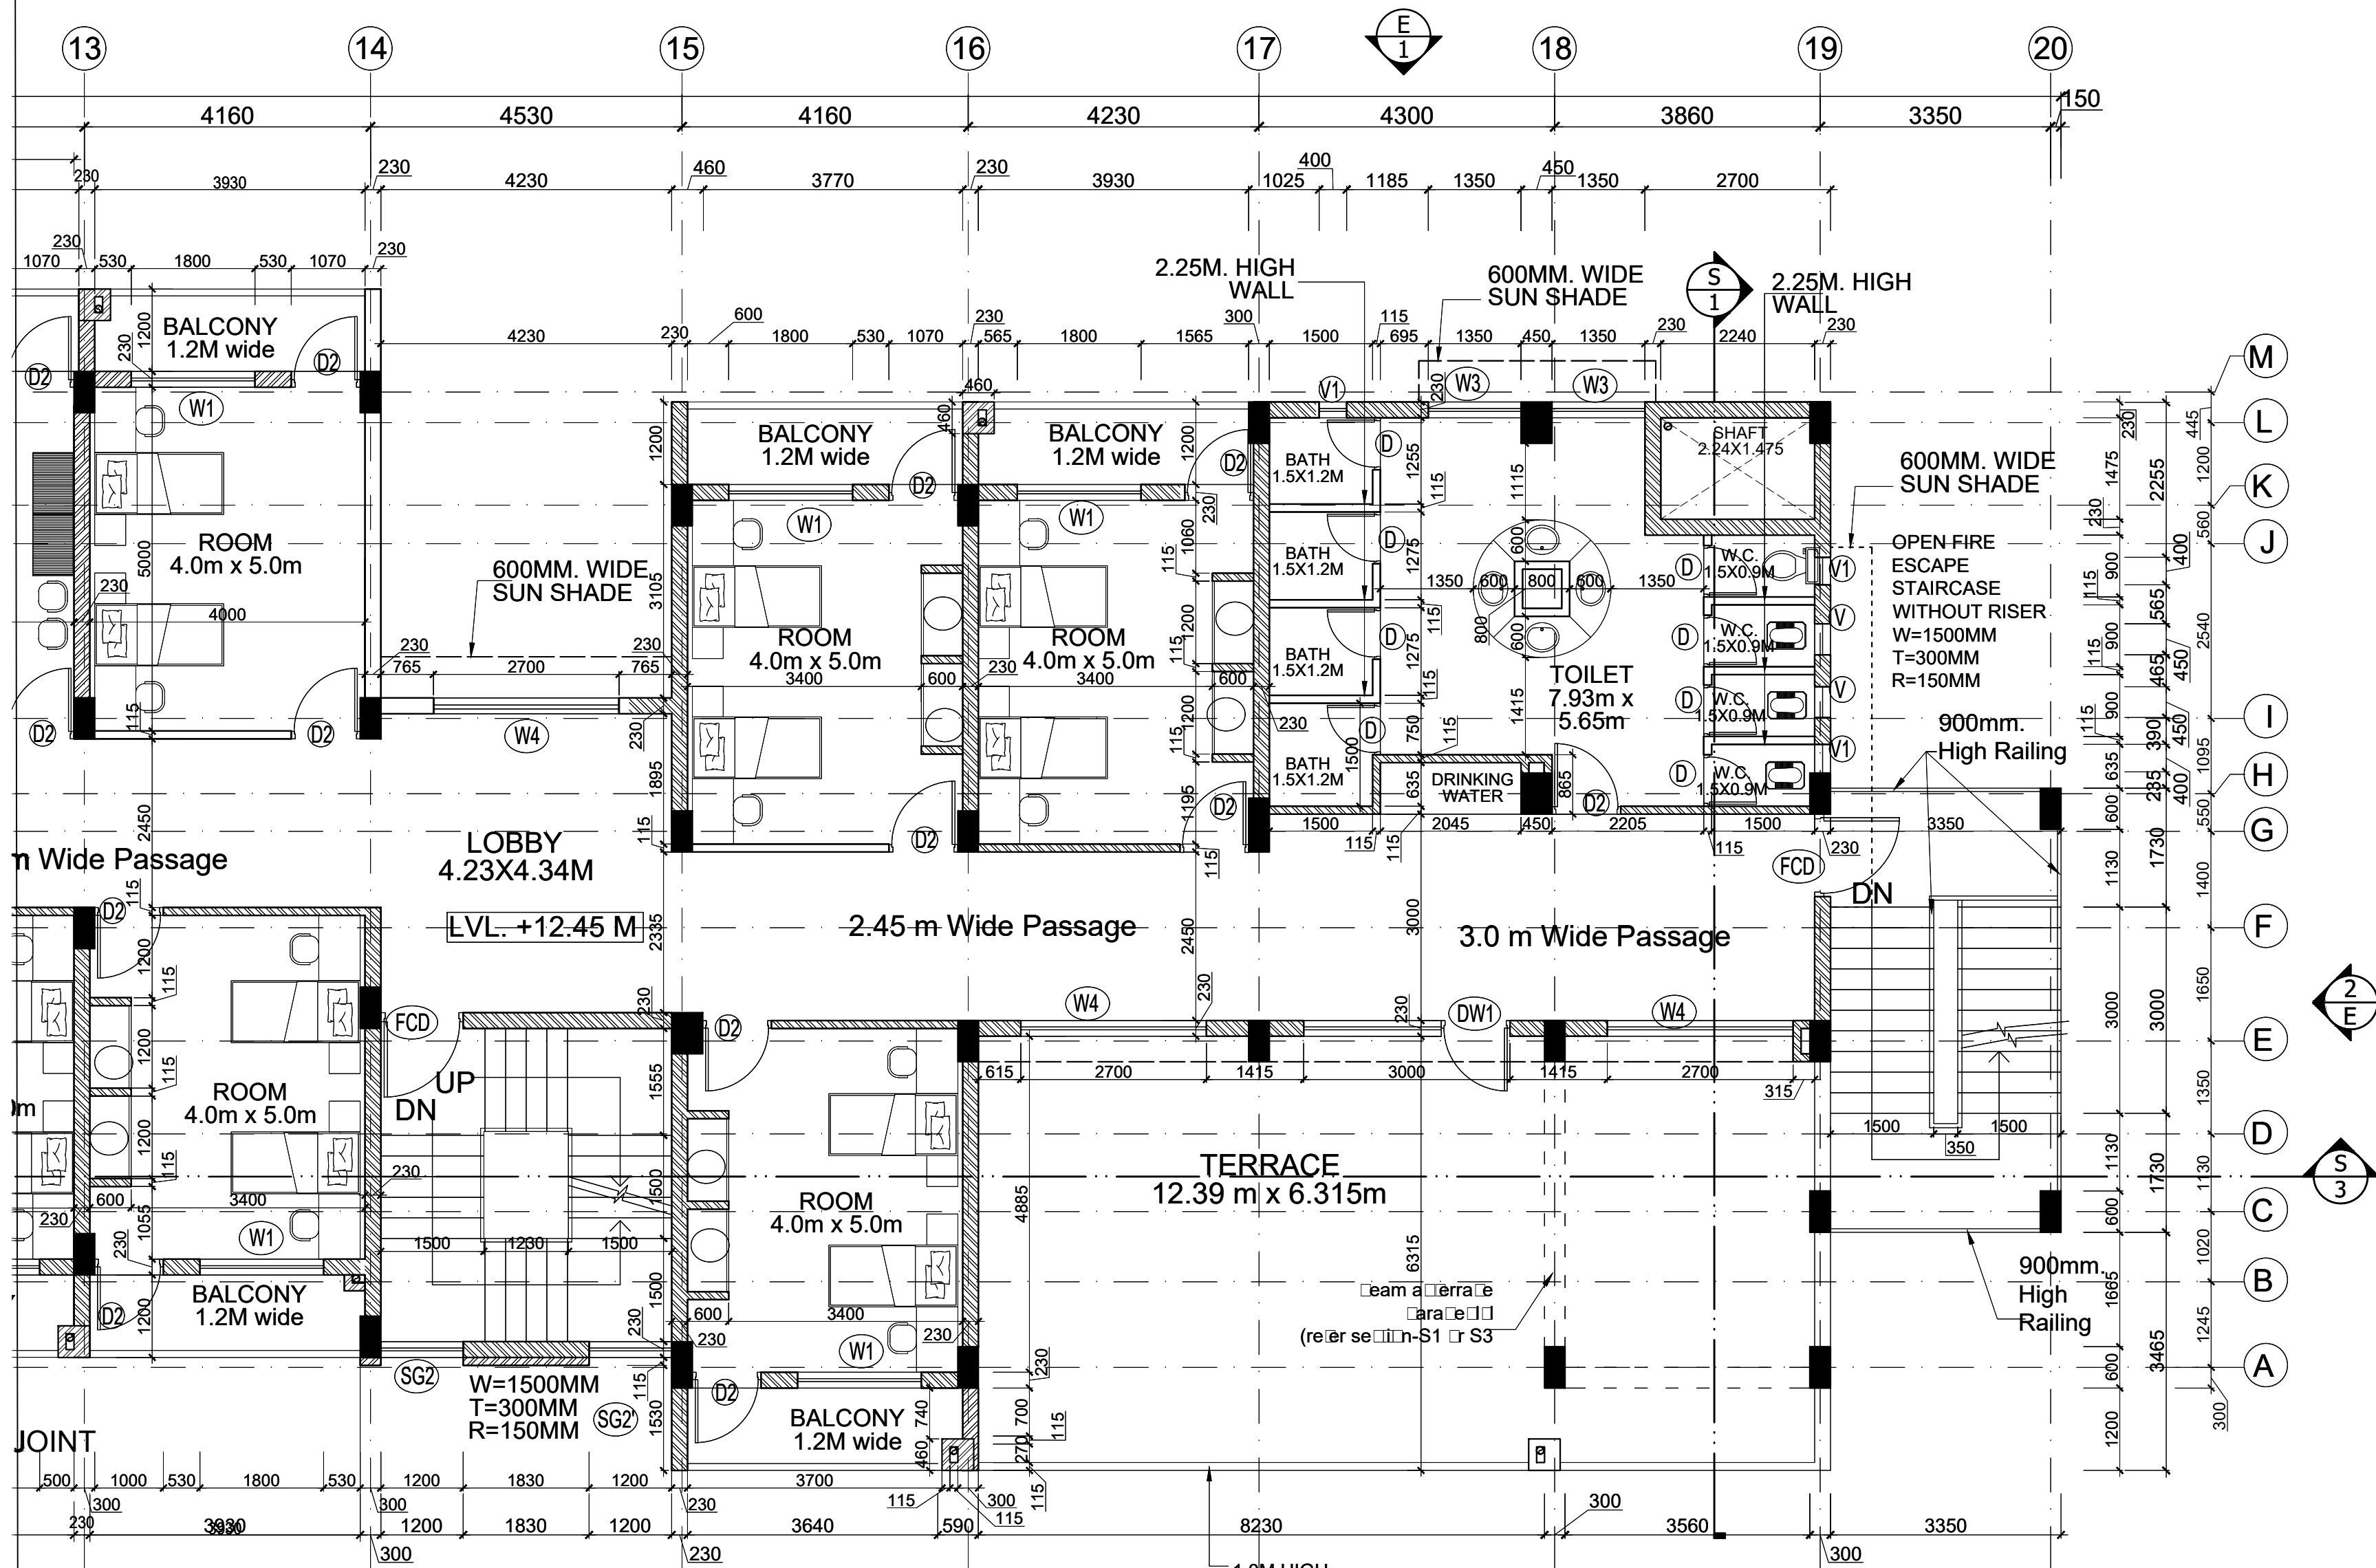

SCHEDULE OF DOORS & WINDOWS				
S.NO.	SYMBOL	SIZE	SILL LVL.	LINTEL LVL.
DOORS				
1	D	750X2100	0	2100
2	D'	750X2000	0	2000
3	D1	900X2400	0	2400
4	D2	1000X2400	0	2400
5	D3	1000X2400	0	2400
6	D4	1800X2400	0	2400
7	D4'	1800X2000	0	2000
8	D5	1500X2400	0	2400
9	DE	2400X2000	0	2000
10	DE1	2400X2400	0	2400
FIRE DOOR				
1	FCD	1200X2400	0	2400
2	FCD'	1200X2000	0	2000
WINDOWS				
1	W	1800X2100	300	2400
2	W'	1800X1700	300	2000
3	W1	1800X1500	900	2400
4	W2	1500X1500	900	2400
5	W3	1350X1500	900	2400
6	W4	2700X1500	900	2400
DOOR-WINDOW				
1	DW1	3000X2400	900	2400
VENTILATOR				
1	V	450X900	1500	2400
2	V1	400X400	2000	2400

THIS DRAWING IS THE PROPERTY & COPYRIGHT OF M/S SPACE ACE & NO PART OF THIS DRAWING MAY BE USED OR REPRODUCED IN ANY MANNER, STORED IN A RETRIEVAL SYSTEM, OR TRANSMITTED IN ANY FORM OR BY ANY MEANS, ELECTRONIC, MECHANICAL, PHOTOCOPYING, RECORDING OR OTHERWISE, EXCEPT FOR THE RELATED PROJECT, WITHOUT THE WRITTEN PERMISSION OF M/S SPACE ACE

SANITARY LEGEND
 100 DIA. WASTE PIPE (W.P.)
 100 DIA. RAIN WATER PIPE (R.W.P.)
 100 DIA. SOIL PIPE/SOIL VENT PIPE (S.V.P.)
 300X300 GULLY TRAP
 M.H. MAN HOLE
 WASTE PIPE 100 DIA.
 SOIL PIPE 100 DIA.
 ORRISA PAN (W.C.)
 EUROPEAN W.C. PAN

NOTE :-
 1. DO NOT SCALE THE DRAWING, FOLLOW WRITTEN DIMENSION ONLY.
 2. ALL DIMENSIONS IN MM. AND LEVELS IN METERS.
 3. 750 WIDE PLINTH PROTECTION TO BE PROVIDED ALL AROUND THE BUILDING.
 4. SKIRTING SHALL BE 100MM. HIGH FROM FINISHED FLOOR LEVEL.
 5. TOILET/PANTRY, KITCHEN VERANDAH & BALCONY FLOOR LEVEL SHALL BE 12 MM. DOWN FROM GENERAL FLOOR LEVEL.
 6. CUPBOARDS SHALL HAVE SKIRTING OF 100 MM. HIGH.
 7. LOCATION, SIZES & LEVELS OF MANHOLES TO BE CO-ORDINATED WITH EXTERNAL SEWERAGE LAY OUT PLAN GOT APPROVED BY ENGG. INCHARGE.
 8. ALL MEASUREMENT MUST BE CHECKED AT SITE BY CONTRACTOR.



REVISIONS	
R1	12-02-2014
R2	20-02-2014

DRAWN BY	- RUBY
DATE	- 29-08-2013
SCALE	- 1:50
DRG.NO.	- 6H/T.F/05
JOB. NO.	- BH.C/JNK/13
CHECKED BY	- RAMPRAKASH

TITLE
PART THIRD FLOOR PLAN
GIRLS HOSTEL BLOCK

CLIENT
BHARATI COLLEGE

SPACE ACE
 ARCHITECTS, ENGINEERS & PLANNERS
 V- 20A / 5,
 D.L.F. CLTY III,
 GURGAON, HARYANA - 122002
 PH- 0124-406618, FAX: 0124-2365329
 E-MAIL : spaceace.india@gmail.com

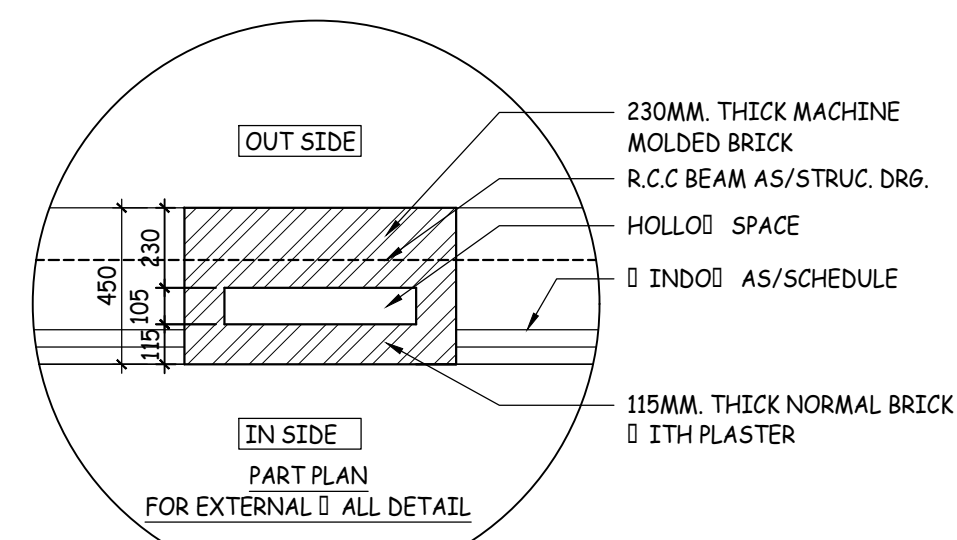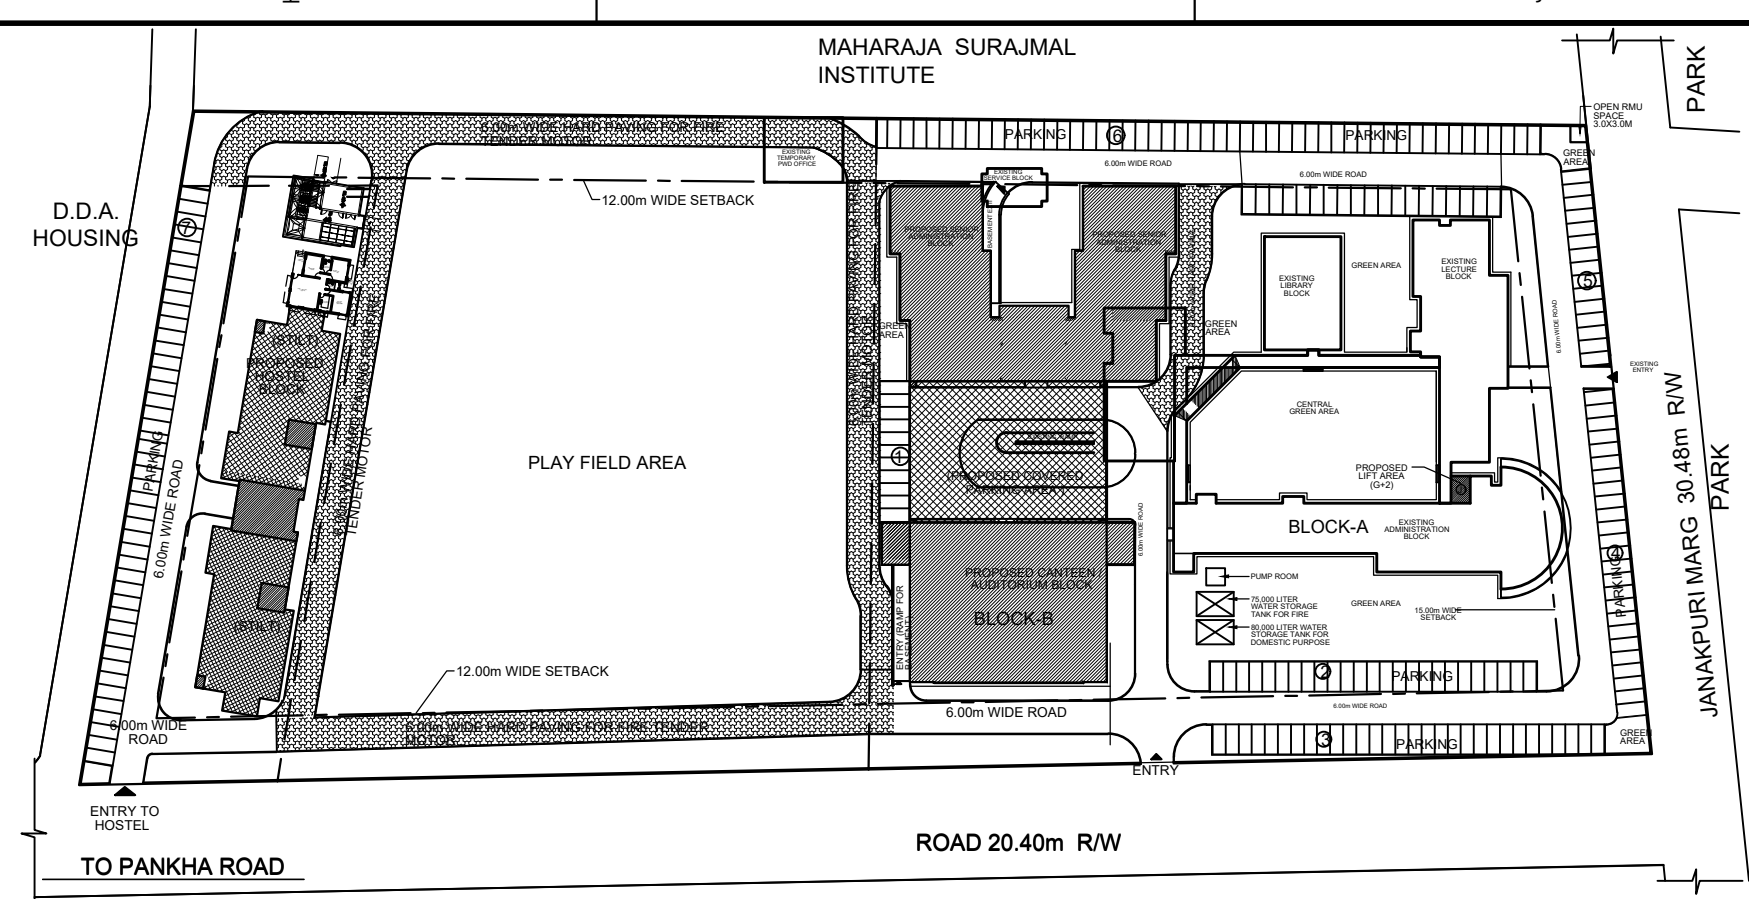

THIS DRAWING IS THE PROPERTY & COPYRIGHT OF M/S SPACE ACE & NO PART OF THIS DRAWING MAY BE USED OR REPRODUCED IN ANY MANNER, STORED IN A RETRIEVAL SYSTEM, OR TRANSMITTED IN ANY FORM OR BY ANY MEANS, ELECTRONIC, MECHANICAL, PHOTOCOPYING, RECORDING OR OTHERWISE, EXCEPT FOR THE RELATED PROJECT, WITHOUT THE WRITTEN PERMISSION OF M/S SPACE ACE

- NOTE :-
- DO NOT SCALE THE DRAWING, FOLLOW WRITTEN DIMENSION ONLY.
 - ALL DIMENSIONS IN MM. AND LEVELS IN METERS.
 - 750 WIDE PLINTH PROTECTION TO BE PROVIDED ALL AROUND THE BUILDING.
 - SKIRTING SHALL BE 100MM. HIGH FROM FINISHED FLOOR LEVEL.
 - TOILET, PANTRY, KITCHEN VERANDAH & BALCONY FLOOR LEVEL SHALL BE 12 MM. DOWN FROM GENERAL FLOOR LEVEL.
 - CUPBOARDS SHALL HAVE SKIRTING OF 100 MM. HIGH.
 - LOCATION, SIZES & LEVELS OF MANHOLES TO BE CO-ORDINATED WITH EXTERNAL SEWERAGE LAY OUT PLAN GOT APPROVED BY ENGG. INCHARGE.
 - ALL MEASUREMENT MUST BE CHECKED AT SITE BY CONTRACTOR.

- SANITARY LEGEND
- W.P. 100MM DIA. WASTE PIPE
 - R.W.P. 100MM DIA. RAIN WATER PIPE
 - R.V.P. 100MM DIA. SOIL VENT PIPE
 - F.T. FLOOR TRAP (100x100) MM
 - F.D. FLOOR DRAIN (100x75) MM
 - F.C.O. FLOOR CLEAN OUT
 - G.T. GULLY TRAP (300x300)mm
 - M.H. SEWER MANHOLE (600x600)mm
 - ORISSA PAN (W.C)
 - WC EUROPEAN PAN (W.C)
 - 100/75MM DIA. WASTE PIPE
 - 100MM DIA. SOIL PIPE

REVISIONS


CLIENT
**BHARATI COLLEGE,
C-4, JANAKPURI, NEW
DELHI-110058**

TITLE SECOND FLOOR PLAN (AUDITORIUM BLOCK)

DRAWN BY - Ramprakash
DATE - 24-12-2013
SCALE - 1:100
DRG.NO. - AUDI./S.F/04
JOB. NO. - BC/02/13
CHECKED BY - S.R.


SPACE ACE
ARCHITECTS, ENGINEERS &
PLANNERS

V-20A/5,
D.L.F. CITY III,
GURGAON, HARYANA - 122002
PH - 0124-4106618, FAX: 0124-2365329
E-MAIL : spaceace.india@gmail.com

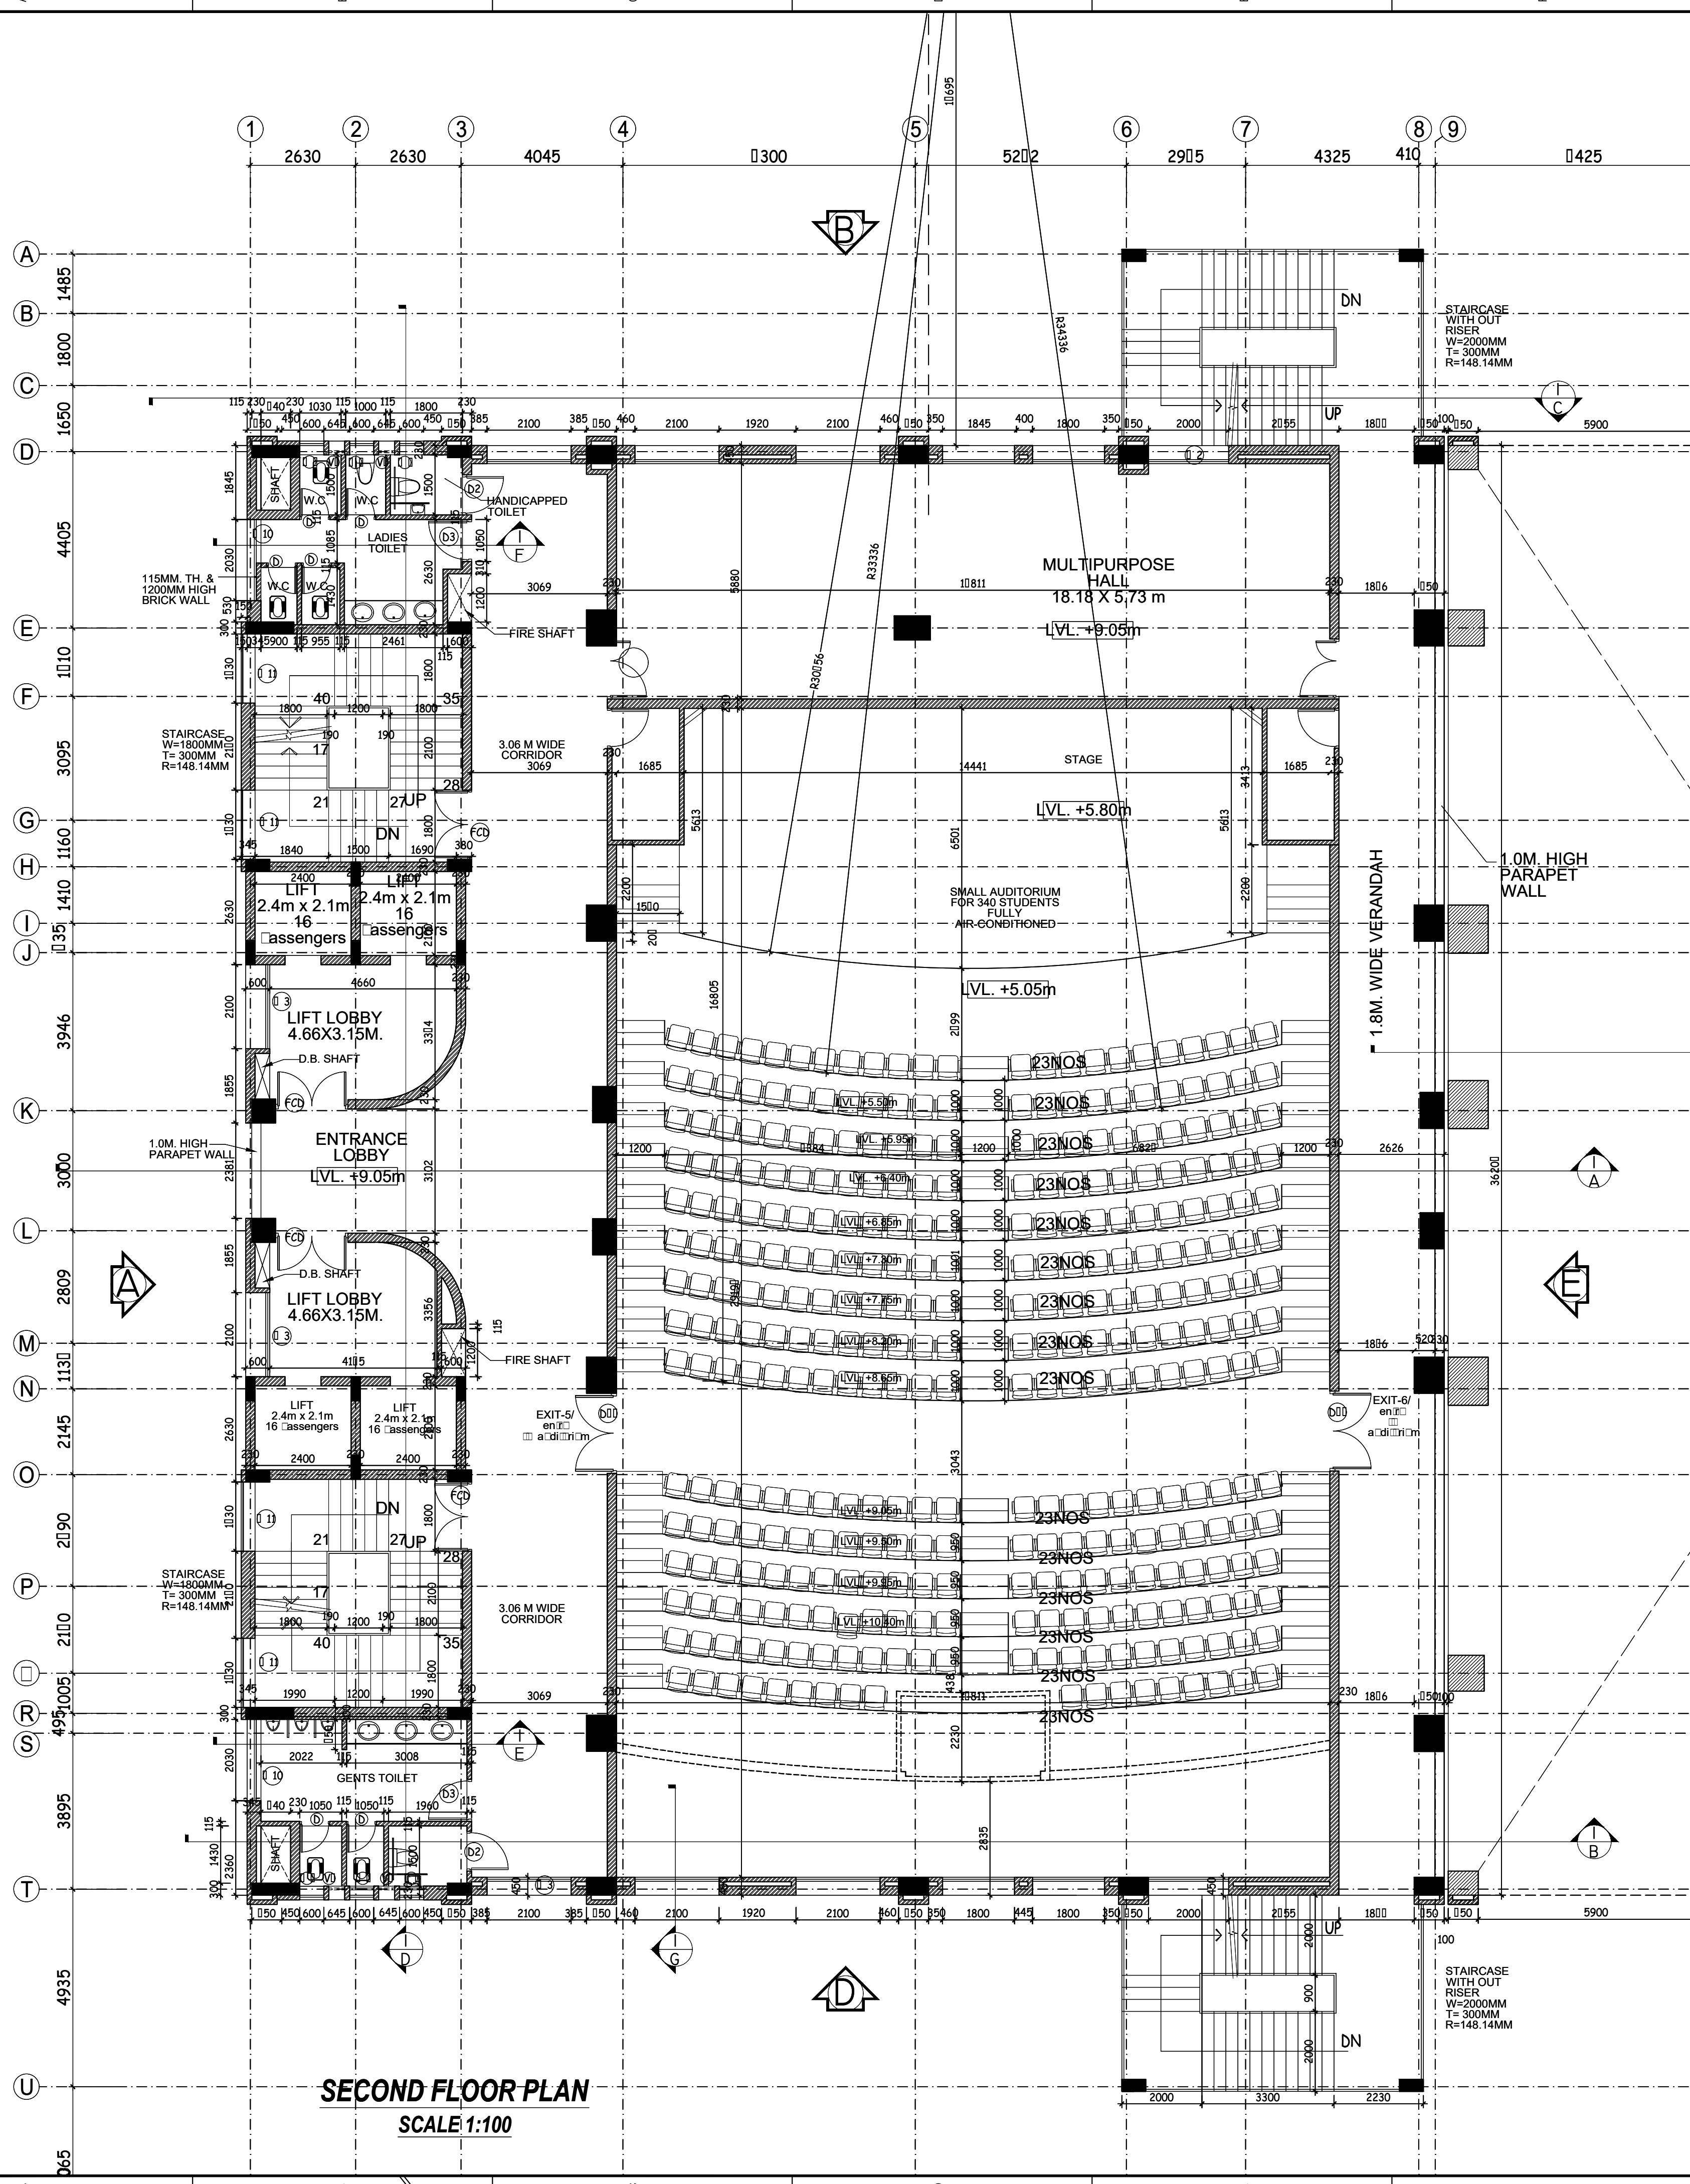

SECOND FLOOR PLAN
SCALE 1:100

DOOR & WINDOW SCHEDULE			
S.NO.	SYMBOL	SIZE	SILL LVL. LINTEL LVL.
DOOR			
1	D	740X2100	0 2100
2	D	750X2100	0 2100
3	D1	900X2400	0 2400
4	D2	1000X2400	0 2400
5	D3	1070X2400	0 2400
6	D4	1200X2400	0 2400
7	D5	1500X2400	0 2400
8	D6	1800X2400	0 2400
9	D7	2000X2400	0 2400
10	D7	2000X2400	0 2400
11	D8	1730X2100	0 2100
12	DW	2400X2400	0 2400
13	DV1	2025X4300	0 4300
14	DV2	1730X4300	0 4300
15	DV3	2380X3400	0 3400
16	DV3	2400X3400	0 3400
FIRE DOOR			
1	FCD	1730X2400	0 2400
2	FCD1	1500X2400	0 2400
WINDOW			
1	W	600X10500	900 11400
2	W	600X2500	900 3400
3	W1	1800X1500	900 2400
4	W1	843+843x1500	900 2400
5	W2	2000X1500	900 2400
6	W2	492+1393x1500	900 2400
7	W3	2100X1500	900 2400
8	W3	1168+817x1500	900 2400
9	W4	2400X1500	900 2400
10	W5	2290X1500	900 3400
11	W6	1300X2250	150 2400
12	W7	1450X2250	150 2400
13	W8	2030X2250	150 3400
14	W9	1730X4300	150 4450
15	W10	2000X1500	900 2400
16	W11	1730X13350	900 14250
VENTILATOR			
1	V	400X400	2630 3030
2	V	2000X750	3100 3850
3	V1	2100X750	3100 3850
4	V2	2100X900	2500 3400
5	V3	2100X1320	2080 3400
6	V4	2100X1720	1680 3400
7	V5	1800X2120	1280 3400
8	V5	1800X2120	1280 3400
9	V6	2000X2480	920 3400
10	V7	1800X750	3100 3850
11	V8	2100X300	3100 3400
12	V9	2290X300	3100 3400
13	V10	2400X300	3100 3400
14	V11	1090X300	3100 3400
ROLLING SHUTTER			
1	RS	3100X3400	0 3400
2	RS1	4000X2700	0 2700

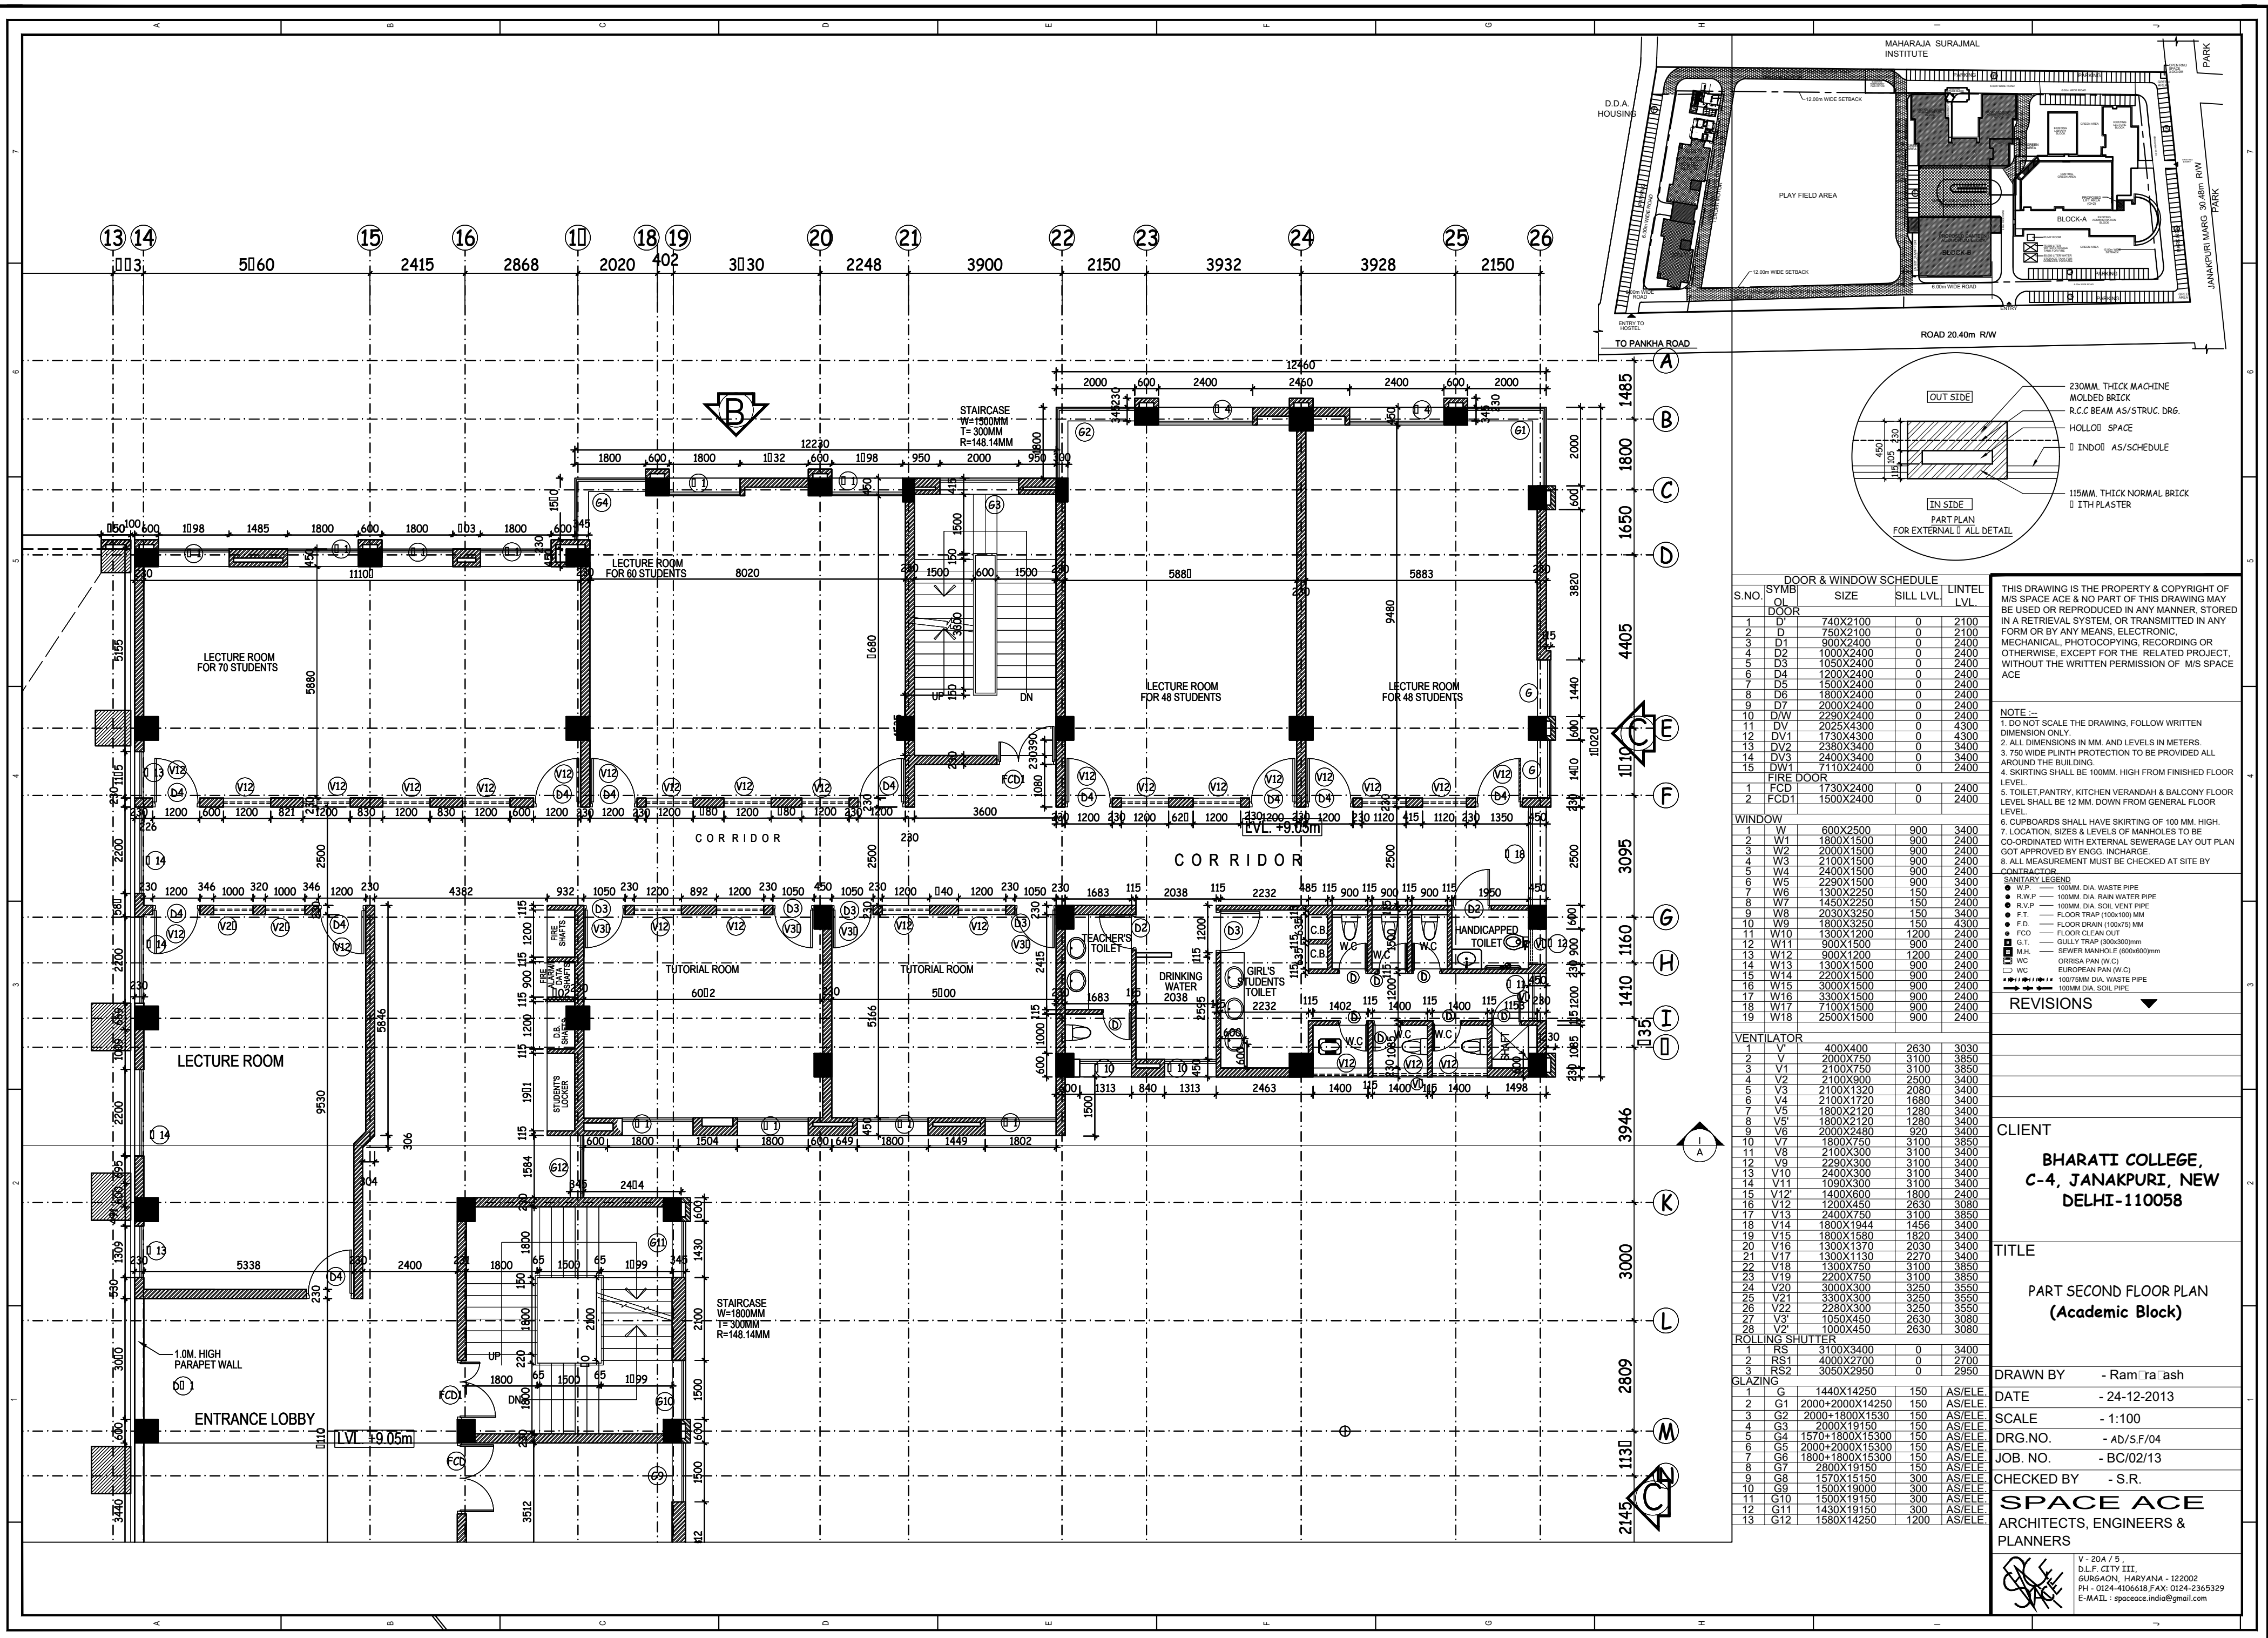

DOOR & WINDOW SCHEDULE				
S.NO.	SYMBOL	SIZE	SILL LVL.	LINTEL LVL.
1	D1	740X2100	0	2100
2	D2	750X2100	0	2100
3	D3	900X2400	0	2400
4	D4	1000X2400	0	2400
5	D5	1050X2400	0	2400
6	D6	1500X2400	0	2400
7	D7	1800X2400	0	2400
8	D8	2000X2400	0	2400
9	D9	2290X2400	0	2400
10	D10	2025X4300	0	4300
11	D11	1730X4300	0	4300
12	D12	2380X3400	0	3400
13	D13	2400X3400	0	3400
14	D14	7110X2400	0	2400
15	D15	1730X2400	0	2400
16	D16	1500X2400	0	2400

WINDOW			
S.NO.	SYMBOL	SIZE	LEVEL
1	W1	600X2500	900
2	W2	1800X1500	900
3	W3	2000X1500	900
4	W4	2100X1500	900
5	W5	2400X1500	900
6	W6	2290X1500	900
7	W7	1300X2250	150
8	W8	1450X2250	150
9	W9	2030X3250	150
10	W10	1800X3250	150
11	W11	1300X1200	1200
12	W12	900X1500	900
13	W13	900X1200	1200
14	W14	1300X1500	900
15	W15	2200X1500	900
16	W16	3000X1500	900
17	W17	3300X1500	900
18	W18	7100X1500	900
19	W19	2500X1500	900

VENTILATOR			
S.NO.	SYMBOL	SIZE	LEVEL
1	V1	400X400	2630
2	V2	2100X750	3100
3	V3	2100X750	3100
4	V4	2100X900	2500
5	V5	2100X1320	2080
6	V6	2100X1720	1680
7	V7	1800X1200	1280
8	V8	1800X1200	1280
9	V9	2000X2480	920
10	V10	1800X750	3100
11	V11	2100X300	3100
12	V12	2100X300	3100
13	V13	2400X300	3100
14	V14	1090X300	3100
15	V15	1400X600	1800
16	V16	1200X450	2630
17	V17	2400X750	3100
18	V18	1800X1944	1456
19	V19	1800X1580	1820
20	V20	1300X1370	2030
21	V21	1300X1130	2270
22	V22	1300X750	3100
23	V23	2200X750	3100
24	V24	3000X300	3250
25	V25	3300X300	3250
26	V26	2280X300	3250
27	V27	1050X450	2630
28	V28	1000X450	2630

ROLLING SHUTTER			
S.NO.	SYMBOL	SIZE	LEVEL
1	RS1	3100X3400	0
2	RS2	4000X2700	0
3	RS3	3050X2950	0

GLAZING			
S.NO.	SYMBOL	SIZE	LEVEL
1	G1	1440X14250	150
2	G2	2000+2000X14250	150
3	G3	2000+1800X1530	150
4	G4	2000X19150	150
5	G5	1570+1800X15300	150
6	G6	2000+2000X15300	150
7	G7	1800+1800X15300	150
8	G8	2800X19150	150
9	G9	1570X15150	300
10	G10	1500X19000	300
11	G11	1500X15150	300
12	G12	1430X19150	300
13	G13	1580X14250	1200

THIS DRAWING IS THE PROPERTY & COPYRIGHT OF M/S SPACE ACE & NO PART OF THIS DRAWING MAY BE USED OR REPRODUCED IN ANY MANNER, STORED IN A RETRIEVAL SYSTEM, OR TRANSMITTED IN ANY FORM OR BY ANY MEANS, ELECTRONIC, MECHANICAL, PHOTOCOPYING, RECORDING OR OTHERWISE, EXCEPT FOR THE RELATED PROJECT, WITHOUT THE WRITTEN PERMISSION OF M/S SPACE ACE

- NOTE :-
1. DO NOT SCALE THE DRAWING, FOLLOW WRITTEN DIMENSION ONLY
 2. ALL DIMENSIONS IN MM. AND LEVELS IN METERS.
 3. 750 WIDE PLINTH PROTECTION TO BE PROVIDED ALL AROUND THE BUILDING.
 4. SKIRTING SHALL BE 100MM. HIGH FROM FINISHED FLOOR LEVEL.
 5. TOILET, PANTRY, KITCHEN VERANDAH & BALCONY FLOOR LEVEL SHALL BE 12 MM. DOWN FROM GENERAL FLOOR LEVEL.
 6. CUPBOARDS SHALL HAVE SKIRTING OF 100 MM. HIGH.
 7. LOCATION, SIZES & LEVELS OF MANHOLES TO BE CO-ORDINATED WITH EXTERNAL SEWERAGE LAY OUT PLAN GOT APPROVED BY ENGG. INCHARGE.
 8. ALL MEASUREMENT MUST BE CHECKED AT SITE BY CONTRACTOR.

SANITARY LEGEND	
● W.P.	100MM DIA. WASTE PIPE
● R.V.P.	100MM DIA. RAIN WATER PIPE
● F.T.	100MM DIA. SOIL VENT PIPE
● F.D.	FLOOR DRAIN (100/75) MM
● F.C.O.	FLOOR CLEAN OUT
● G.T.	GULLY TRAP (300x300)mm
● M.H.	SEWER MANHOLE (600x600)mm
● W.C.	ORISSA PAN (W.C)
● W.C.	EUROPEAN PAN (W.C)
● W.P.	100/75MM DIA. WASTE PIPE
● W.P.	100MM DIA. SOIL PIPE

REVISIONS

CLIENT
**BHARATI COLLEGE,
C-4, JANAKPURI, NEW
DELHI-110058**

TITLE
**PART SECOND FLOOR PLAN
(Academic Block)**

DRAWN BY - Ramraash
DATE - 24-12-2013
SCALE - 1:100
DRG. NO. - AB/S.F/04
JOB. NO. - BC/02/13
CHECKED BY - S.R.

SPACE ACE
ARCHITECTS, ENGINEERS &
PLANNERS

V-20A/5,
D.L.F. CITY III,
GURGAON, HARYANA - 122002
PH - 0124-4106418, FAX: 0124-2365329
E-MAIL: spaceace.india@gmail.com

SCHEDULE OF DOORS & WINDOWS				
S.NO.	SYMBOL	SIZE	SILL LVL.	LINTEL LVL.
DOORS				
1	D	750X2100	0	2100
2	D'	750X2000	0	2000
3	D1	900X2400	0	2400
4	D2	1000X2400	0	2400
5	D3	1000X2400	0	2400
6	D4	1800X2400	0	2400
7	D4'	1800X2000	0	2000
8	D5	1500X2400	0	2400
9	DE	2400X2000	0	2000
10	DE1	2400X2400	0	2400
FIRE DOOR				
1	FCD	1200X2400	0	2400
2	FCD'	1200X2000	0	2000
WINDOWS				
1	W	1800X2100	300	2400
2	W'	1800X1700	300	2000
3	W1	1800X1500	900	2400
4	W2	1500X1500	900	2400
5	W3	1350X1500	900	2400
6	W4	2700X1500	900	2400
DOOR-WINDOW				
1	DW1	3000X2400	900	2400
VENTILATOR				
1	V	450X900	1500	2400
2	V1	400X400	2000	2400

THIS DRAWING IS THE PROPERTY & COPYRIGHT OF M/S SPACE ACE & NO PART OF THIS DRAWING MAY BE USED OR REPRODUCED IN ANY MANNER, STORED IN A RETRIEVAL SYSTEM, OR TRANSMITTED IN ANY FORM OR BY ANY MEANS, ELECTRONIC, MECHANICAL, PHOTOCOPYING, RECORDING OR OTHERWISE, EXCEPT FOR THE RELATED PROJECT, WITHOUT THE WRITTEN PERMISSION OF M/S SPACE ACE

SANITARY LEGEND	
	100 DIA. WASTE WATER PIPE (W.P.)
	100 DIA. RAIN WATER PIPE (R.W.P.)
	100 DIA. SOIL PIPE/SOIL VENT PIPE (S.V.P.)
	G.T. 300X300 GULLY TRAP
	M.H. MAN HOLE
	WASTE PIPE 100 DIA.
	SOIL PIPE 100 DIA.
	ORRISA PAN (W.C.)
	EUROPEAN W.C. PAN

NOTE :-
1. DO NOT SCALE THE DRAWING, FOLLOW WRITTEN DIMENSION ONLY.
2. ALL DIMENSIONS IN MM. AND LEVELS IN METERS.
3. 750 WIDE PLINTH PROTECTION TO BE PROVIDED ALL AROUND THE BUILDING.
4. SKIRTING SHALL BE 100MM. HIGH FROM FINISHED FLOOR LEVEL.
5. TOILET/PANTRY, KITCHEN VERANDAH & BALCONY FLOOR LEVEL SHALL BE 12 MM. DOWN FROM GENERAL FLOOR LEVEL.
6. CUPBOARDS SHALL HAVE SKIRTING OF 100 MM. HIGH.
7. LOCATION, SIZES & LEVELS OF MANHOLES TO BE CO-ORDINATED WITH EXTERNAL SEWERAGE LAY OUT PLAN GOT APPROVED BY ENGG. INCHARGE.
8. ALL MEASUREMENT MUST BE CHECKED AT SITE BY CONTRACTOR.


REVISIONS	
R1	12-02-2014
R2	20-02-2014


DRAWN BY	- RUBY
DATE	- 29-08-2013
SCALE	- 1:50
DRG.NO.	- GH/Te.F/06
JOB. NO.	- BH.C/JNK/13
CHECKED BY	- RAMPRAKASH

TITLE	PART TERRACE FLOOR PLAN GIRLS HOSTEL BLOCK
-------	---



CLIENT	BHARATI COLLEGE
--------	-----------------

SPACE ACE ARCHITECTS, ENGINEERS & PLANNERS	V - 20A / 5, D.L.F. CITY III, GURGAON, HARYANA - 122002 PH - 0124-4106618, FAX: 0124-2365329 E-MAIL : spaceace.india@gmail.com
--	--

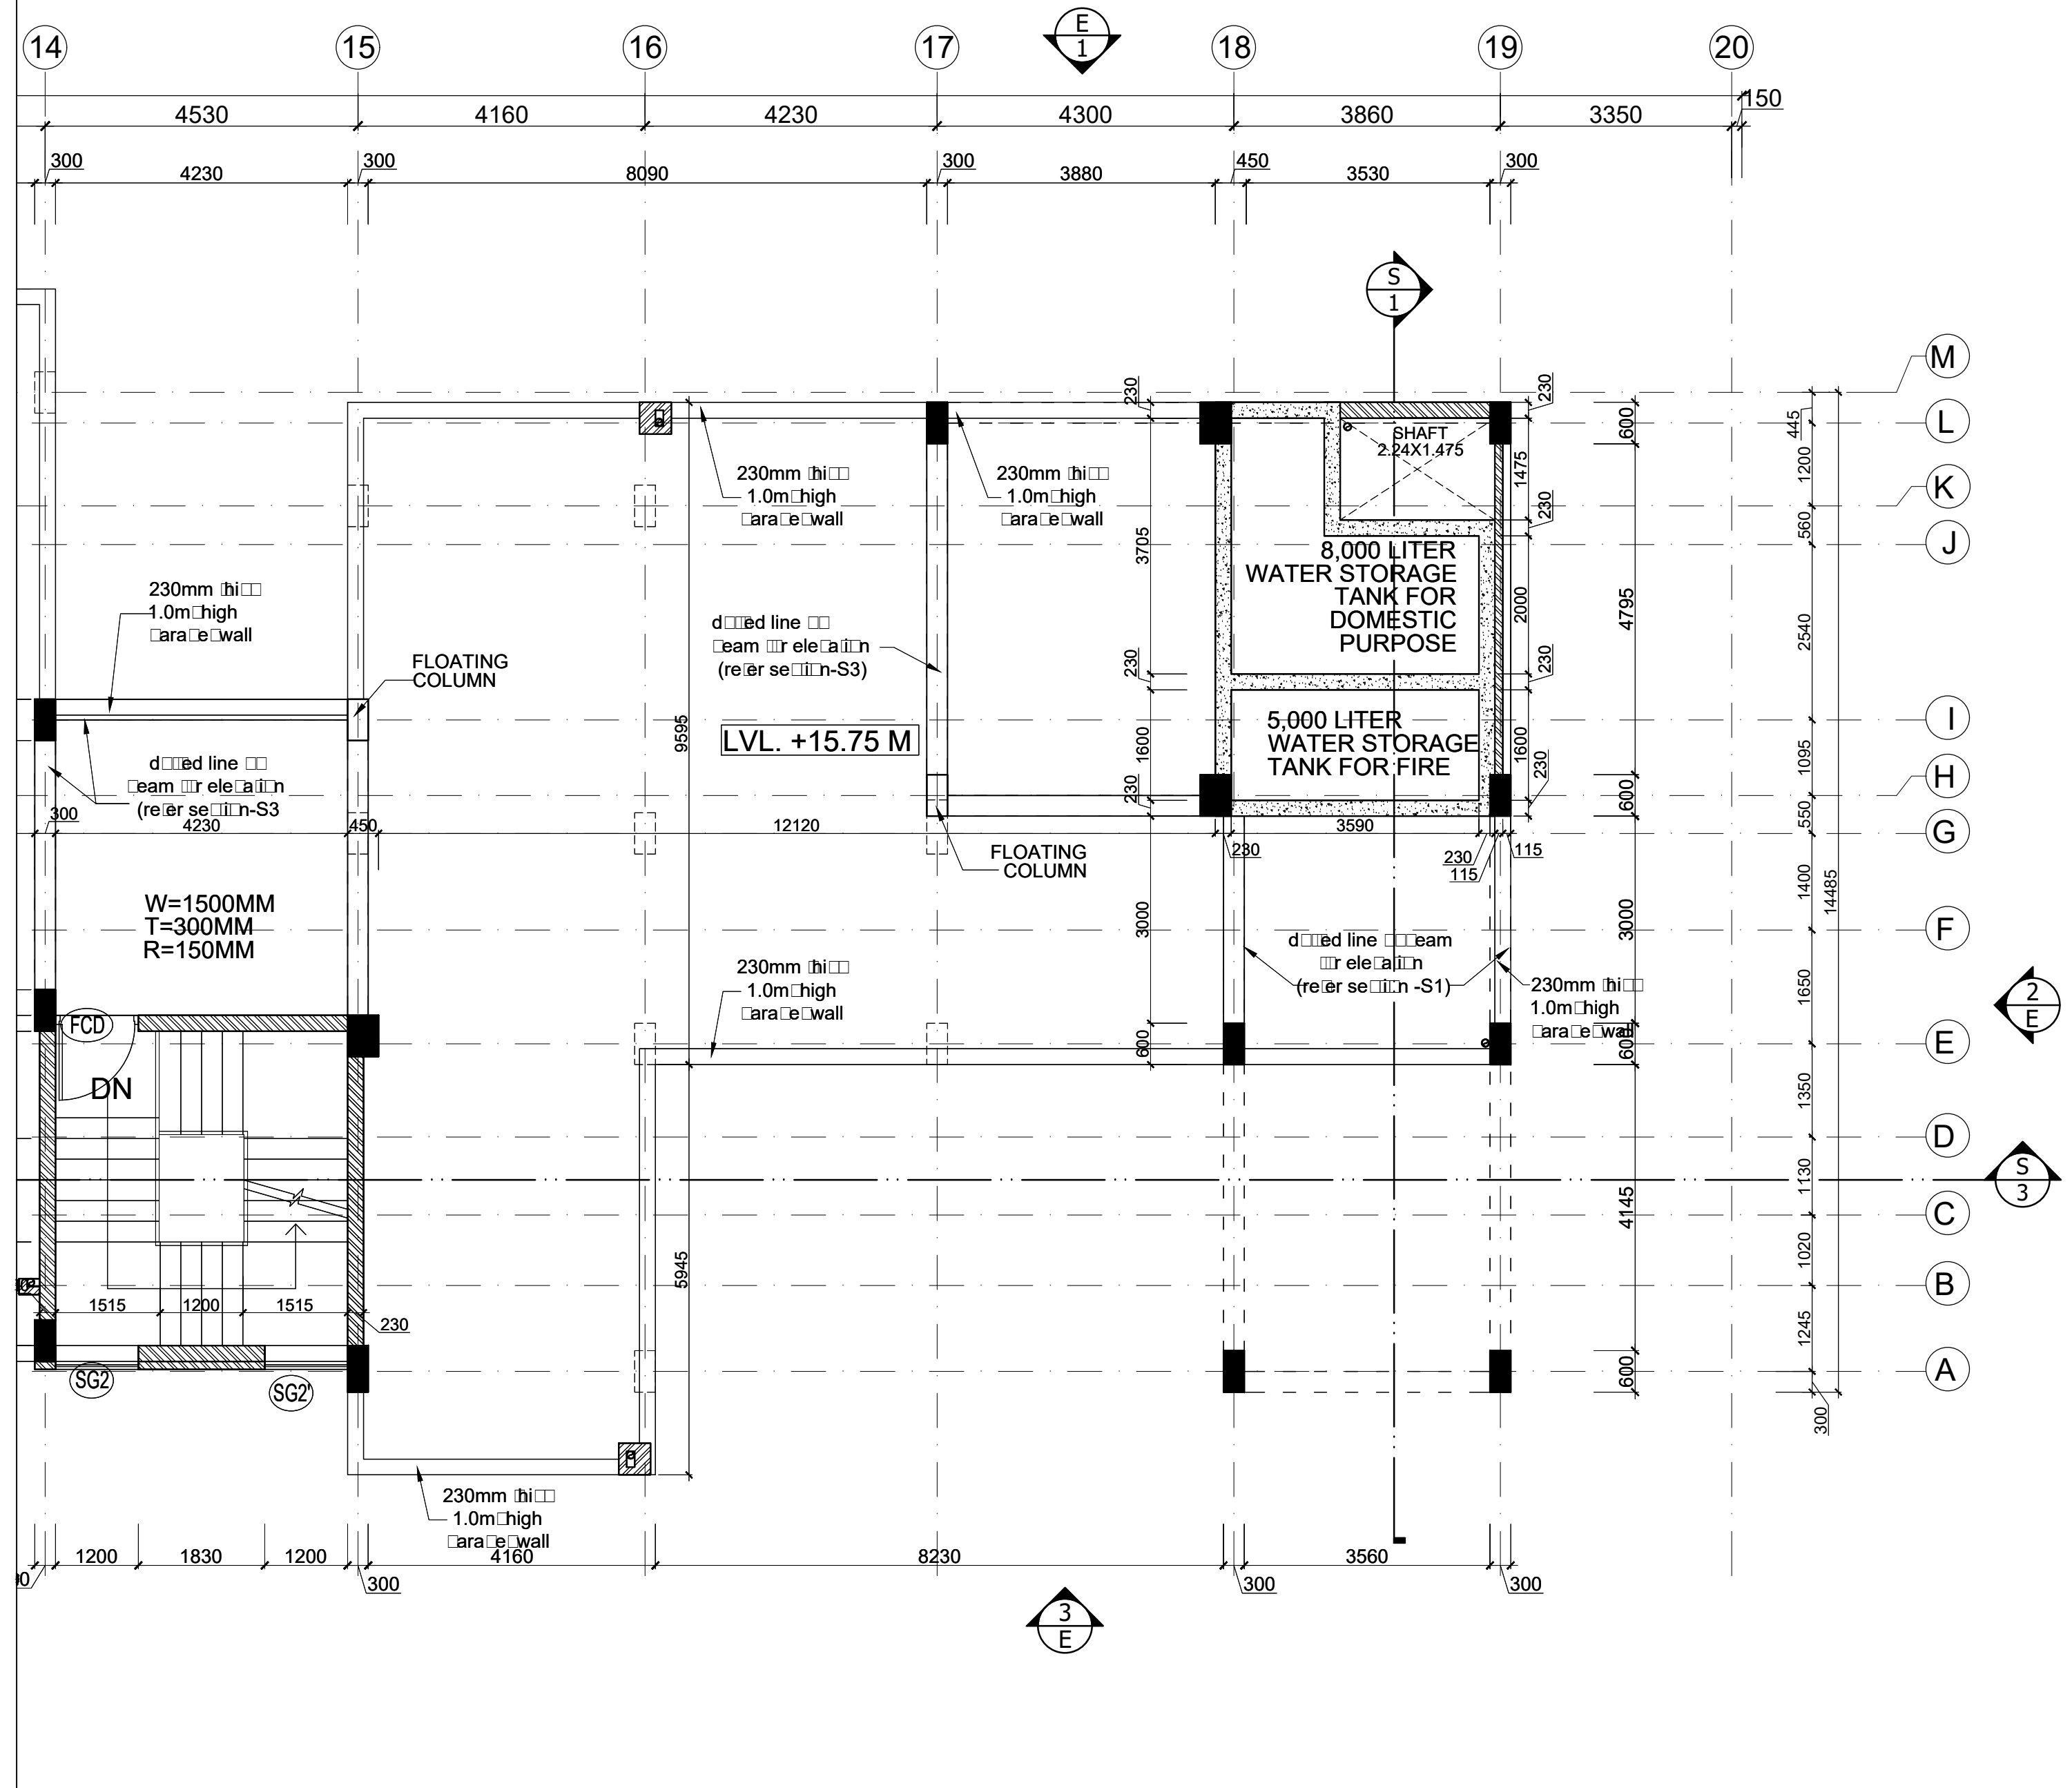

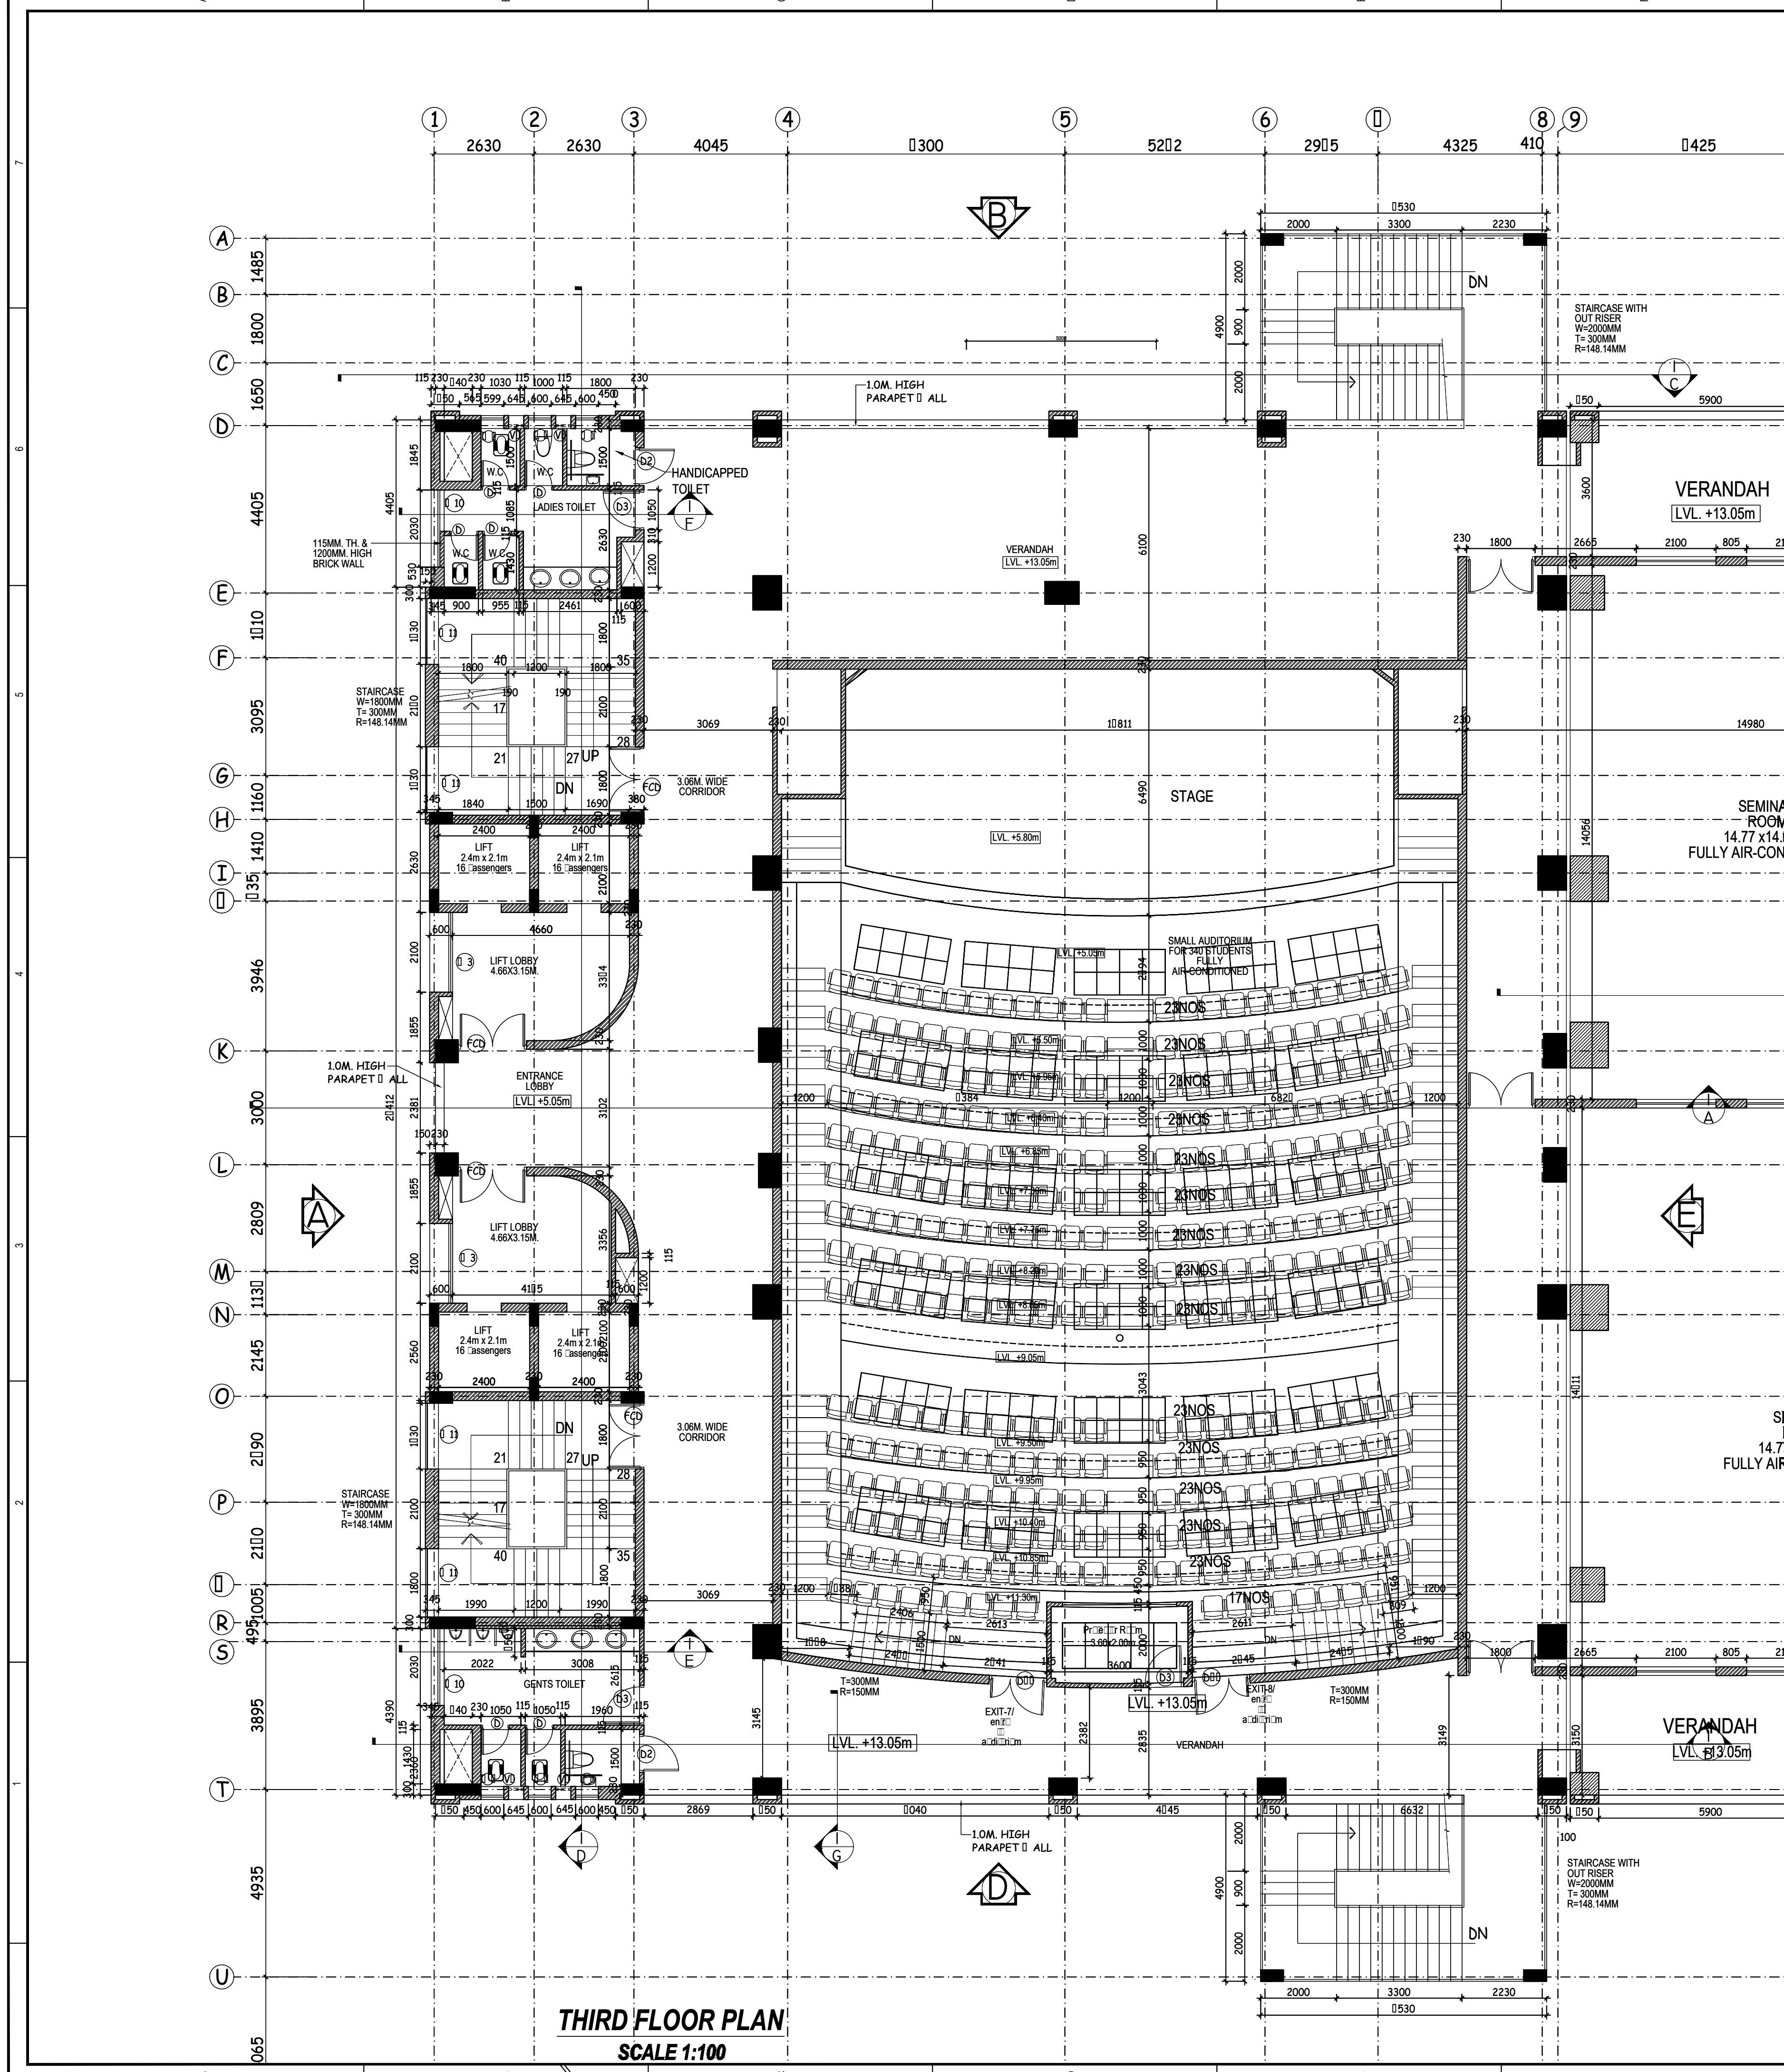

THIRD FLOOR PLAN
SCALE 1:100

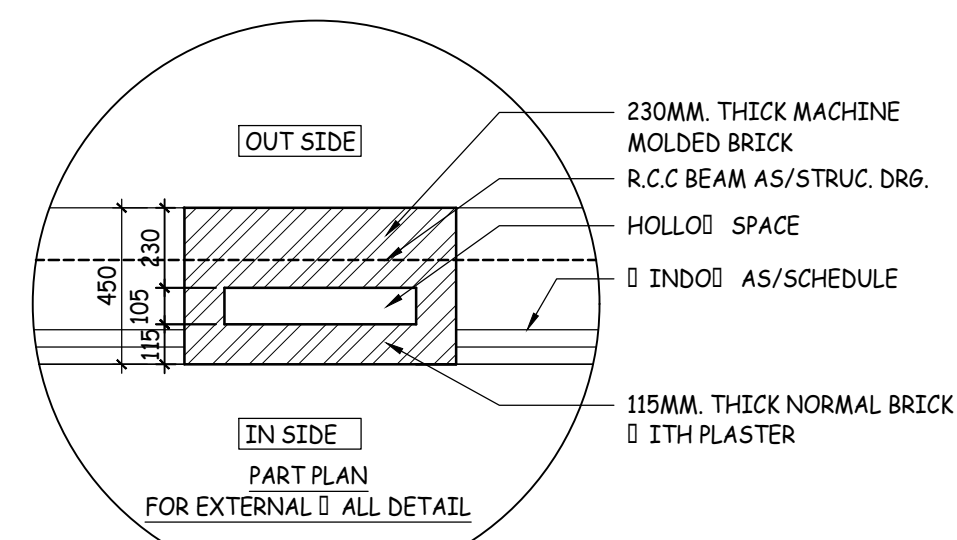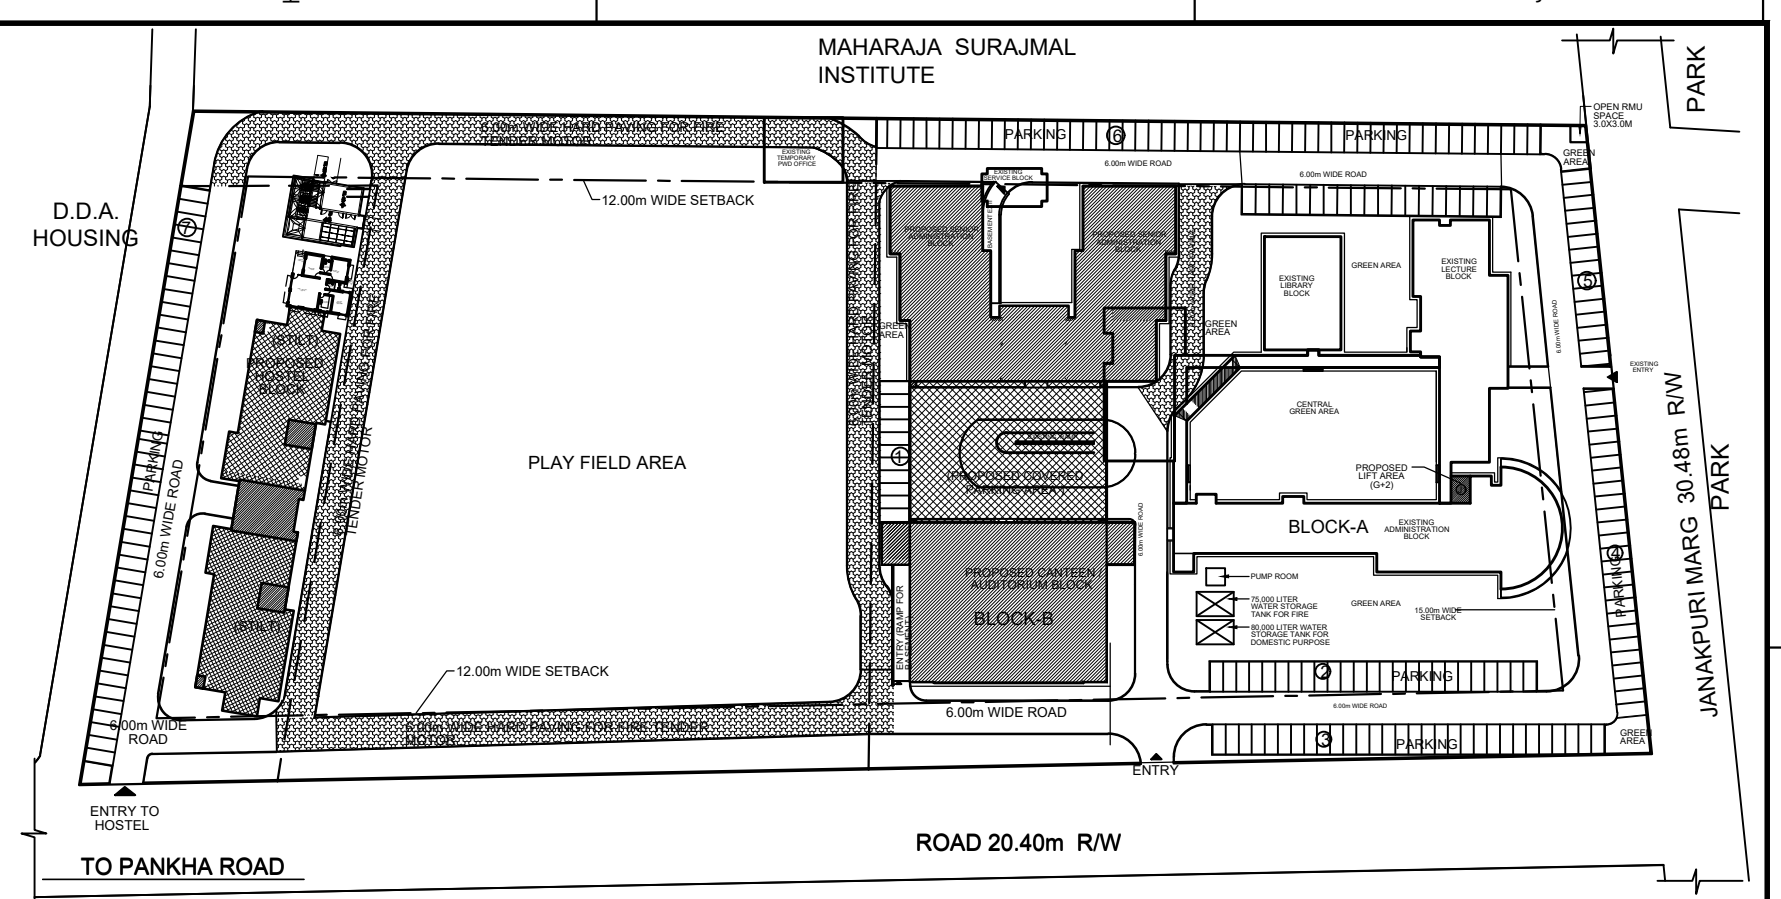

THIS DRAWING IS THE PROPERTY & COPYRIGHT OF M/S SPACE ACE & NO PART OF THIS DRAWING MAY BE USED OR REPRODUCED IN ANY MANNER, STORED IN A RETRIEVAL SYSTEM, OR TRANSMITTED IN ANY FORM OR BY ANY MEANS, ELECTRONIC, MECHANICAL, PHOTOCOPYING, RECORDING OR OTHERWISE, EXCEPT FOR THE RELATED PROJECT, WITHOUT THE WRITTEN PERMISSION OF M/S SPACE ACE

- NOTE :-
1. DO NOT SCALE THE DRAWING, FOLLOW WRITTEN DIMENSION ONLY.
 2. ALL DIMENSIONS IN MM. AND LEVELS IN METERS.
 3. 750 WIDE PLINTH PROTECTION TO BE PROVIDED ALL AROUND THE BUILDING.
 4. SKIRTING SHALL BE 100MM. HIGH FROM FINISHED FLOOR LEVEL.
 5. TOILET, PANTRY, KITCHEN VERANDAH & BALCONY FLOOR LEVEL SHALL BE 12 MM. DOWN FROM GENERAL FLOOR LEVEL.
 6. CUPBOARDS SHALL HAVE SKIRTING OF 100 MM. HIGH.
 7. LOCATION, SIZES & LEVELS OF MANHOLES TO BE CO-ORDINATED WITH EXTERNAL SEWERAGE LAY OUT PLAN GOT APPROVED BY ENGG. INCHARGE.
 8. ALL MEASUREMENT MUST BE CHECKED AT SITE BY CONTRACTOR.

SANITARY LEGEND

● R.W.P.	100MM. DIA. WASTE PIPE
● R.W.P.	100MM. DIA. RAIN WATER PIPE
● R.V.P.	100MM. DIA. SOIL VENT PIPE
● F.T.	FLOOR TRAP (100x100) MM
● F.D.	FLOOR DRAIN (100x75) MM
● F.C.O.	FLOOR CLEAN OUT
● G.T.	GULLY TRAP (300x300)mm
● M.H.	SEWER MANHOLE (600x600)mm
● WC	ORRISA PAN (W.C)
● WC	EUROPEAN PAN (W.C)
●	100/75MM DIA. WASTE PIPE
●	100MM DIA. SOIL PIPE

REVISIONS

CLIENT
**BHARATI COLLEGE,
C-4, JANAKPURI, NEW
DELHI-110058**



TITLE
**THIRD FLOOR PLAN
(AUDITORIUM BLOCK)**

DRAWN BY - Ramprakash
DATE - 24-12-2013
SCALE - 1:100
DRG.NO. - AUDI./TH.F/05
JOB. NO. - BC/02/13
CHECKED BY - S.R.

SPACE ACE
ARCHITECTS, ENGINEERS &
PLANNERS

V-20A/5,
D.L.F. CITY III,
GURGAON, HARYANA - 122002
PH - 0124-4106618, FAX: 0124-2365329
E-MAIL : spaceace.india@gmail.com

DOOR & WINDOW SCHEDULE			
S.NO.	SYMBOL	SIZE	SILL LVL. LINTEL LVL.
DOOR			
1	D	740X2100	0 2100
2	D	750X2100	0 2100
3	D1	900X2400	0 2400
4	D2	1000X2400	0 2400
5	D3	1070X2400	0 2400
6	D4	1200X2400	0 2400
7	D5	1500X2400	0 2400
8	D6	1800X2400	0 2400
9	D7	2000X2400	0 2400
10	D8	1730X2100	0 2100
11	DW	2400X2400	0 2400
12	DV	2025X4300	0 4300
13	DV1	1730X4300	0 4300
14	DV2	2380X3400	0 3400
15	DV3	2400X3400	0 3400
FIRE DOOR			
1	FCD	1730X2400	0 2400
2	FCD1	1500X2400	0 2400
WINDOW			
1	W	600X10500	900 11400
2	W	600X2500	900 3400
3	W1	1800X1500	900 2400
4	W1	843+843x1500	900 2400
5	W2	2000X1500	900 2400
6	W2	492+1393x1500	900 2400
7	W3	2100X1500	900 2400
8	W3	1168+817x1500	900 2400
9	W4	2400X1500	900 2400
10	W5	2290X1500	900 3400
11	W6	1300X2250	150 2400
12	W7	1450X2250	150 2400
13	W8	2030X3250	150 3400
14	W9	1730X4300	150 4450
15	W10	2000X1500	900 2400
16	W11	1730X13350	900 14250
VENTILATOR			
1	V	400X400	2630 3030
2	V	2000X750	3100 3850
3	V1	2100X750	3100 3850
4	V2	2100X900	2500 3400
5	V3	2100X1320	2080 3400
6	V4	2100X1720	1680 3400
7	V5	1800X2120	1280 3400
8	V5	1800X2120	1280 3400
9	V6	2000X2480	920 3400
10	V7	1800X750	3100 3850
11	V8	2100X300	3100 3400
12	V9	2290X300	3100 3400
13	V10	2400X300	3100 3400
14	V11	1090X300	3100 3400
ROLLING SHUTTER			
1	RS	3100X3400	0 3400
2	RS1	4000X2700	0 2700

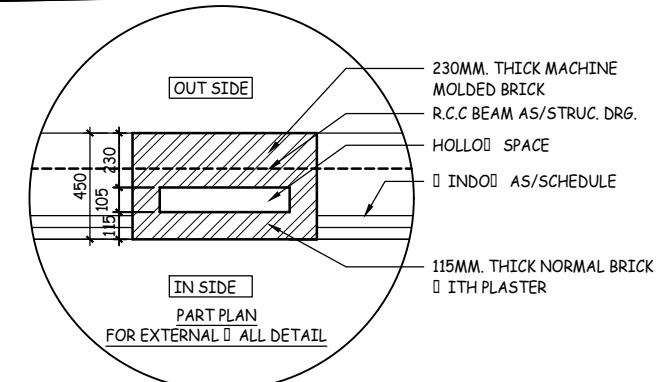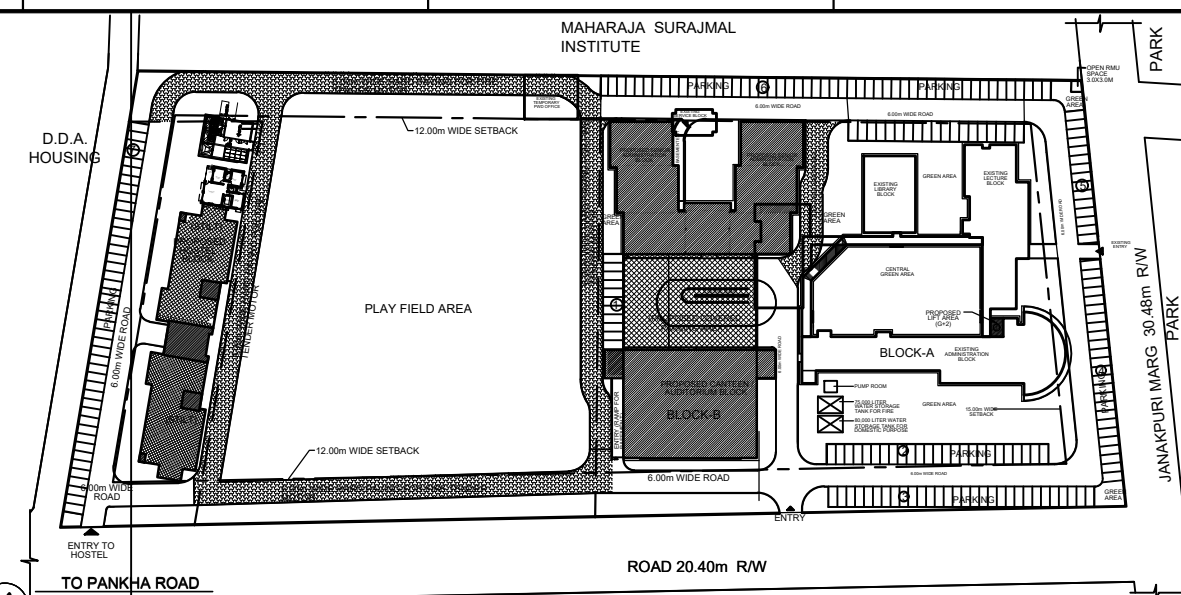

DOOR & WINDOW SCHEDULE				
S.NO.	SYMBOL OF DOOR	SIZE	SILL LVL.	LINTEL LVL.
1	D	740X2100	0	2100
2	D	750X2100	0	2100
3	D1	900X2400	0	2400
4	D2	1000X2400	0	2400
5	D3	1050X2400	0	2400
6	D5	1200X2400	0	2400
7	D5	1500X2400	0	2400
8	D6	1800X2400	0	2400
9	D7	2000X2400	0	2400
10	D/W	2230X2400	0	2400
11	D/W	2115X2400	0	2400
12	DV1	1730X4300	0	3300
13	DV2	2380X4300	0	3400
14	DV3	2400X3400	0	3400
15	DW1	1110X2400	0	2400
FIRE DOOR				
1	FCD	1730X2400	0	2400
2	FCD1	1500X2400	0	2400

WINDOW			
1	W	600X2500	900 3400
2	W1	1800X1500	900 2400
3	W2	2000X1500	900 2400
4	W3	2100X1500	900 2400
5	W4	2400X1500	900 2400
6	W5	2290X1500	900 2400
7	W6	1300X2250	150 2400
8	W7	1450X2250	150 2400
9	W8	2030X3250	150 4300
10	W9	1800X3250	150 4300
11	W10	1300X1200	1200 2400
12	W11	900X1500	900 2400
13	W12	900X1500	1200 2400
14	W13	1300X1500	900 2400
15	W14	2200X1500	900 2400
16	W15	3000X1500	900 2400
17	W16	3300X1500	900 2400
18	W17	2400X1500	900 2400
19	W18	2500X1500	900 2400

VENTILATOR			
1	V	400X400	2630 3030
2	V	2000X750	3100 3850
3	V1	2100X750	3100 3850
4	V2	2100X900	2500 3400
5	V3	2100X1320	2080 3400
6	V4	2100X1320	1680 3400
7	V5	1800X2120	1280 3400
8	V5'	1800X2120	1280 3400
9	V6	2000X2480	920 3400
10	V7	1800X750	3100 3850
11	V8	1100X750	3100 3400
12	V9	2290X300	3100 3400
13	V10	2400X300	3100 3400
14	V11	1090X300	3100 3400
15	V12'	1400X600	1800 2400
16	V12	2000X450	2630 3080
17	V13	2400X600	3100 3850
18	V14	1800X1944	1456 3400
19	V15	1800X1580	1820 3400
20	V16	3300X1370	2030 3400
21	V17	1300X1130	2270 3400
22	V18	1300X750	3100 3850
23	V19	2200X750	3100 3850
24	V20	3000X300	3250 3550
25	V21	3300X300	3250 3550
26	V22	2280X300	3250 3550
27	V23	3000X600	2630 3080
28	V2'	1000X450	2630 3080

ROLLING SHUTTER			
1	RS	3100X3400	0 3400
2	RS1	4000X2700	0 2700
3	RS2	3050X2950	0 2950
GLAZING			
1	G	1440X14250	150 AS/E/LE
2	G1	2000X200014250	150 AS/E/LE
3	G2	2000X18001530	150 AS/E/LE
4	G3	2000X1910	150 AS/E/LE
5	G4	1570X1800X15300	150 AS/E/LE
6	G5	2000X2000X15300	150 AS/E/LE
7	G6	1800X1800X15300	150 AS/E/LE
8	G7	2000X15150	150 AS/E/LE
9	G8	1570X15150	300 AS/E/LE
10	G9	1500X19000	300 AS/E/LE
11	G10	1500X19150	300 AS/E/LE
12	G11	1800X15150	300 AS/E/LE
13	G12	1800X14250	1200 AS/E/LE

THIS DRAWING IS THE PROPERTY & COPYRIGHT OF
M/S SPACE ACE & NO PART OF THIS DRAWING MAY
BE USED OR REPRODUCED IN ANY MANNER, STORED
IN A RETRIEVAL SYSTEM, OR TRANSMITTED IN ANY
FORM OR BY ANY MEANS, ELECTRONIC,
MECHANICAL, PHOTOCOPYING, RECORDING OR
OTHERWISE, EXCEPT FOR THE RELATED PROJECT,
WITHOUT THE WRITTEN PERMISSION OF M/S SPACE
ACE

NOTE :-

1. DO NOT SCALE THE DRAWING, FOLLOW WRITTEN DIMENSION ONLY.
2. ALL DIMENSIONS IN MM. AND LEVELS IN METERS.
3. 750 WIDE WALKING PROTECTION TO BE PROVIDED ALL AROUND THE BUILDING.
4. SKIRTING SHALL BE 100MM. HIGH FROM FINISHED FLOOR LEVEL.
5. TOILET/PANTRY, KITCHEN VERANDAH & BALCONY FLOOR LEVEL SHALL BE 12 MM. DOWN FROM GENERAL FLOOR LEVEL.
6. CUPBOARDS SHALL HAVE SKIRTING OF 100 MM. HIGH.
7. LOCATION, SIZES & LEVELS OF MANHOLES TO BE DETERMINED BY THE LOCAL AUTHORITY.
8. LAYOUT WITH EXTERNAL SEWERAGE LAY OUT PLAN GOT APPROVED BY ENG'G. INCHARGE.
9. ALL MEASUREMENT MUST BE CHECKED AT SITE BY CONTRACTOR.

SANITARY LEGEND

●	W.P.	100MM DIA. WASTE PIPE
●	R.V.P.	100MM DIA. RAIN WATER PIPE
●	R.V.P.	100MM DIA. VENT PIPE
●	F.T.	FLOOR TRAP (100x100) MM
●	F.D.	FLOOR DRAIN (100x75) MM
●	FCO	FLOOR CLEAN OUT
●	G.U.T	GULLY TRAP (300x300)mm
●	M.H.	SEWER MANHOLE (600x600)mm
●	WC	ORISSA PAN (W.C)
●	WC	EUROPEAN PAN (W.C)
●	100/150	100/150MM DIA. WASTE PIPE
●	100/150	100/150MM DIA. SOIL PIPE

REVISIONS

CLIENT


**BHARATI COLLEGE,
C-4, JANAKPURI, NEW
DELHI-110058**

TITLE



PART THIRD FLOOR PLAN
(Academic Block)
FOLLOW FOR ALL FLOORS

DRAWN BY	- Ram Prakash
DATE	- 24-12-2013
SCALE	- 1:100
DRG.NO.	- AD/TH.F/05
JOB. NO.	- BC/02/13
CHECKED BY	- S.R.
SPACE ACE ARCHITECTS, ENGINEERS & PLANNERS	

 V - 20A / 5,
D.L.F. CITY III,
GURGAON, HARYANA - 122002
PH - 0124-4106618, FAX: 0124-2365329
E-MAIL : spaceage.india@gmail.com

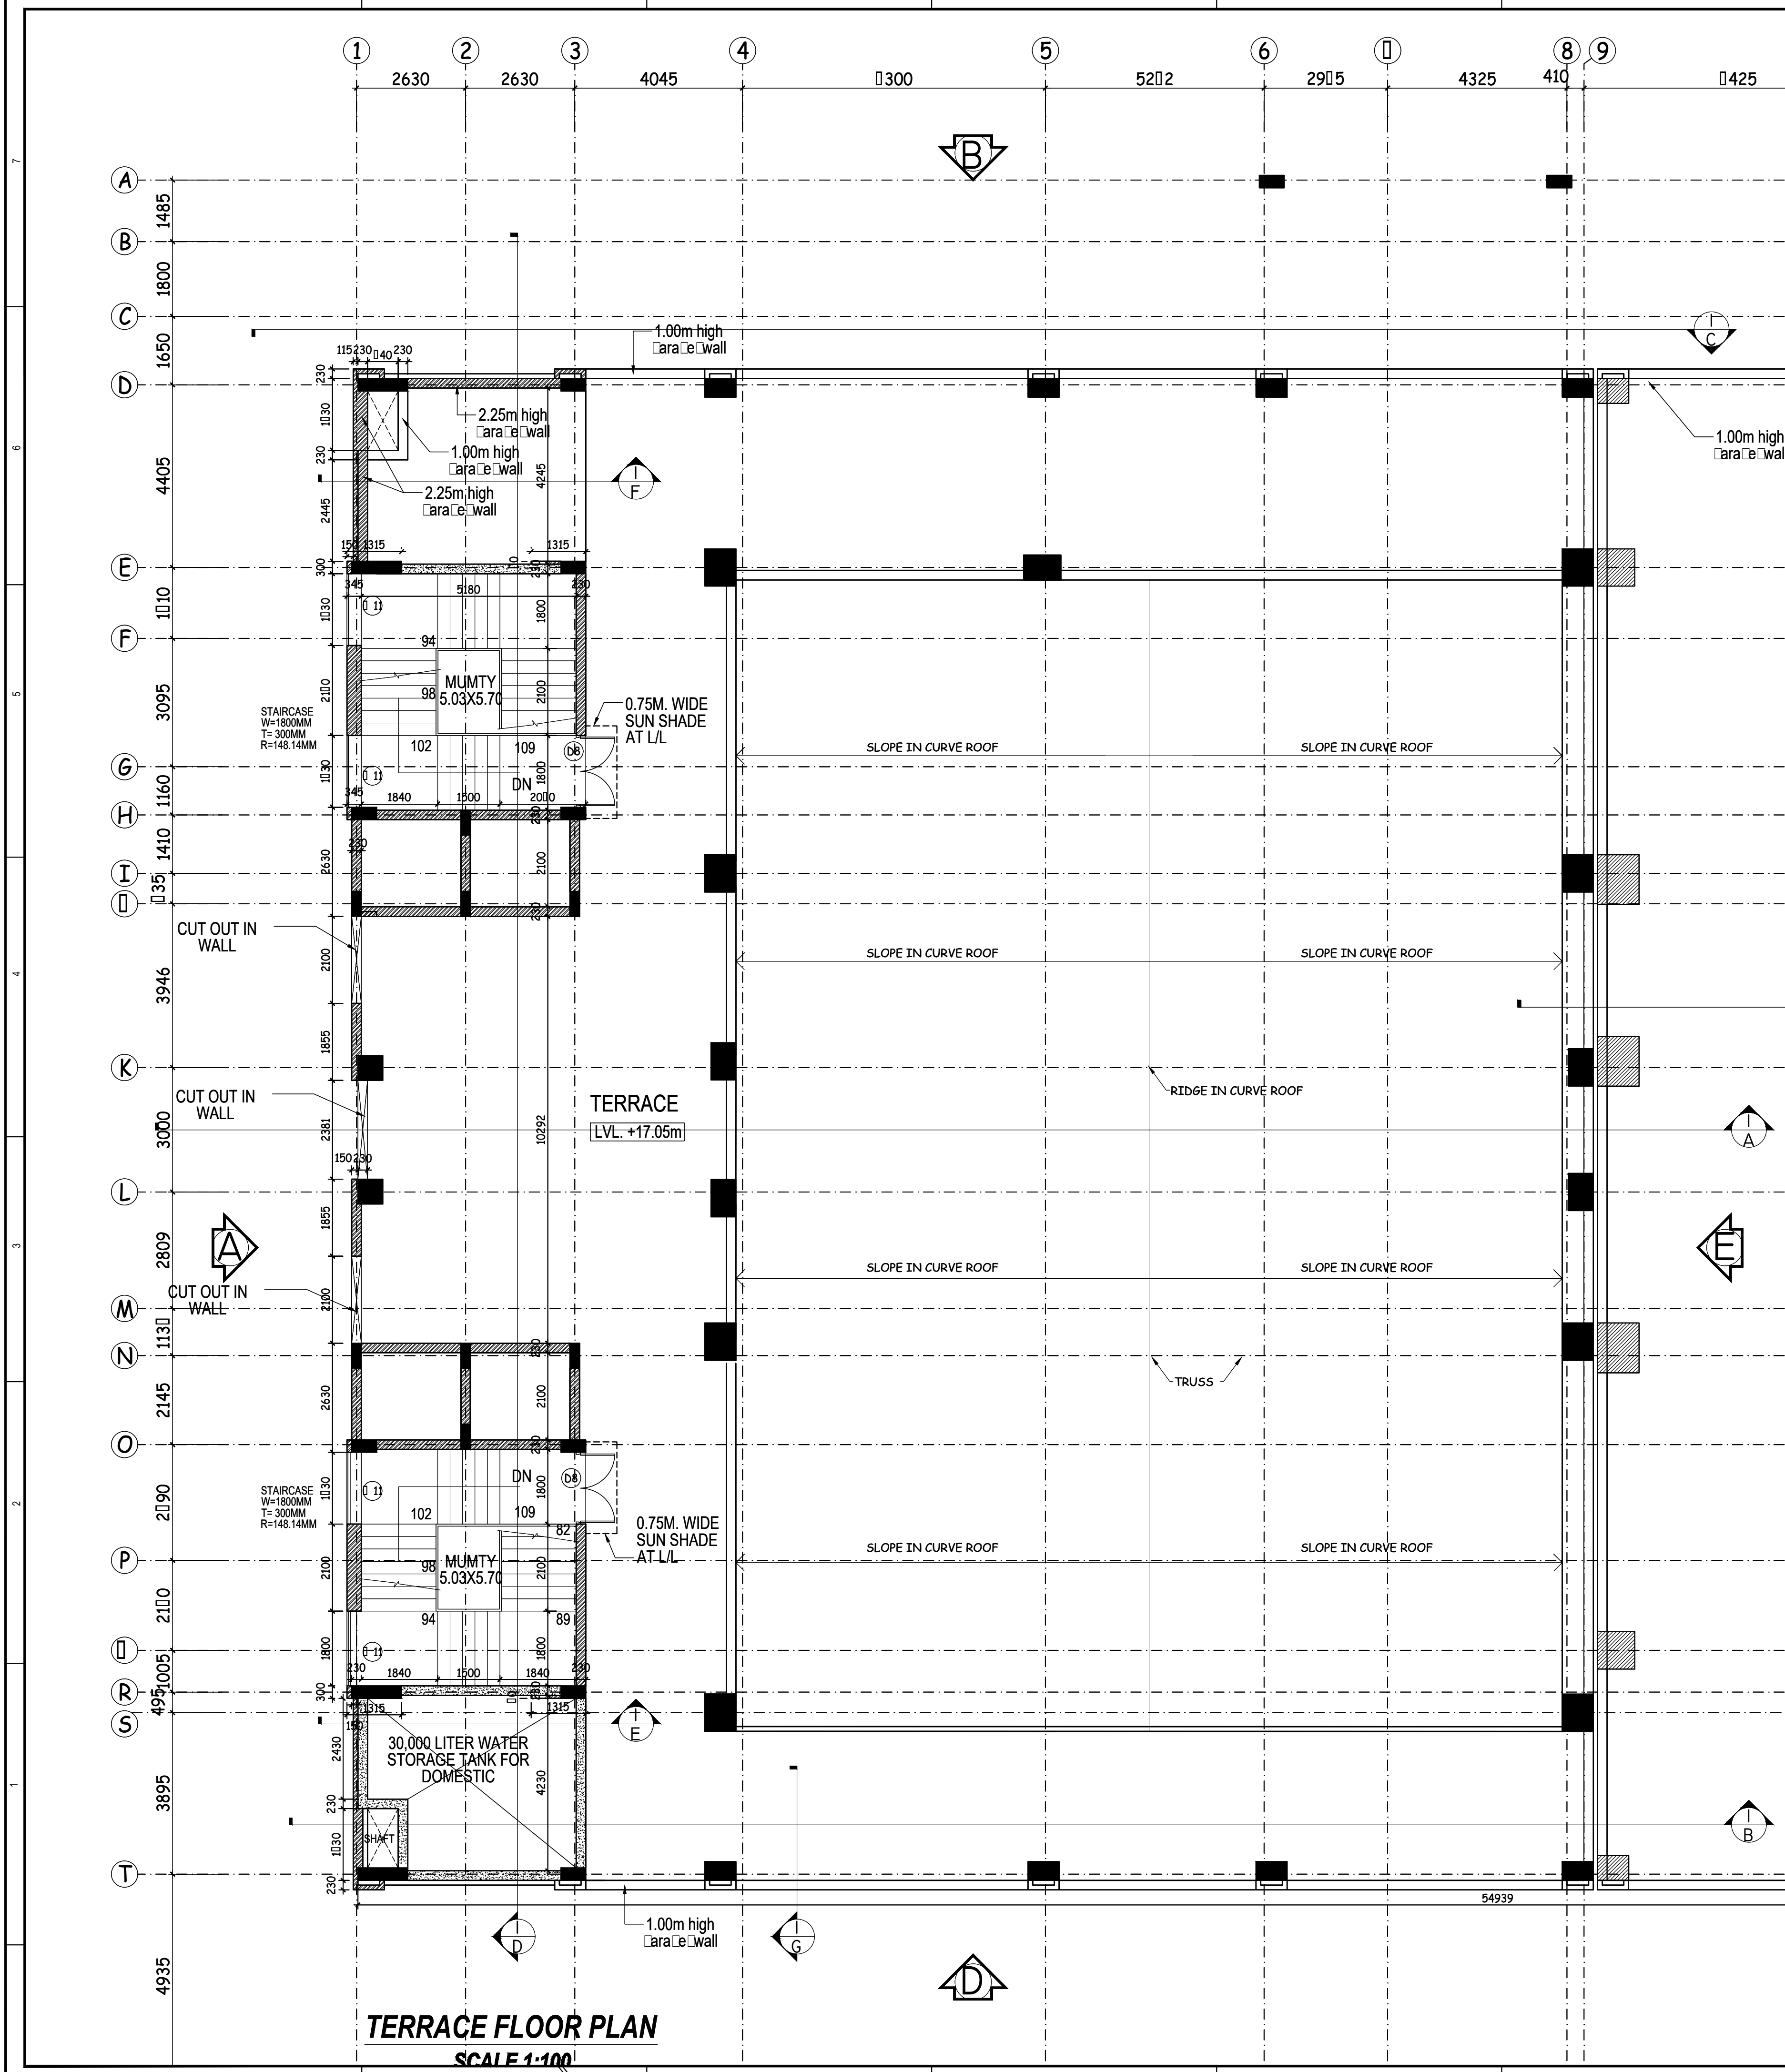

TERRACE FLOOR PLAN
SCALE 1:100

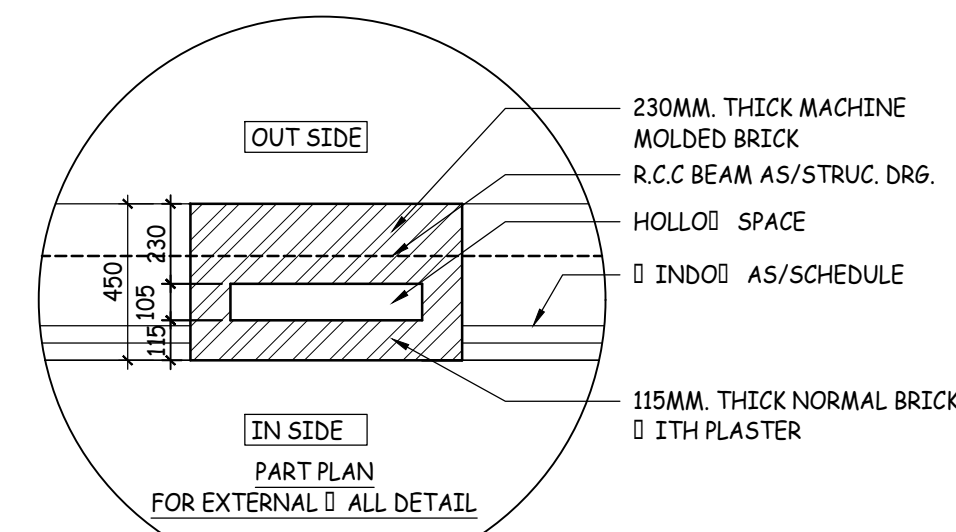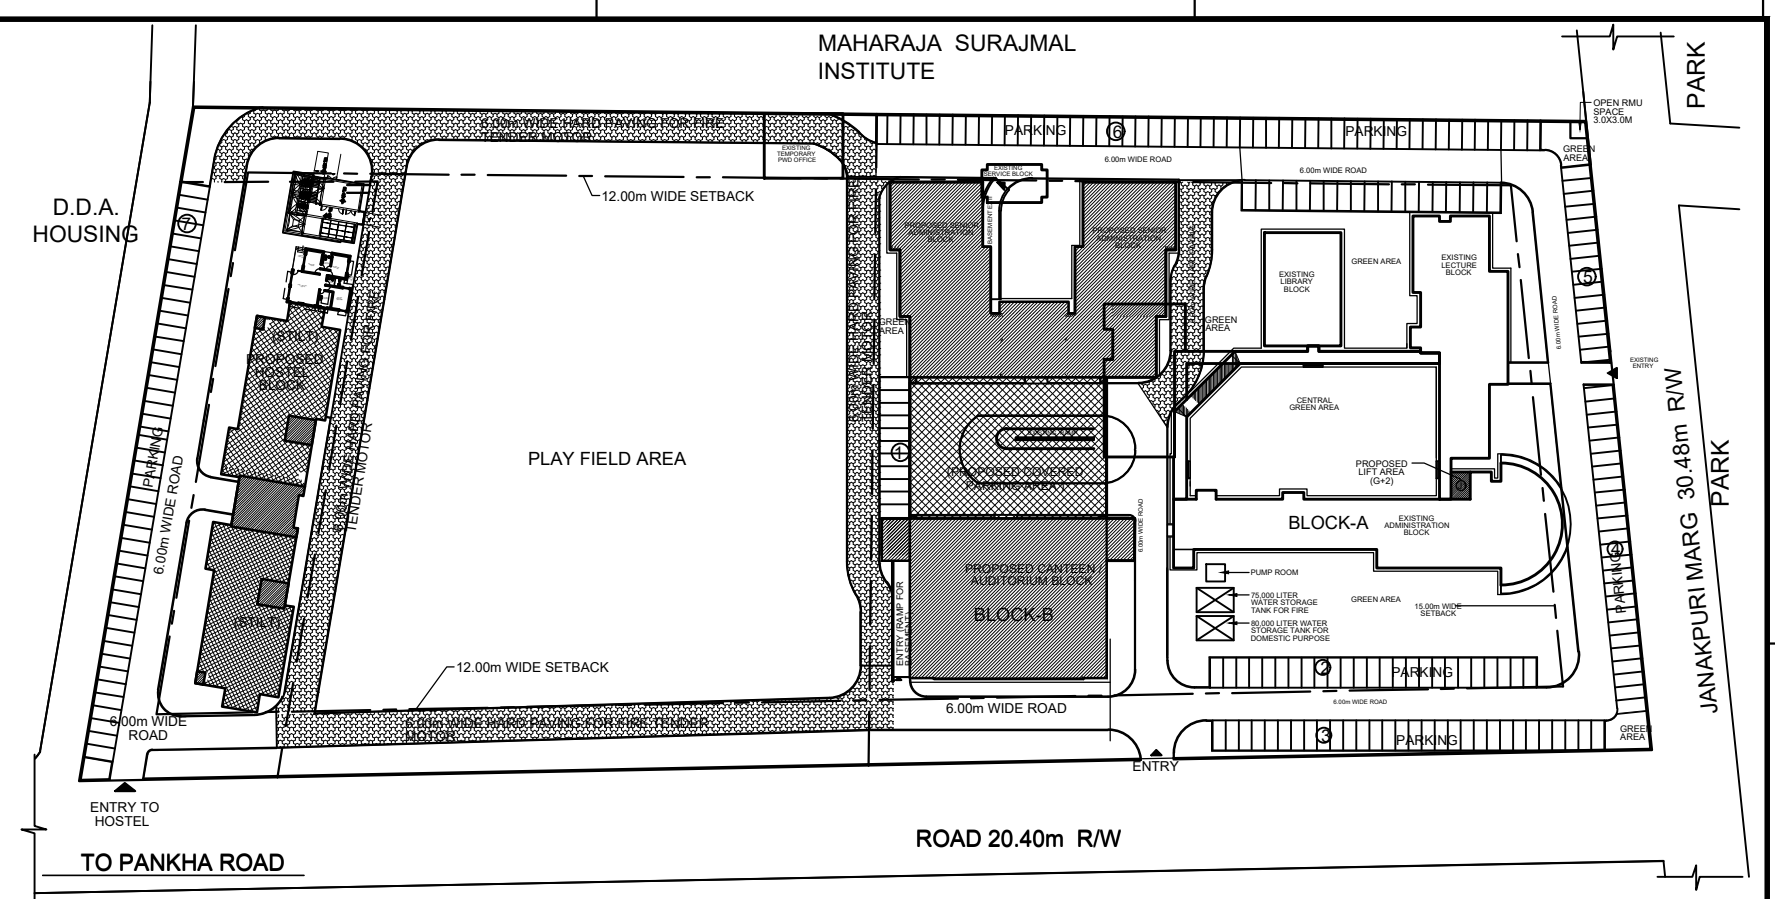

THIS DRAWING IS THE PROPERTY & COPYRIGHT OF M/S SPACE ACE & NO PART OF THIS DRAWING MAY BE USED OR REPRODUCED IN ANY MANNER, STORED IN A RETRIEVAL SYSTEM, OR TRANSMITTED IN ANY FORM OR BY ANY MEANS, ELECTRONIC, MECHANICAL, PHOTOCOPYING, RECORDING OR OTHERWISE, EXCEPT FOR THE RELATED PROJECT, WITHOUT THE WRITTEN PERMISSION OF M/S SPACE ACE

- NOTE :-
1. DO NOT SCALE THE DRAWING, FOLLOW WRITTEN DIMENSION ONLY.
 2. ALL DIMENSIONS IN MM. AND LEVELS IN METERS.
 3. 750 WIDE PLINTH PROTECTION TO BE PROVIDED ALL AROUND THE BUILDING.
 4. SKIRTING SHALL BE 100MM. HIGH FROM FINISHED FLOOR LEVEL.
 5. TOILET, PANTRY, KITCHEN VERANDAH & BALCONY FLOOR LEVEL SHALL BE 12 MM. DOWN FROM GENERAL FLOOR LEVEL.
 6. CUPBOARDS SHALL HAVE SKIRTING OF 100 MM. HIGH.
 7. LOCATION, SIZES & LEVELS OF MANHOLES TO BE CO-ORDINATED WITH EXTERNAL SEWERAGE LAY OUT PLAN GOT APPROVED BY ENGG. INCHARGE.
 8. ALL MEASUREMENT MUST BE CHECKED AT SITE BY CONTRACTOR.

SANITARY LEGEND

W.P.	100MM. DIA. WASTE PIPE
R.W.P.	100MM. DIA. RAIN WATER PIPE
R.V.P.	100MM. DIA. SOIL VENT PIPE
F.T.	FLOOR TRAP (100x100) MM
F.D.	FLOOR DRAIN (100x75) MM
F.C.O.	FLOOR CLEAN OUT
G.T.	GULLY TRAP (300x300)mm
M.H.	SEWER MANHOLE (600x600)mm
WC	ORISSA PAN (W.C)
WC	EUROPEAN PAN (W.C)
100/75MM DIA. WASTE PIPE	
100MM DIA. SOIL PIPE	

REVISIONS

CLIENT
**BHARATI COLLEGE,
C-4, JANAKPURI, NEW
DELHI-110058**


TITLE
**TERRACE FLOOR PLAN
(AUDITORIUM BLOCK)**

DRAWN BY - Ramprakash
DATE - 24-12-2013
SCALE - 1:100
DRG.NO. - AUDI./TE.F/06
JOB. NO. - BC/02/13
CHECKED BY - S.R.

SPACE ACE
ARCHITECTS, ENGINEERS &
PLANNERS

V-20A/5,
D.L.F. CITY III,
GURGAON, HARYANA - 122002
PH - 0124-4106618, FAX: 0124-2365329
E-MAIL : spaceace.india@gmail.com

DOOR & WINDOW SCHEDULE				
S.NO.	SYMBOL	SIZE	SILL LVL.	LINTEL LVL.
DOOR				
1	D	740X2100	0	2100
2	D	750X2100	0	2100
3	D1	900X2400	0	2400
4	D2	1000X2400	0	2400
5	D3	1070X2400	0	2400
6	D4	1200X2400	0	2400
7	D5	1500X2400	0	2400
8	D6	1800X2400	0	2400
9	D7	2000X2400	0	2400
10	D8	1730X2100	0	2100
11	DW	2400X2400	0	2400
12	DV	2025X4300	0	4300
13	DV1	1730X4300	0	4300
14	DV2	2380X3400	0	3400
15	DV3	2400X3400	0	3400
FIRE DOOR				
1	FCD	1730X2400	0	2400
2	FCD1	1500X2400	0	2400
WINDOW				
1	W	600X10500	900	11400
2	W	600X2500	900	3400
3	W1	1800X1500	900	2400
4	W1	843+843x1500	900	2400
5	W2	2000X1500	900	2400
6	W2	492+1393x1500	900	2400
7	W3	2100X1500	900	2400
8	W3	1168+817x1500	900	2400
9	W4	2400X1500	900	2400
10	W5	2290X1500	900	3400
11	W6	1300X2250	150	2400
12	W7	1450X2250	150	2400
13	W8	2030X2250	150	3400
14	W9	1730X4300	150	4450
15	W10	2000X1500	900	2400
16	W11	1730X13350	900	14250
VENTILATOR				
1	V	400X400	2630	3030
2	V	2000X750	3100	3850
3	V1	2100X750	3100	3850
4	V2	2100X900	2500	3400
5	V3	2100X1320	2080	3400
6	V4	2100X1720	1680	3400
7	V5	1800X2120	1280	3400
8	V5	1800X2120	1280	3400
9	V6	2000X2480	920	3400
10	V7	1800X750	3100	3850
11	V8	2100X300	3100	3400
12	V9	2290X300	3100	3400
13	V10	2400X300	3100	3400
14	V11	1090X300	3100	3400
ROLLING SHUTTER				
1	RS	3100X3400	0	3400
2	RS1	4000X2700	0	2700

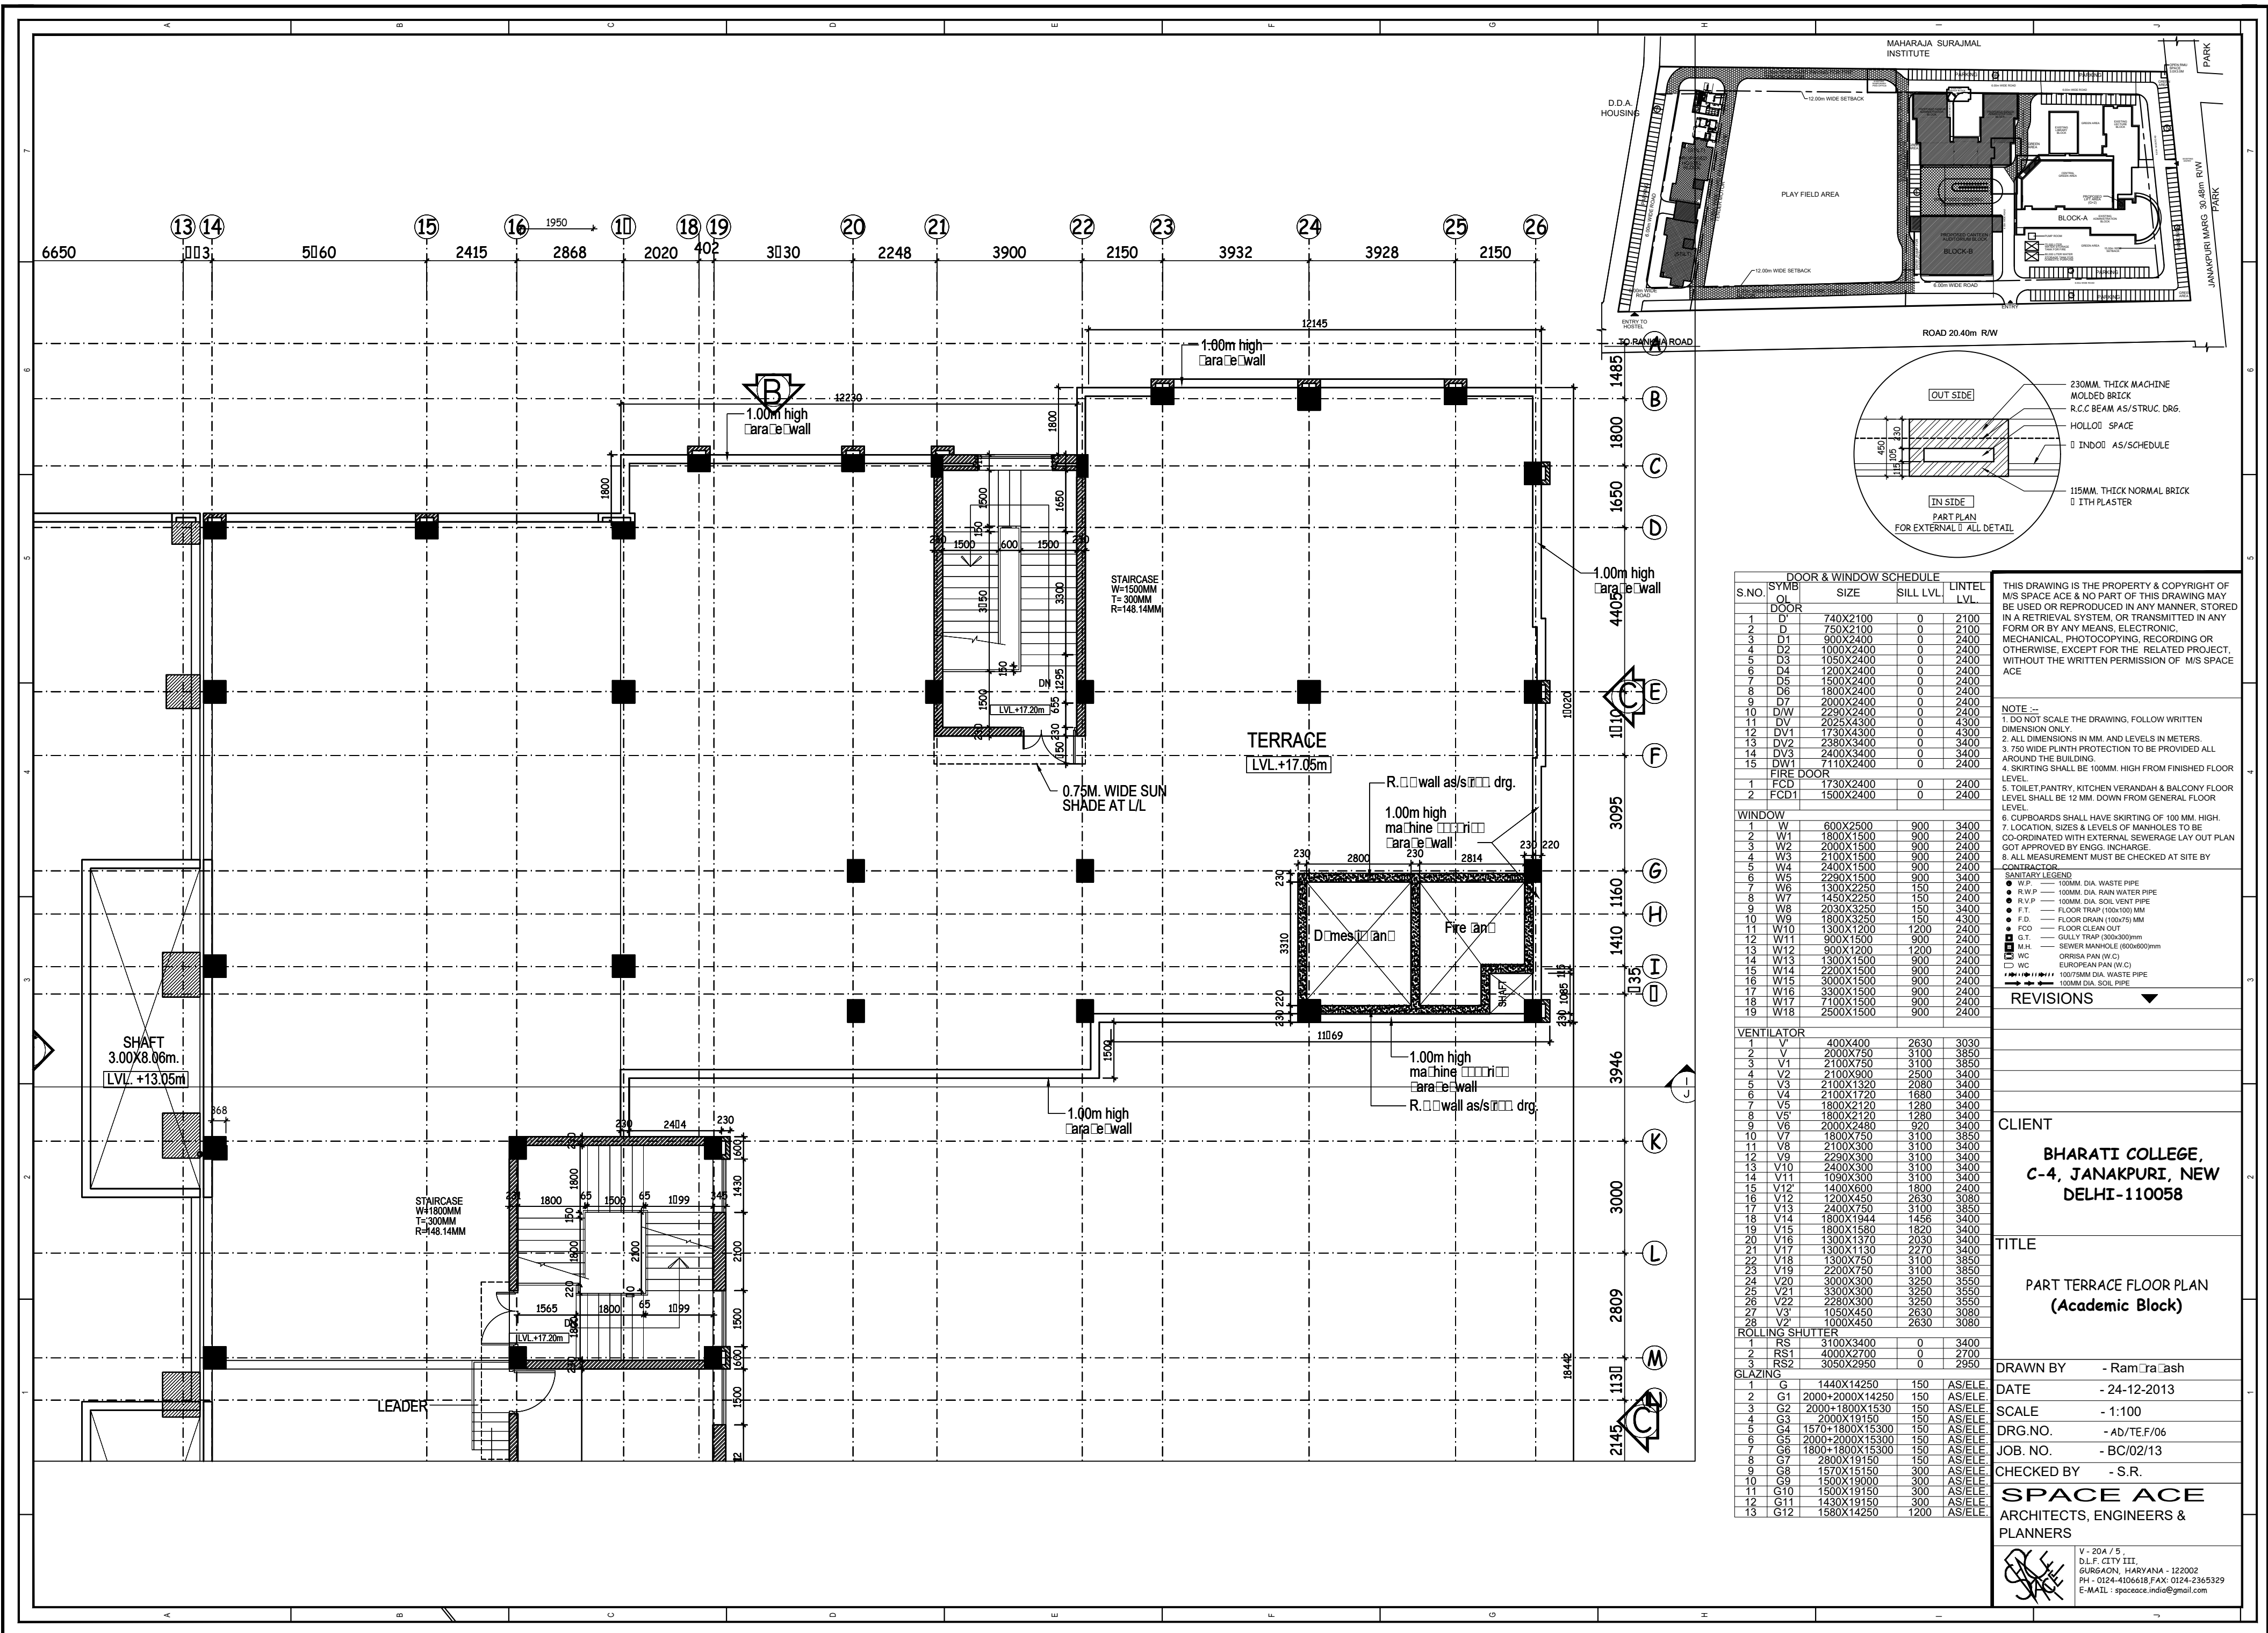

DOOR & WINDOW SCHEDULE			
S.NO.	SYMBOL	SIZE	LINTEL LVL.
1	D1	740X2100	0
2	D2	750X2100	0
3	D3	900X2400	0
4	D4	1000X2400	0
5	D5	1050X2400	0
6	D6	1200X2400	0
7	D7	1500X2400	0
8	D8	1800X2400	0
9	D9	2000X2400	0
10	D10	2290X2400	0
11	D11	2025X4300	0
12	D12	1730X4300	0
13	D13	2380X3400	0
14	D14	2400X3400	0
15	D15	7110X2400	0
1	FCD	1730X2400	0
2	FCD1	1500X2400	0

WINDOW			
1	W1	600X2500	900
2	W2	1800X1500	900
3	W3	2000X1500	900
4	W4	2400X1500	900
5	W5	2290X1500	900
6	W6	1300X2250	150
7	W7	1450X2250	150
8	W8	2030X3250	150
9	W9	1800X3250	150
10	W10	1300X1200	1200
11	W11	900X1500	900
12	W12	900X1200	1200
13	W13	1300X1500	900
14	W14	2200X1500	900
15	W15	3000X1500	900
16	W16	3300X1500	900
17	W17	7100X1500	900
18	W18	2500X1500	900

VENTILATOR			
1	V1	400X400	2630
2	V2	2100X750	3100
3	V3	2100X900	2500
4	V4	2100X1320	2080
5	V5	2100X1720	1680
6	V6	1800X2120	1280
7	V7	1800X2120	1280
8	V8	2000X2480	920
9	V9	1800X750	3100
10	V10	2100X300	3100
11	V11	1090X300	3100
12	V12	1400X600	1800
13	V13	1200X450	2630
14	V14	2400X750	3100
15	V15	1800X1944	1456
16	V16	1800X1580	1820
17	V17	1300X1370	2030
18	V18	1300X1130	2270
19	V19	1300X750	3100
20	V20	2200X750	3100
21	V21	3000X300	3250
22	V22	3300X300	3250
23	V23	2280X300	3250
24	V24	1050X450	2630
25	V25	1000X450	2630

ROLLING SHUTTER			
1	RS1	3100X3400	0
2	RS2	4000X2700	0
3	RS3	3050X2950	0

GLAZING			
1	G1	1440X14250	150
2	G2	2000+2000X14250	150
3	G3	2000+1800X1530	150
4	G4	2000X19150	150
5	G5	1570+1800X15300	150
6	G6	2000+2000X15300	150
7	G7	1800+1800X15300	150
8	G8	2800X19150	150
9	G9	1570X15150	300
10	G10	1500X15150	300
11	G11	1500X15150	300
12	G12	1430X19150	300
13	G13	1580X14250	1200

THIS DRAWING IS THE PROPERTY & COPYRIGHT OF M/S SPACE ACE & NO PART OF THIS DRAWING MAY BE USED OR REPRODUCED IN ANY MANNER, STORED IN A RETRIEVAL SYSTEM, OR TRANSMITTED IN ANY FORM OR BY ANY MEANS, ELECTRONIC, MECHANICAL, PHOTOCOPYING, RECORDING OR OTHERWISE, EXCEPT FOR THE RELATED PROJECT, WITHOUT THE WRITTEN PERMISSION OF M/S SPACE ACE

- NOTE :-
- DO NOT SCALE THE DRAWING, FOLLOW WRITTEN DIMENSION ONLY
 - ALL DIMENSIONS IN MM. AND LEVELS IN METERS.
 - 750 WIDE PLINTH PROTECTION TO BE PROVIDED ALL AROUND THE BUILDING.
 - SKIRTING SHALL BE 100MM. HIGH FROM FINISHED FLOOR LEVEL.
 - TOILET, PANTRY, KITCHEN VERANDAH & BALCONY FLOOR LEVEL SHALL BE 12 MM. DOWN FROM GENERAL FLOOR LEVEL.
 - CUPBOARDS SHALL HAVE SKIRTING OF 100 MM. HIGH.
 - LOCATION, SIZES & LEVELS OF MANHOLES TO BE CO-ORDINATED WITH EXTERNAL SEWERAGE LAY OUT PLAN GOT APPROVED BY ENGG. INCHARGE.
 - ALL MEASUREMENT MUST BE CHECKED AT SITE BY CONTRACTOR.

- SANITARY LEGEND
- W.P. 100MM DIA. WASTE PIPE
 - R.W.P. 100MM DIA. RAIN WATER PIPE
 - R.V.P. 100MM DIA. SOIL VENT PIPE
 - F.T. FLOOR TRAP (100/100) MM
 - F.D. FLOOR DRAIN (100/75) MM
 - F.C.O. FLOOR CLEAN OUT
 - G.T. GULLY TRAP (300x500)mm
 - M.H. SEWER MANHOLE (600x600)mm
 - WC ORRISA PAN (W.C)
 - WC EUROPEAN PAN (W.C)
 - 100/75MM DIA. WASTE PIPE
 - 100MM DIA. SOIL PIPE

REVISIONS

CLIENT

**BHARATI COLLEGE,
C-4, JANAKPURI, NEW
DELHI-110058**

TITLE

**PART TERRACE FLOOR PLAN
(Academic Block)**

DRAWN BY - Ramprakash

DATE - 24-12-2013

SCALE - 1:100


DRG. NO. - AD/TEF/06

JOB. NO. - BC/02/13


CHECKED BY - S.R.

SPACE ACE
ARCHITECTS, ENGINEERS &
PLANNERS

V - 20A / 5
D.L.F. CITY III,
GURGAON, HARYANA - 122002
PH - 0124-410618, FAX: 0124-2365329
E-MAIL : spaceace.india@gmail.com

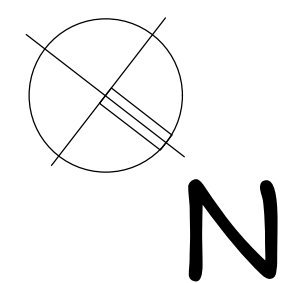

D.D.A.
HOUSING

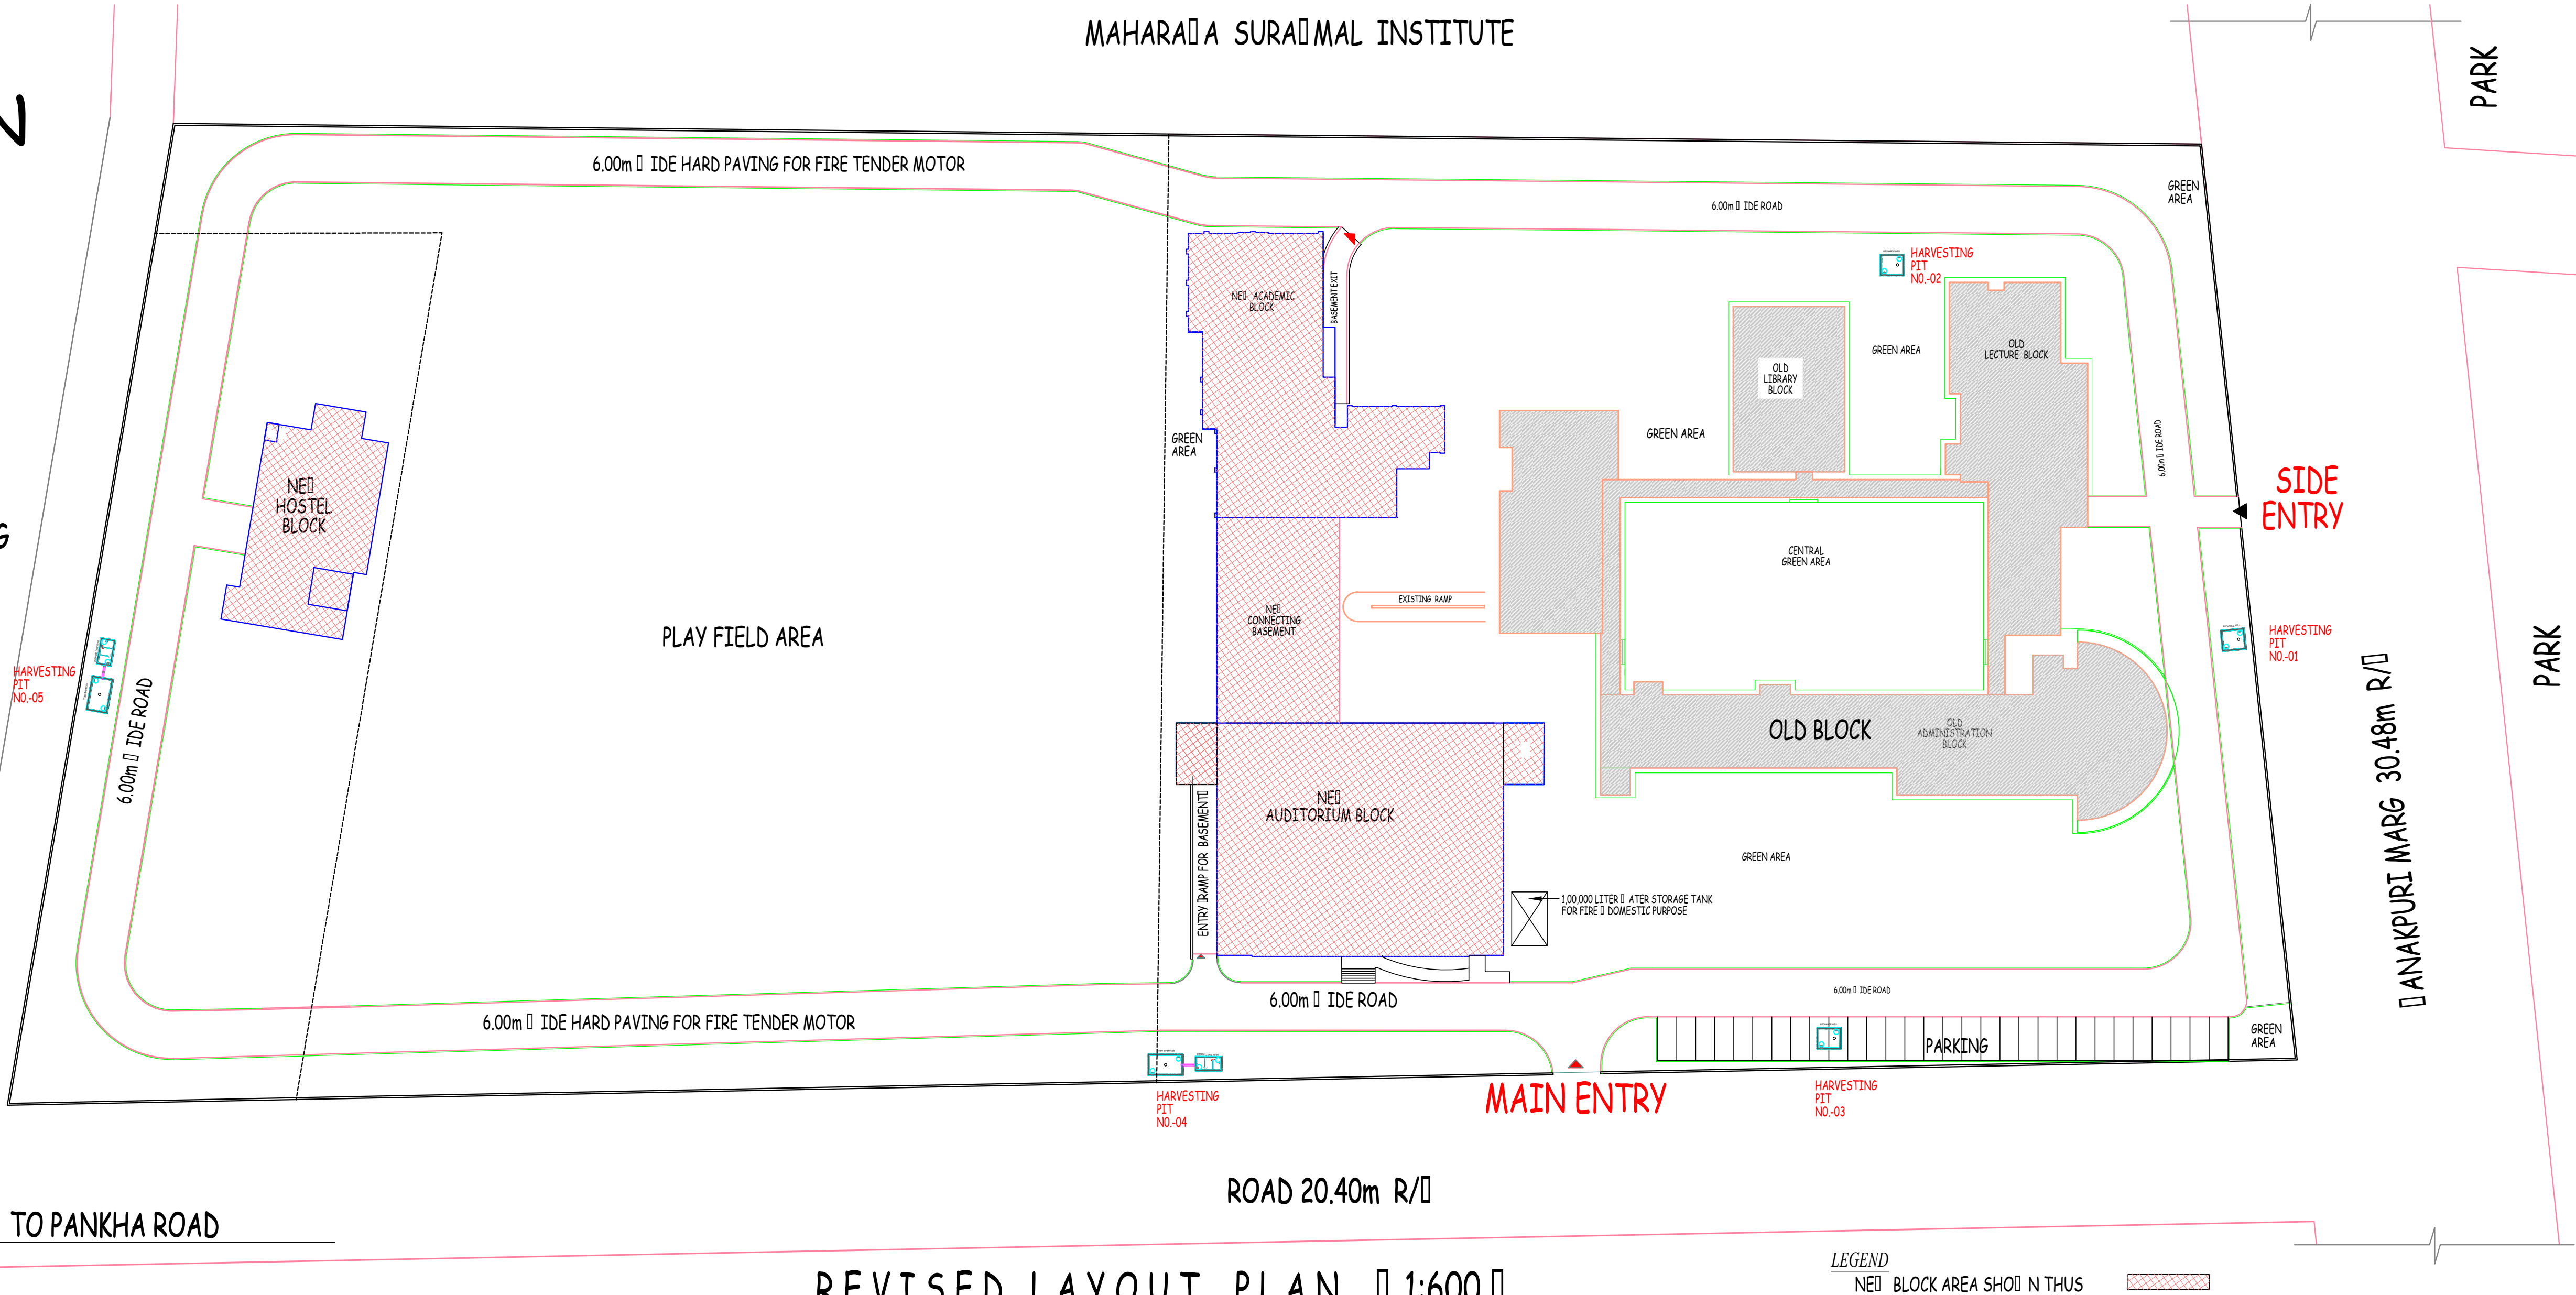

REVISED LAYOUT PLAN @ 1:600

LEGEND
NEW BLOCK AREA SHOWN IN THIS
OLD BLOCK AREA SHOWN IN THIS

THIS DRAWING IS THE PROPERTY & COPYRIGHT OF M/S SPACE ACE & NO PART OF THIS DRAWING MAY BE USED OR REPRODUCED IN ANY MANNER, STORED IN A RETRIEVAL SYSTEM, OR TRANSMITTED IN ANY FORM OR BY ANY MEANS, ELECTRONIC, MECHANICAL, PHOTOCOPYING, RECORDING OR OTHERWISE, WITHOUT THE WRITTEN PERMISSION OF M/S SPACE ACE

- NOTE :-
1. DO NOT SCALE THE DRAWING. FOLLOW THE GIVEN DIMENSION ONLY.
 2. ALL DIMENSIONS IN MM. AND LEVELS IN METERS.
 3. (ISO) THE PLINTH PROTECTION TO BE PROVIDED ALL AROUND THE BUILDING.
 4. SKIRTING SHALL BE 100MM. HIGH FROM FINISHED FLOOR LEVEL.
 5. TOILET/PANTRY, KITCHEN VERANDAH & BALCONY FLOOR LEVEL SHALL BE 12 MM. (00) IN FROM GENERAL FLOOR LEVEL.
 6. CLIPBOARDS SHALL HAVE SKIRTING OF 100 MM. HIGH.
 7. LOCATION, SIZES & LEVELS OF MANHOLES TO BE CO-ORDINATED WITH EXTERNAL SETBACK LAYOUT PLAN GOT APPROVED BY ENG. INCHARGE.
 8. ALL MEASUREMENT MUST BE CHECKED AT SITE BY CONTRACTOR.

SANITARY LEGEND	
1. P.F.	100MM. DIA. ASTE PIPE
2. R.D.P.	100MM. DIA. RAIN & WATER PIPE
3. R.V.P.	100MM. DIA. SOIL VENT PIPE
4. F.T.	FLOOR TRAP (3000/1000) MM
5. F.D.	FLOOR DRAIN (3000/150) MM
6. F.C.O.	FLOOR CLEAN OUT
7. G.T.	GULLY TRAP (3000/3000)mm
8. M.H.	SEWER MANHOLE (6000/6000)mm
9. O.R.E.S.H. PAN. ID. C2	ORRESHA PAN. ID. C2
10. E.C.	EUROPEAN PAN. ID. C2
11. 100/15MM DIA. ASTE PIPE	100/15MM DIA. ASTE PIPE
12. 100MM DIA. SOIL PIPE	100MM DIA. SOIL PIPE

REVISIONS

NO.	DESCRIPTION

CLIENT
**BHARATI COLLEGE,
C-4, JANAKPURI, NEW
DELHI-110058**


TITLE
MASTER PLAN

DRAWN BY	- PANKAJ
DATE	- 12-10-2020
SCALE	- 1:100
DRG. NO.	- SP/HP/01
DOB. NO.	- BC/02/13
CHECKED BY	- S.R.


SPACE ACE
ARCHITECTS, ENGINEERS & PLANNERS

 V-20A/5,
D.L.F. CITY III,
GURGAON, HARYANA - 122002
PH - 0124-4106618, FAX - 0124-2365329
E-MAIL : spaceace.india@gmail.com


DOORS & WIDOWS SCHEDULE					
S. No.	Symbol	Width	Height	Cill Lvl.	Lintel Lvl.
1	D1	750	2100	-----	2100
2	D2	900	2200	-----	2200
3	D4	1200	2200	-----	2200
4	D5	1500	2200	-----	2200
5	GD2	3055	2850	-----	-----
6	W2	1300	1350	850	2200
7	W2a	535	1350	850	2200
8	W3	1600	2000	850	2850
9	V4	1300	400	2450	2850
10	V3	1200	400	2450	2850
11	V5	1500	400	2450	2850
12	SW2	400	9150	1150	10900
13	V4a	535	400	2450	2850
14	HW1	1800	400	1850	2200
15	V1	900	400	1850	2200

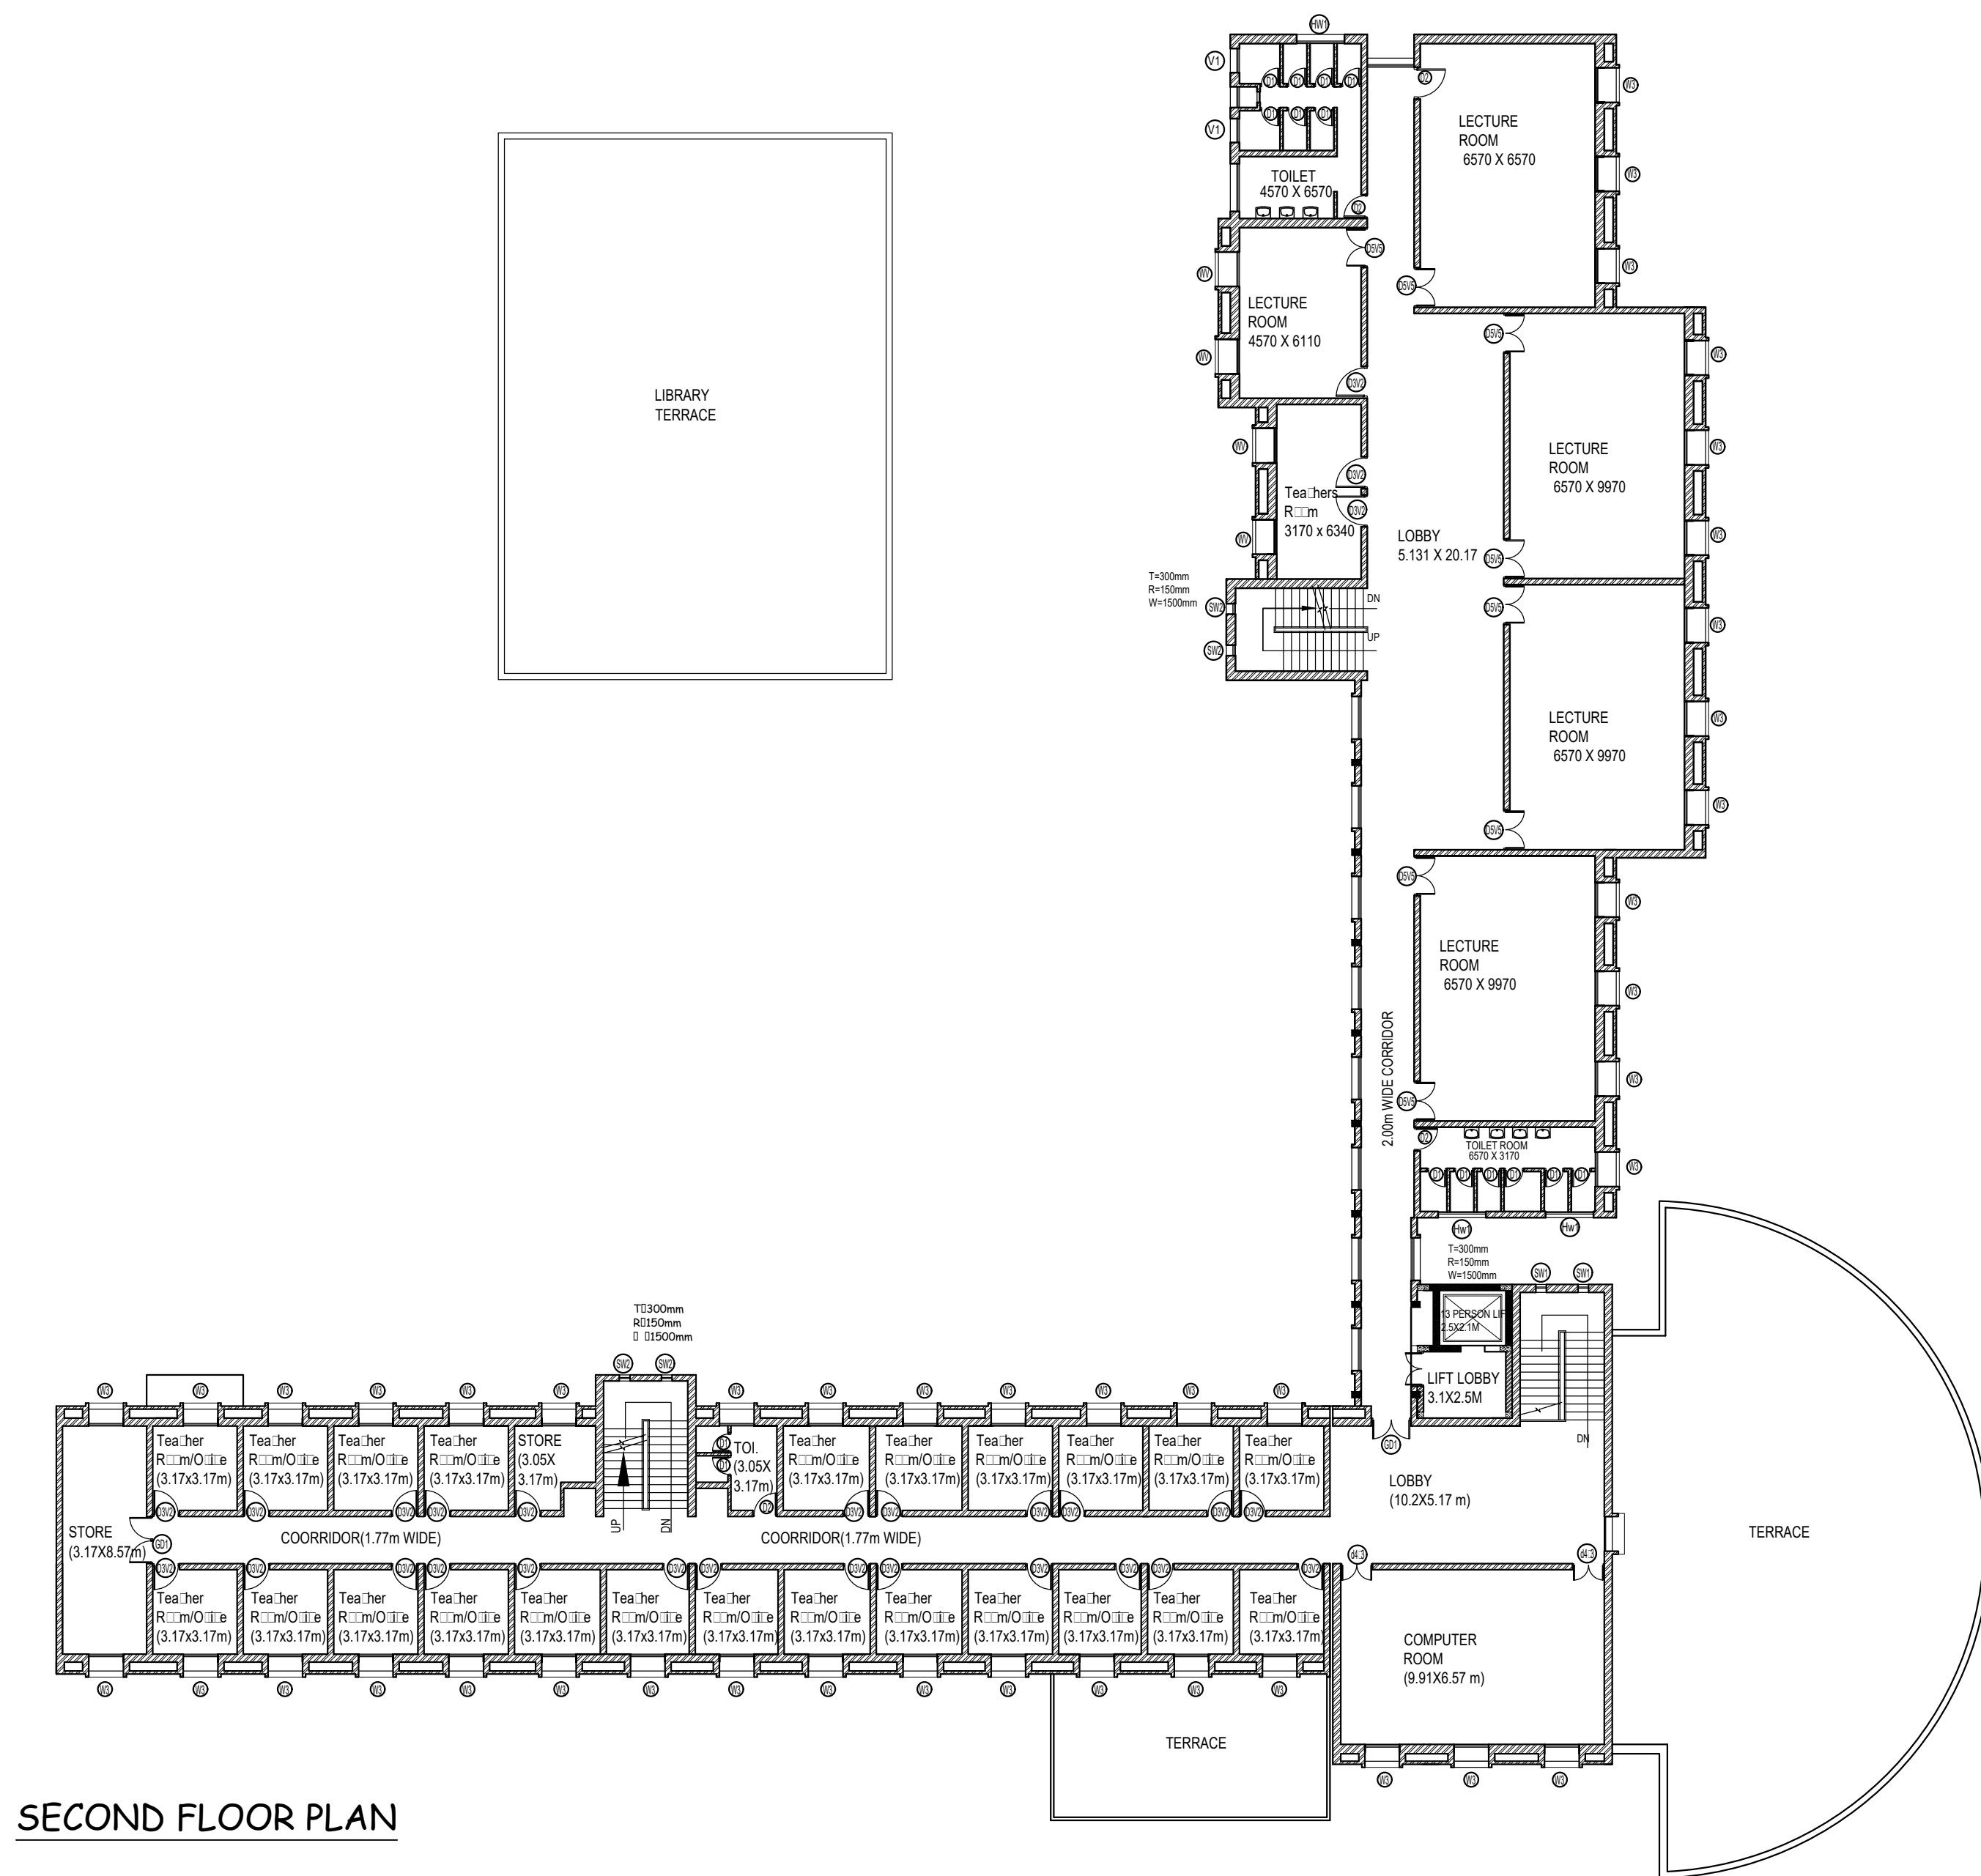

SECOND FLOOR PLAN

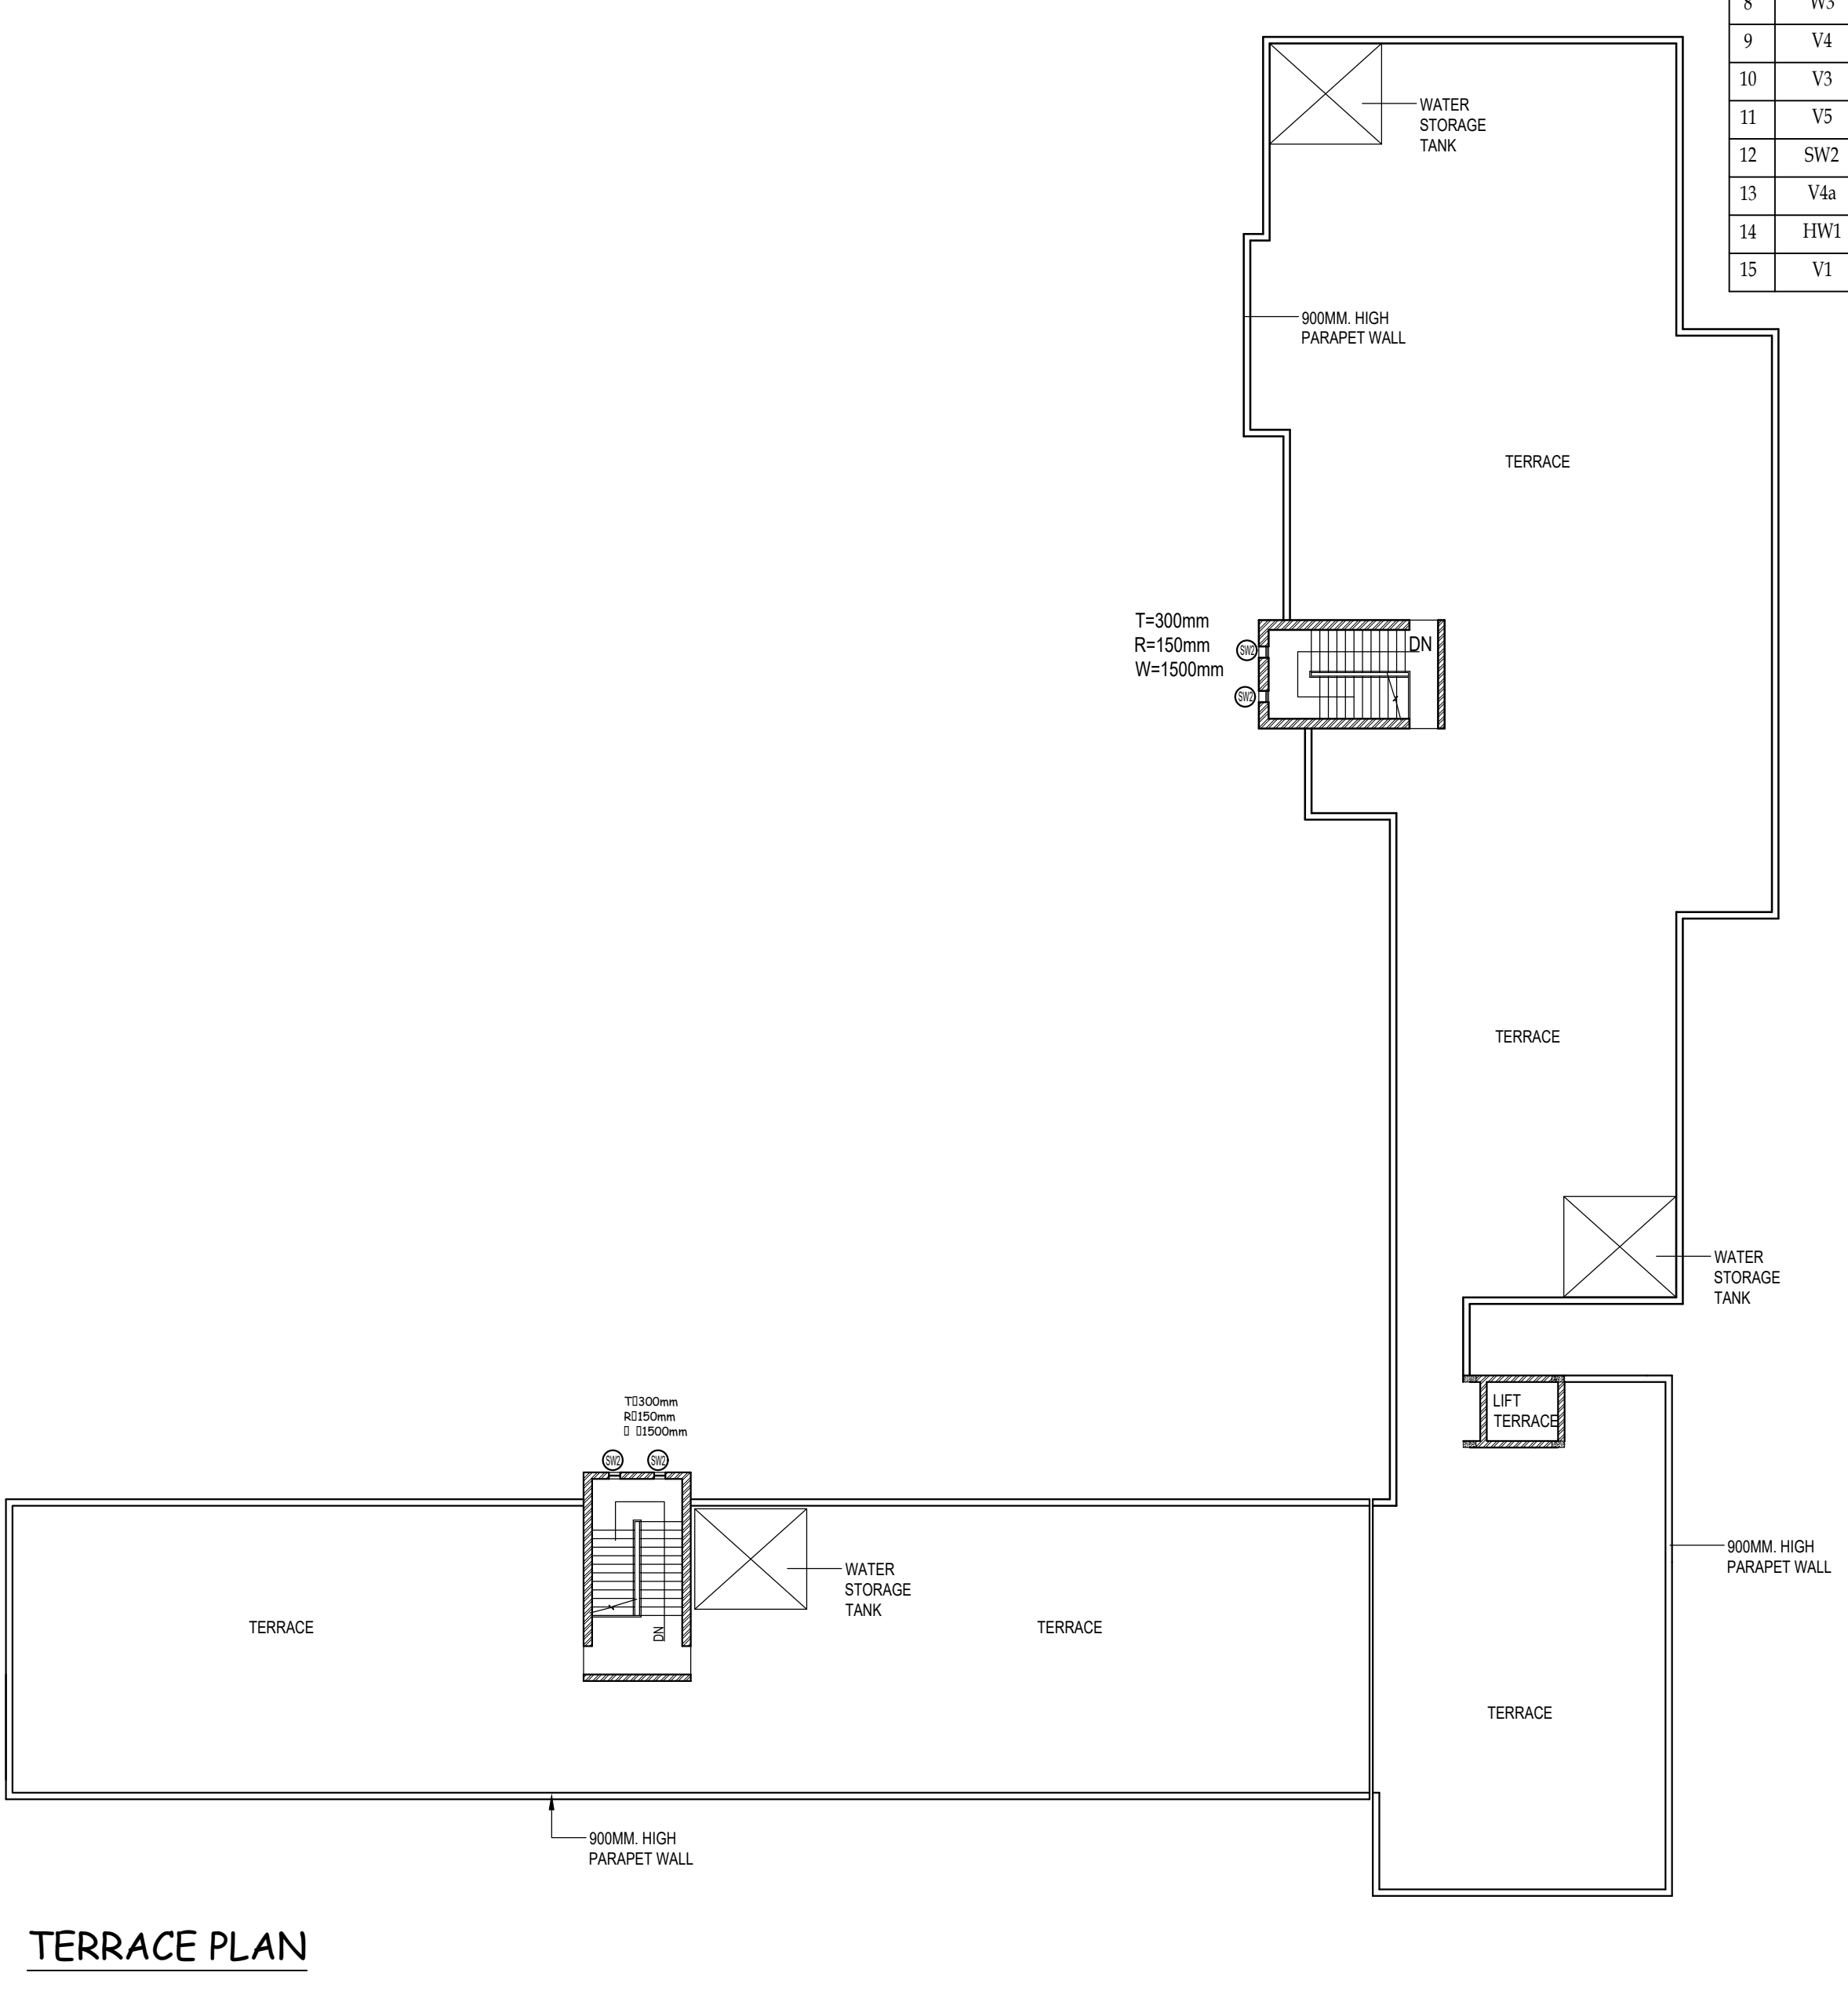


TERRACE PLAN

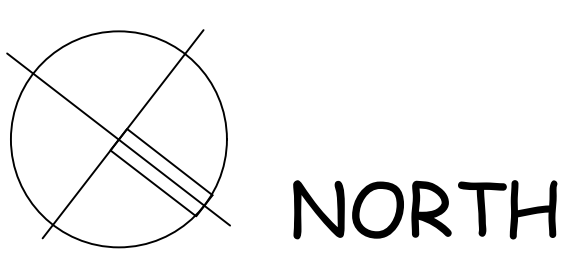


SCALE
1 : 100

TITLE
OLD BUILDING FLOOR
PLANS


PROJECT
BHARTI MAHILA COLLEGE,
ANAKPURI, NEW DELHI

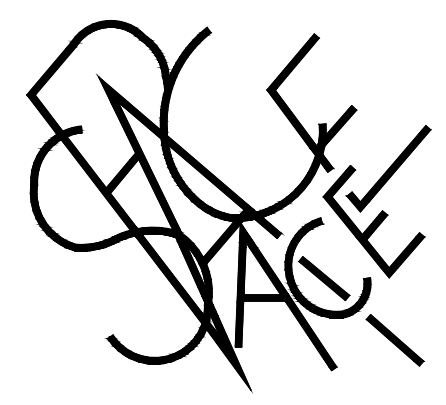

M/S SPACE ACE
V - 20A / 5 , D.L.F. CITY III,
GURGAON, HARYANA - 122002
PH - 0124-4106618
FAX: 0124-2365329
E-MAIL : spaceace.india@gmail.com

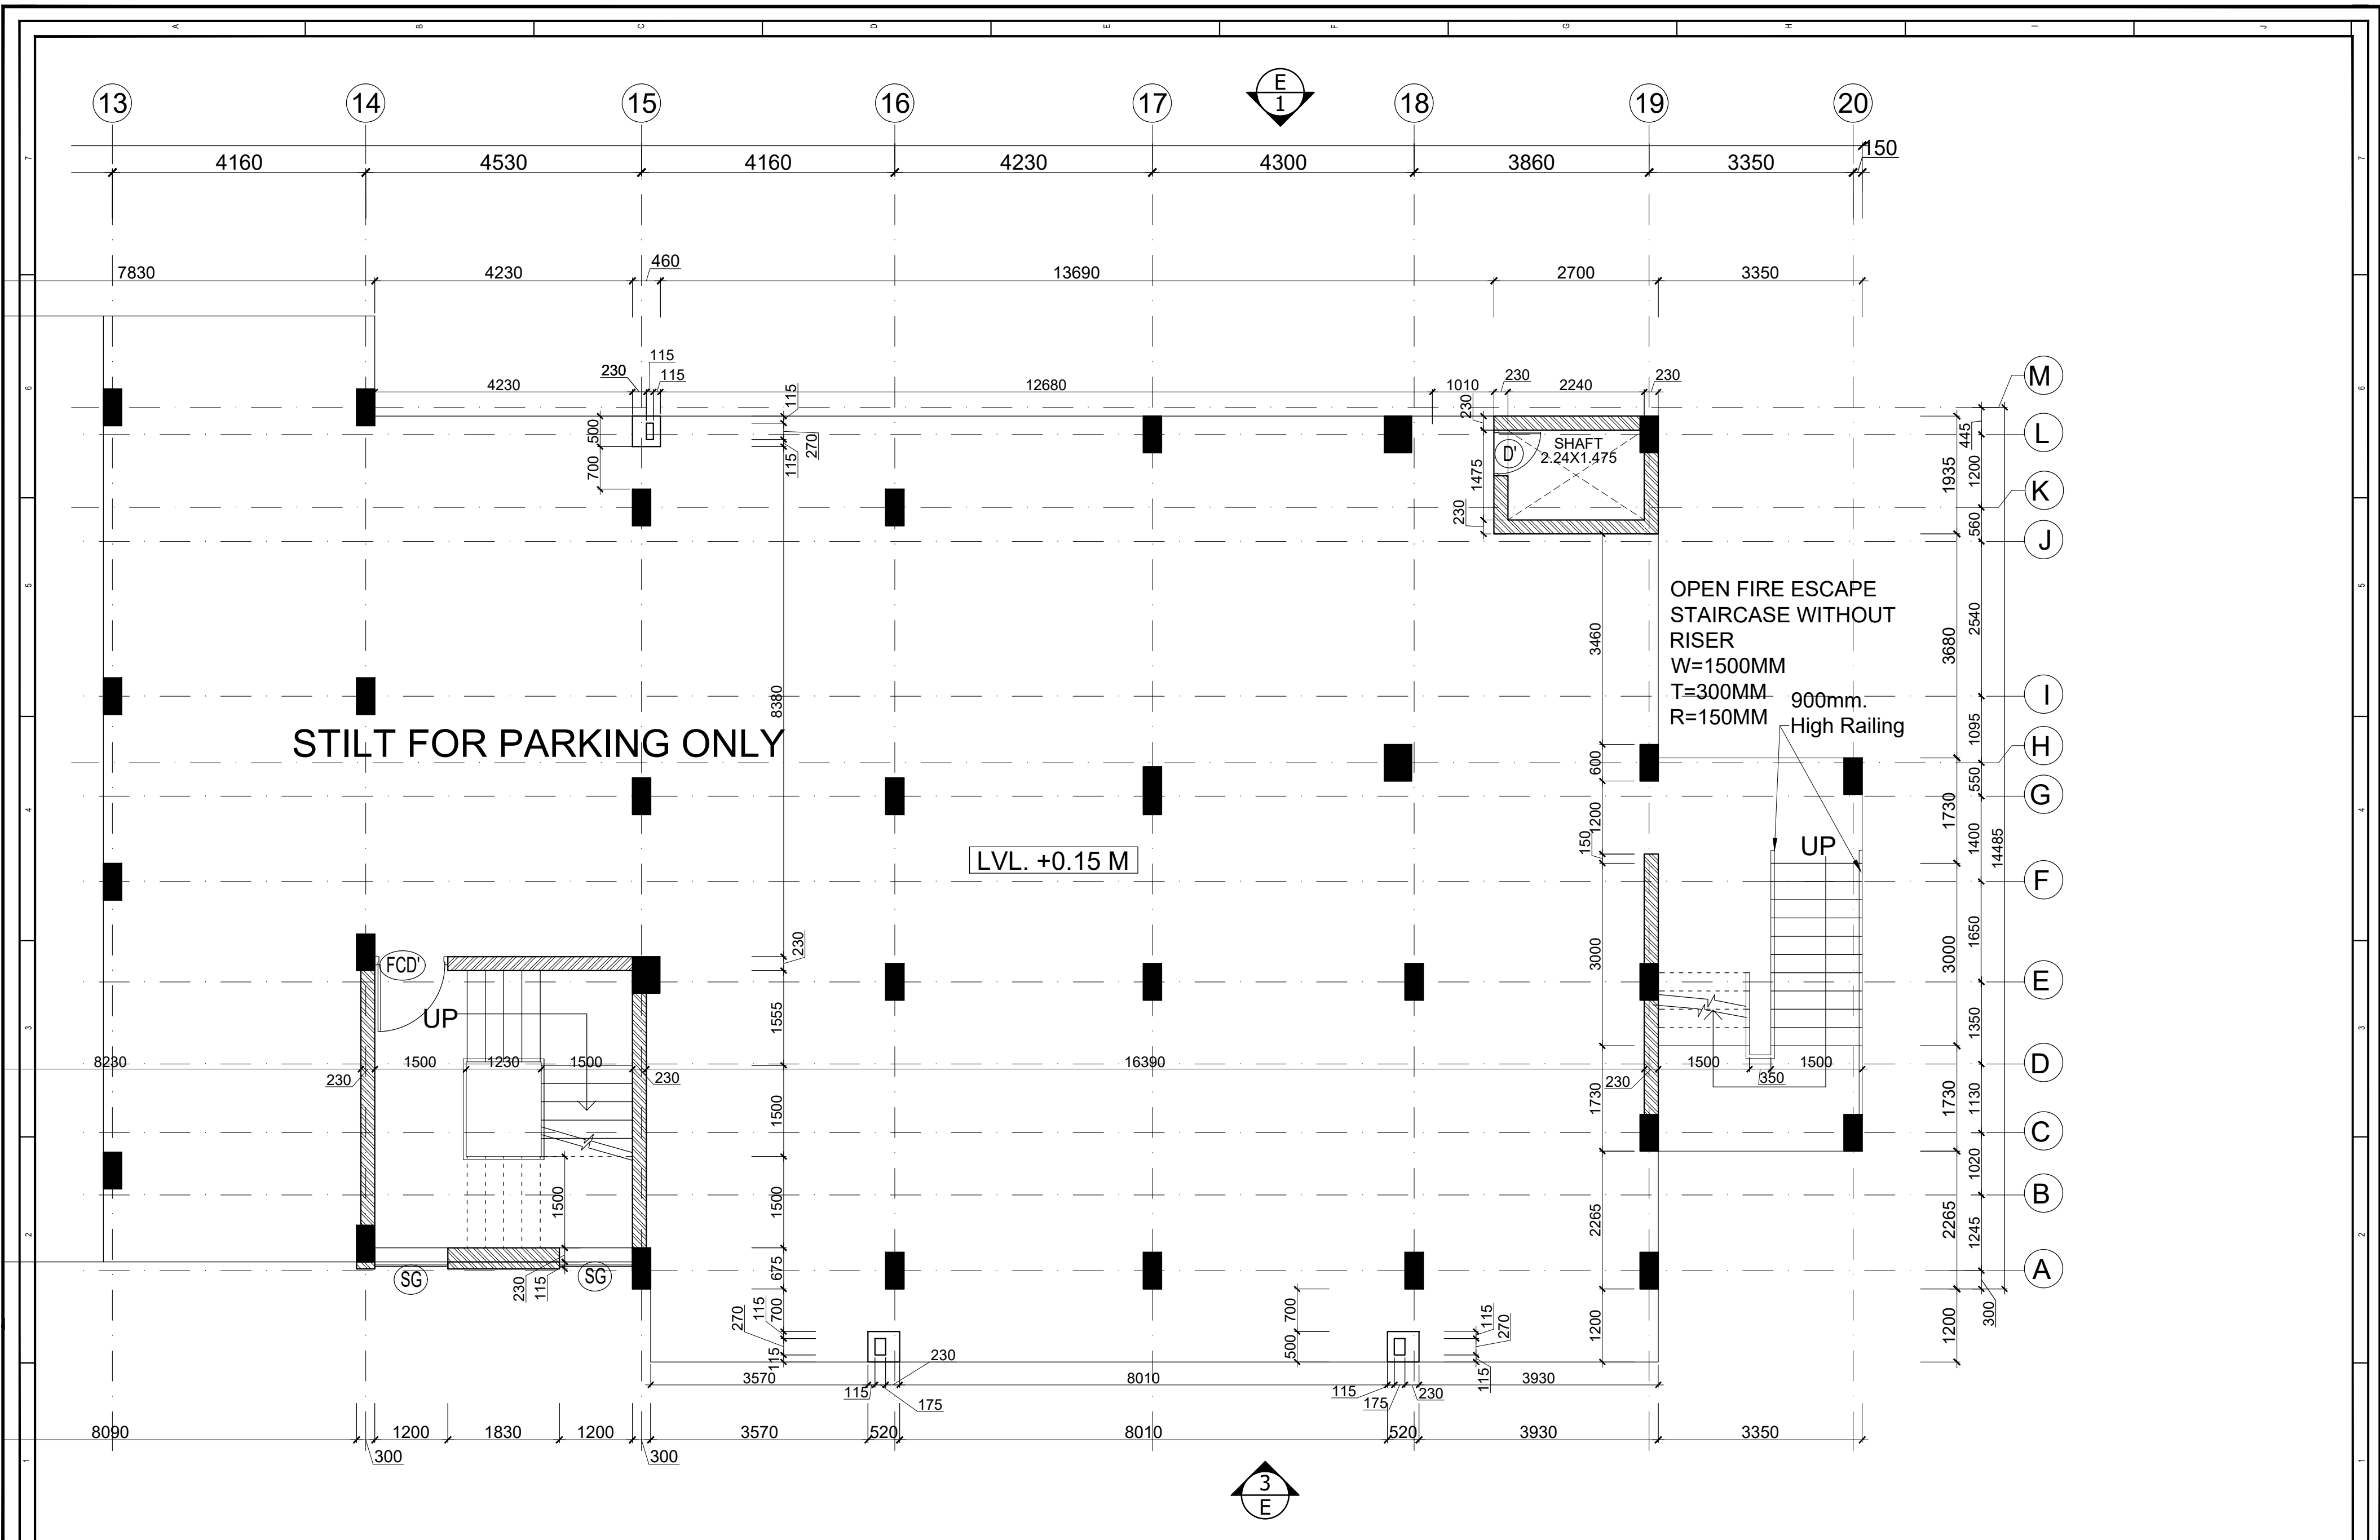

THIS DRAWING IS THE PROPERTY & COPYRIGHT OF M/S SPACE ACE & NO PART OF THIS DRAWING MAY BE USED OR REPRODUCED IN ANY MANNER, STORED IN A RETRIEVAL SYSTEM, OR TRANSMITTED IN ANY FORM OR BY ANY MEANS, ELECTRONIC, MECHANICAL, PHOTOCOPYING, RECORDING OR OTHERWISE, EXCEPT FOR THE RELATED PROJECT, WITHOUT THE WRITTEN PERMISSION OF M/S SPACE ACE	SANITARY LEGEND 100 DIA. WASTE PIPE (W.P.) 100 DIA. RAIN WATER PIPE (R.W.P.) 100 DIA. SOIL PIPE/SOIL VENT PIPE (S.V.P.) G.T. 300X300 GULLY TRAP M.H. MAN HOLE WASTE PIPE 100 DIA. SOIL PIPE 100 DIA. ORRISA PAN (W.C.) EUROPEAN W.C. PAN	NOTE :- 1. DO NOT SCALE THE DRAWING. FOLLOW WRITTEN DIMENSION ONLY. 2. ALL DIMENSIONS IN MM. AND LEVELS IN METERS. 3. 750 WIDE PLINTH PROTECTION TO BE PROVIDED ALL AROUND THE BUILDING. 4. SKIRTING SHALL BE 100MM. HIGH FROM FINISHED FLOOR LEVEL. 5. TOILET/PANTRY, KITCHEN VERANDAH & BALCONY FLOOR LEVEL SHALL BE 12 MM. DOWN FROM GENERAL FLOOR LEVEL. 6. CUPBOARDS SHALL HAVE SKIRTING OF 100 MM. HIGH. 7. LOCATION, SIZES & LEVELS OF MANHOLES TO BE CO-ORDINATED WITH EXTERNAL SEWERAGE LAY OUT PLAN GOT APPROVED BY ENGG. INCHARGE. 8. ALL MEASUREMENT MUST BE CHECKED AT SITE BY CONTRACTOR.	REVISIONS R1 12-02-2014 R2 20-02-2014 R3 05-04-2016	DRAWN BY - RUBY DATE - 29-08-2013 SCALE - 1:50 DRG.NO. - 6H/50.F/01 JOB. NO. - BH.C/JNK/13 CHECKED BY - RAMPRAKASH	TITLE PART STILT FLOOR PLAN GIRLS HOSTEL BLOCK	CLIENT BHARATI COLLEGE	SPACE ACE ARCHITECTS, ENGINEERS & PLANNERS V - 20A / 5, D.L.F. CITY III, GURGAON, HARYANA - 122002 PH - 0124-4106618, FAX: 0124-2365329 E-MAIL : spaceace.india@gmail.com
--	--	--	---	--	---	--	---

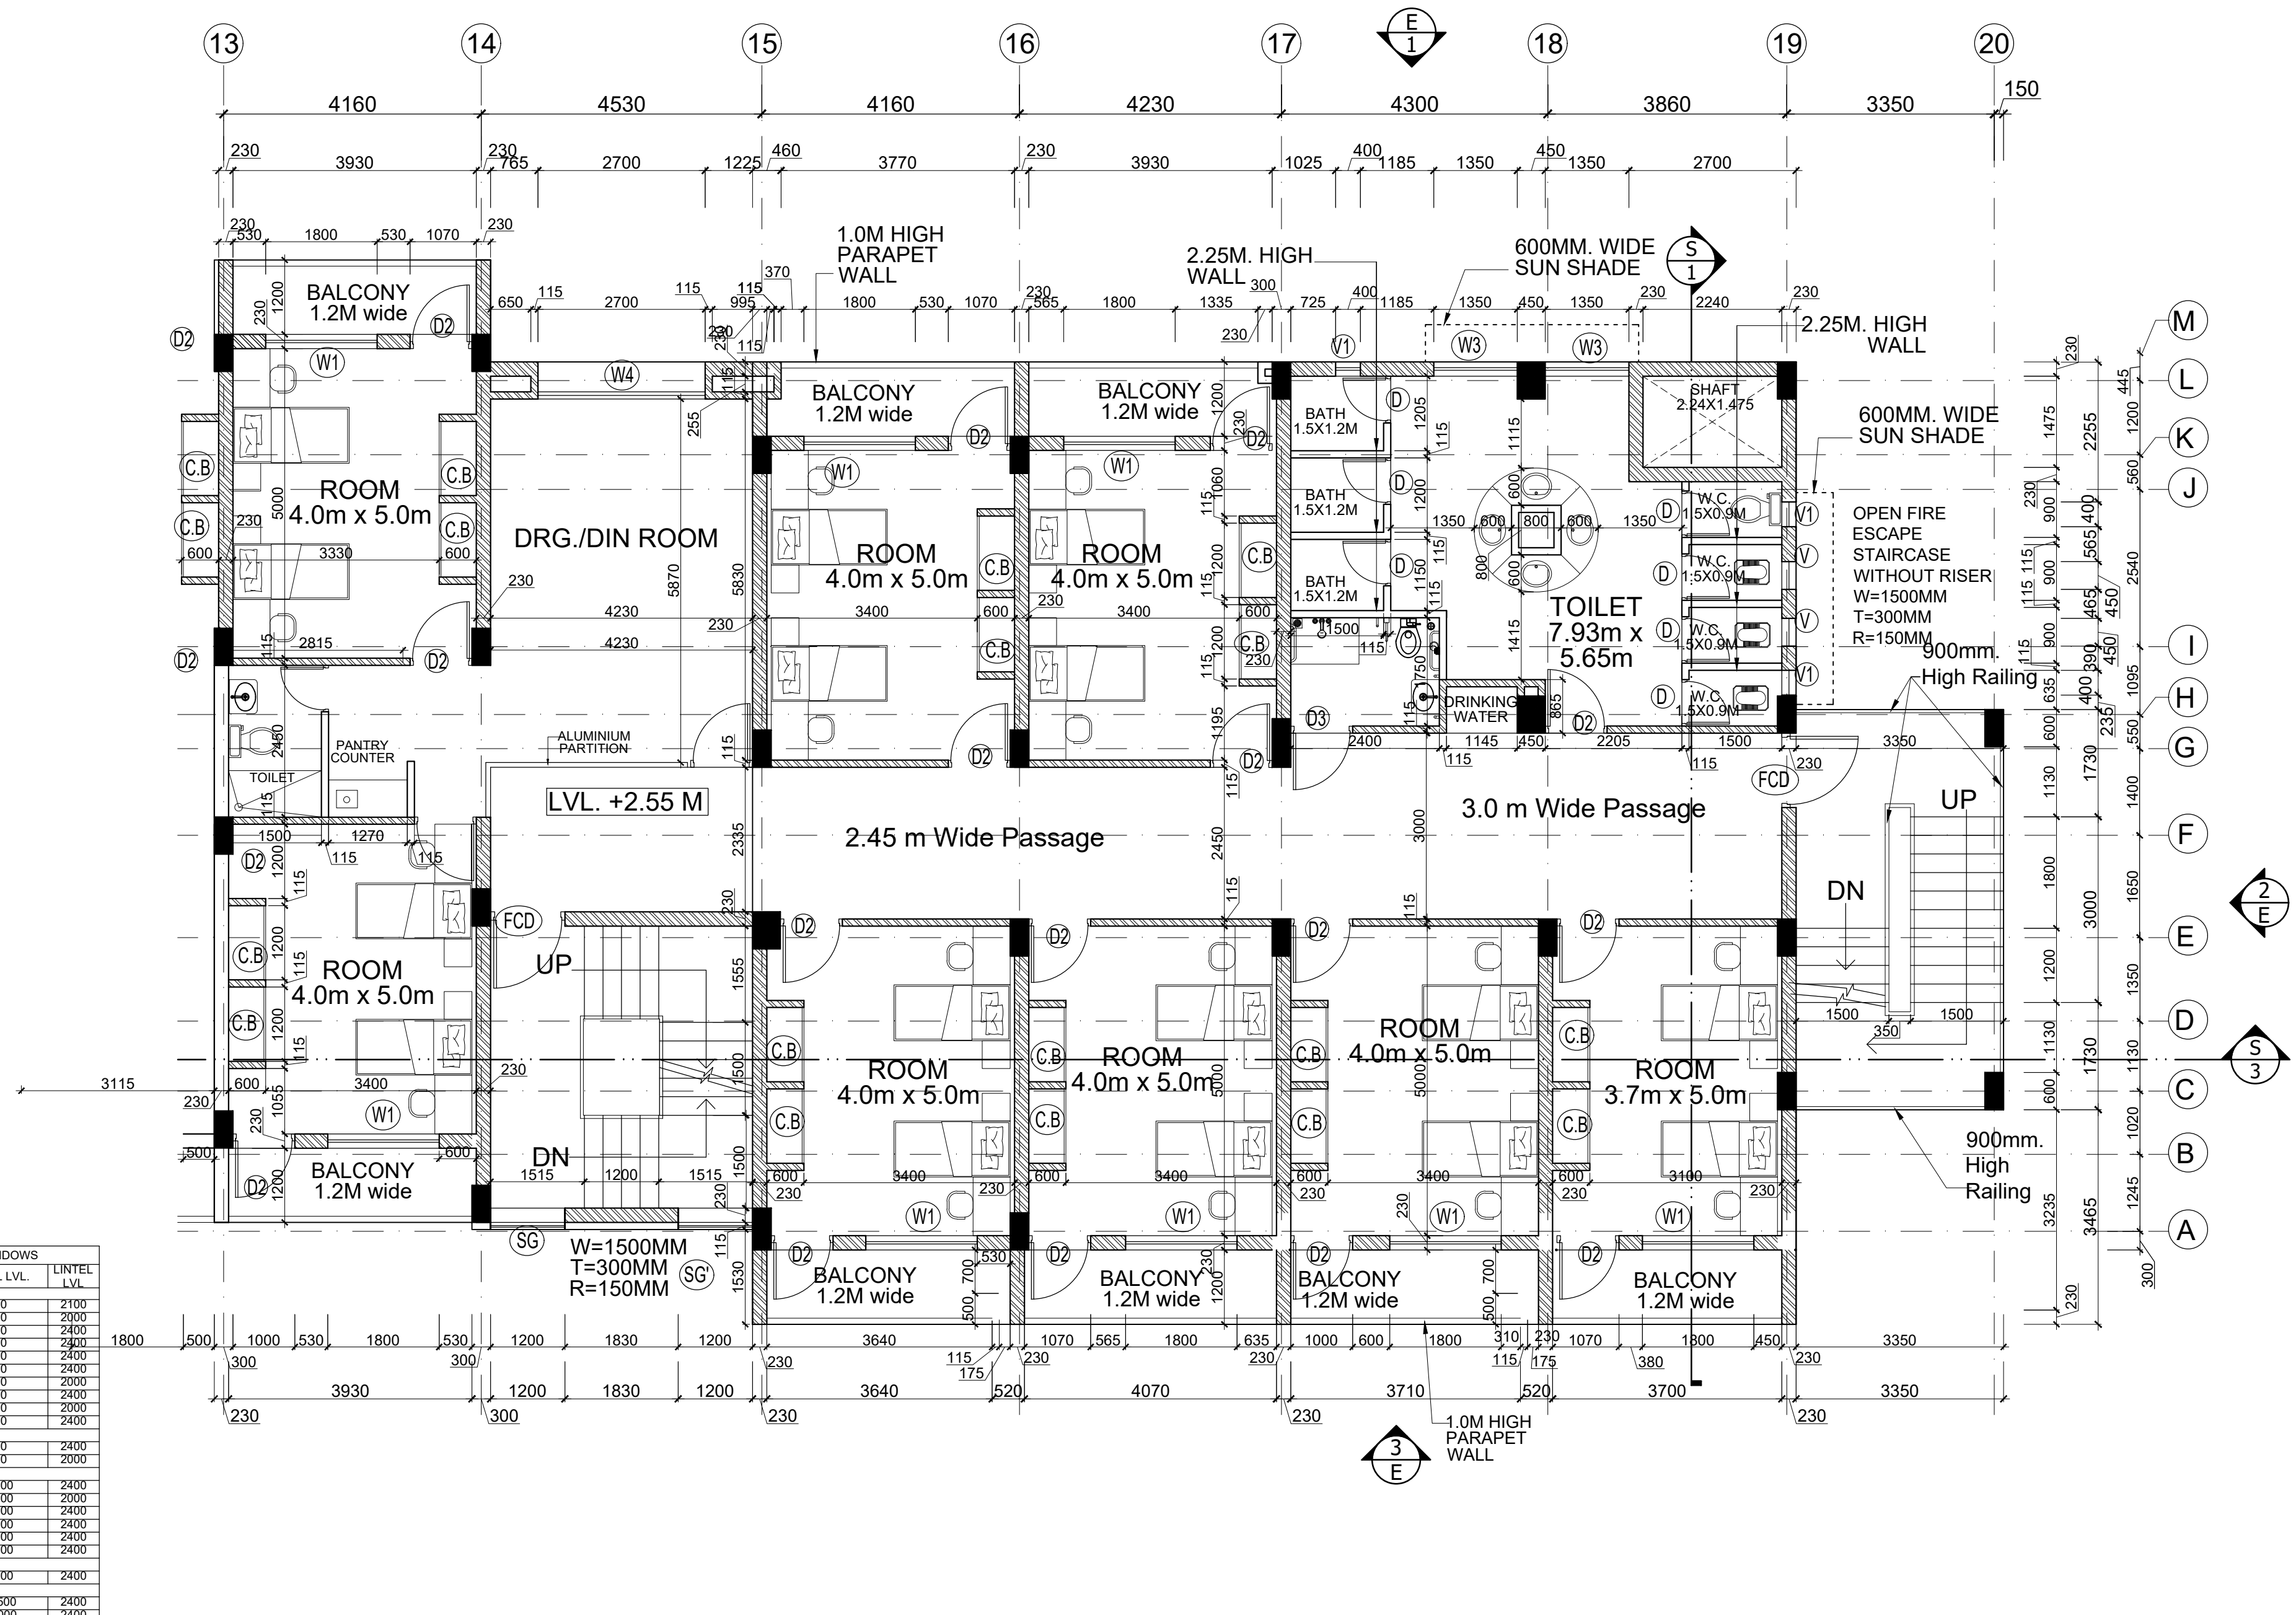

SCHEDULE OF DOORS & WINDOWS				
S.NO.	SYMBOL	SIZE	SILL LVL.	LINTEL LVL.
DOORS				
1	D	750X2100	0	2100
2	D'	750X2000	0	2000
3	D1	900X2400	0	2400
4	D2	1000X2400	0	2400
5	D3	1000X2400	0	2400
6	D4	1800X2400	0	2400
7	D4'	1800X2000	0	2000
8	D5	1500X2400	0	2400
9	DE	2400X2000	0	2000
10	DE1	2400X2400	0	2400
FIRE DOOR				
1	FCD	1200X2400	0	2400
2	FCD'	1200X2000	0	2000
WINDOWS				
1	W	1800X2100	300	2400
2	W'	1800X1700	300	2000
3	W1	1800X1500	900	2400
4	W2	1500X1500	900	2400
5	W3	1350X1500	900	2400
6	W4	2700X1500	900	2400
DOOR-WINDOW				
1	DW1	3000X2400	900	2400
VENTILATOR				
1	V	450X900	1500	2400
2	V1	400X400	2000	2400

THIS DRAWING IS THE PROPERTY & COPYRIGHT OF M/S SPACE ACE & NO PART OF THIS DRAWING MAY BE USED OR REPRODUCED IN ANY MANNER, STORED IN A RETRIEVAL SYSTEM, OR TRANSMITTED IN ANY FORM OR BY ANY MEANS, ELECTRONIC, MECHANICAL, PHOTOCOPYING, RECORDING OR OTHERWISE, EXCEPT FOR THE RELATED PROJECT, WITHOUT THE WRITTEN PERMISSION OF M/S SPACE ACE

SANITARY LEGEND

- 100 DIA. WASTE PIPE (W.P.)
- 100 DIA. RAIN WATER PIPE (R.W.P.)
- 100 DIA. SOIL PIPE/SOIL VENT PIPE (S.V.P.)
- G.T. 300X300 GULLY TRAP
- M.H. MAN HOLE
- WASTE PIPE 100 DIA.
- SOIL PIPE 100 DIA.
- ORRISA PAN (W.C.)
- EUROPEAN W.C. PAN

NOTE :-

- DO NOT SCALE THE DRAWING, FOLLOW WRITTEN DIMENSION ONLY.
- ALL DIMENSIONS IN MM. AND LEVELS IN METERS.
- 750 WIDE PLINTH PROTECTION TO BE PROVIDED ALL AROUND THE BUILDING.
- SKIRTING SHALL BE 100MM. HIGH FROM FINISHED FLOOR LEVEL.
- TOILET PANTRY, KITCHEN VERANDAH & BALCONY FLOOR LEVEL SHALL BE 12 MM. DOWN FROM GENERAL FLOOR LEVEL.
- CUPBOARDS SHALL HAVE SKIRTING OF 100 MM. HIGH.
- LOCATION, SIZES & LEVELS OF MANHOLES TO BE CO-ORDINATED WITH EXTERNAL SEWERAGE LAY OUT PLAN GOT APPROVED BY ENGG. INCHARGE.
- ALL MEASUREMENT MUST BE CHECKED AT SITE BY CONTRACTOR.

REVISIONS		DRAWN BY	- RUBY
R1	12-02-2014	DATE	- 29-08-2013
R2	20-02-2014	SCALE	- 1:50
R3	24-04-2014	DRG.NO.	- 6H/6.F/02
		JOB. NO.	- BH.C/JNK/13
		CHECKED BY	- RAMPRAKASH

TITLE

PART UPPER GROUND FLOOR PLAN
GIRLS HOSTEL BLOCK

CLIENT

BHARATI COLLEGE

SPACE ACE
ARCHITECTS, ENGINEERS & PLANNERS

V- 20A / 5,
D.L.F. CITY III,
GURGAON, HARYANA - 122002
PH - 0124-410618, FAX: 0124-2365329
E-MAIL : spaceace.india@gmail.com